


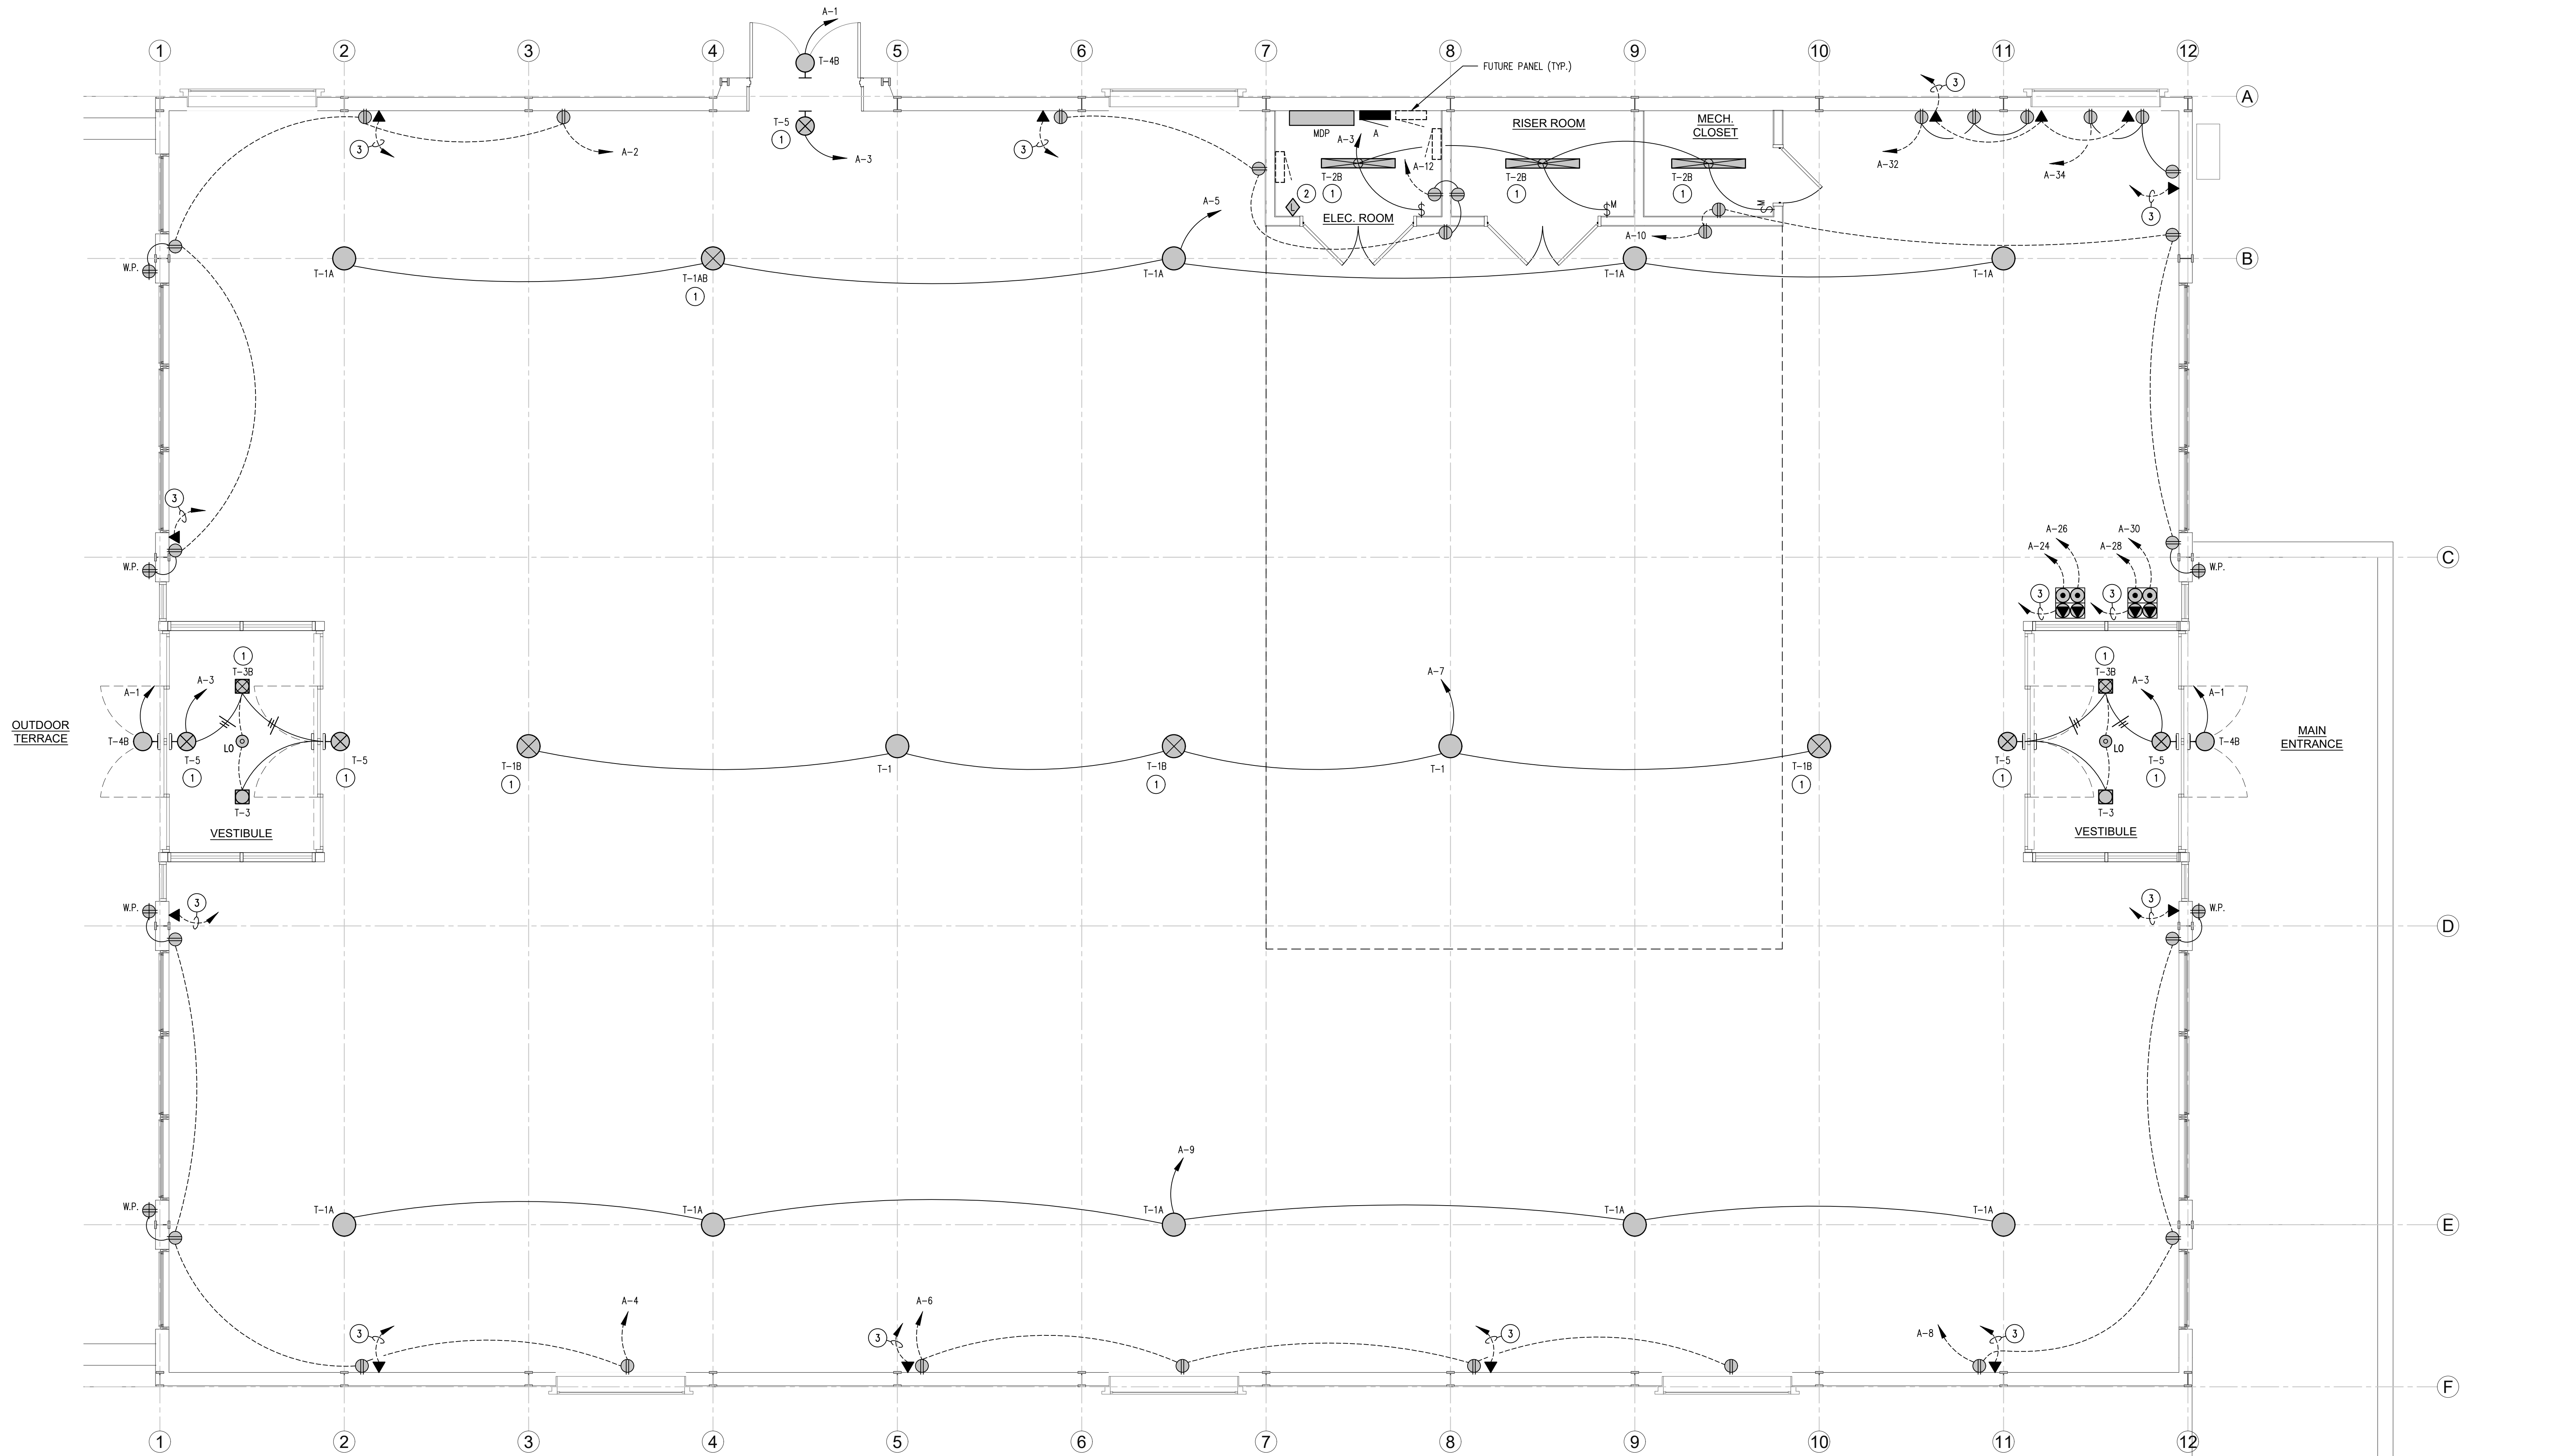


MAIN LEVEL ELECTRICAL PLAN
SCALE: 1/8" = 1'-0"

MASTER LUMINAIRE SCHEDULE						
TYPE	MANUFACTURER	CATALOG NUMBER	VOLTS	MOUNTING	LAMPS	WATTS
DESCRPT: 15" ROUND (3.5" DEEP), CAST, 27000 LUMENS, 195W, IK10 RATED, 4K, 5-YR WARRANTY, nLIGHT						
T-1	LITHONIA	CPRB AL014 MVOLT 40K 80CRI MS00PD17 ADC 0V DMH	120	26"-0" A.F.F.	LED (INCLUDED)	195
T-1A SAME AS T-1 EXCEPT 24,000 LUMENS (175W)						
T-1AB SAME AS T-1A EXCEPT WITH 40W EMERGENCY BATTERY (FIELD INSTALLED)						
T-1B SAME AS T-1 EXCEPT WITH 40W EMERGENCY BATTERY (FIELD INSTALLED)						
DESCRPT: 5.5x42" LINEAR STRIP, 4K, 5000 LUMENS, 31.8W						
T-2B	LITHONIA	CLX L48 5000LM SEF FDL MVOLD G21 40K 80CRI	120	CEILING	LED (INCLUDED)	32
T-2B WH E10W						
T-3B SAME AS T-3 EXCEPT WITH 7W EMERGENCY BATTERY						
DESCRPT: 7"x9" WEDGE, LED, WIDE VISUAL COMFORT, 1200 LUMENS, 10W COLD WEATHER EMERGENCY BATTERY						
T-4B	LITHONIA	WDEZ2 LED P1 SW 300 80CRI VM SRM EZ0WC PRPFC	120	WALL @ 8'-6" (V.I.E.)	LED (INCLUDED)	10
T-4B 3V 52BA						
DESCRPT: EXIT SIGN, DIE-CAST ALUMINUM, SELF DIAGNOSTIC, 2.5W						
T-5	LITHONIA	LE S W1 G EL N SD	120	WALL ABOVE DOOR	LED (INCLUDED)	3
T-5						

- KEY NOTES
- 1 CONNECT EMERGENCY BATTERY TO A NON-SWITCHED POWER SOURCE.
 - 2 PROVIDE AND INSTALL A WIRELESS CONTROL SWITCH FOR DINING AREA LIGHT CONTROL (SENSOR SWITCH @PODBOX WH).
 - 3 PROVIDE AND INSTALL A 1" CONDUIT WITH PULL CORD TO ELECTRICAL ROOM.
 - 4 THIS LUMINAIRE IS PROVIDED WITH AN INTEGRATED DAYLIGHT AND MOTION SENSOR TO COMPLY WITH WEBER COUNTY REQUIREMENTS. SET MOTION SENSOR TO TURN OFF FIXTURE WITHIN TWO MINUTES OF LAST DETECTED MOTION.

ISSUED	
08.27.2025	BUILDING PERMIT SUBMITTAL
09.05.2025	DESIGN REVIEW SUBMITTAL

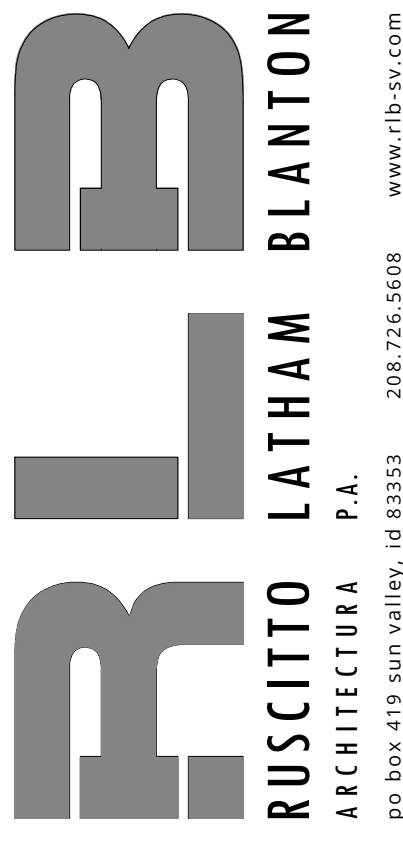

SNOWBASIN SKI RESORT
MEADOW LODGE
WEBER COUNTY, UTAH



CONSULTANTS

NELSON ENGINEERING, INC.
Consulting Engineers
156 North Twelfth Avenue
Pocatello, Idaho 83201
Ph: (208) 232-2577
FAX: (208) 234-0918

OWNERSHIP OF DOCUMENTS
This document, including the ideas and designs incorporated herein, is the property of NELSON ENGINEERING, INC. and shall not be used, in whole or in part, for any other project without the written permission of an authorized representative of NELSON ENGINEERING, INC. Unauthorized use will be prosecuted to the fullest extent of the law.
Copyright © 2025 by NELSON ENGINEERING, INC.

COPYRIGHT © 2025
DRAWING

ELECTRICAL PLAN

DWG. #

E1.0