


C:\USERS\DEREK\HYDRO\ACQ\DOCS\AQUA ENGINEERING\002923.C - NORDIC WATERWATER PLANT DESIGN\PROJECT FILES\001 SITE CIVIL\011-01C203 - SITE PLAN.DWG

9/24/2025

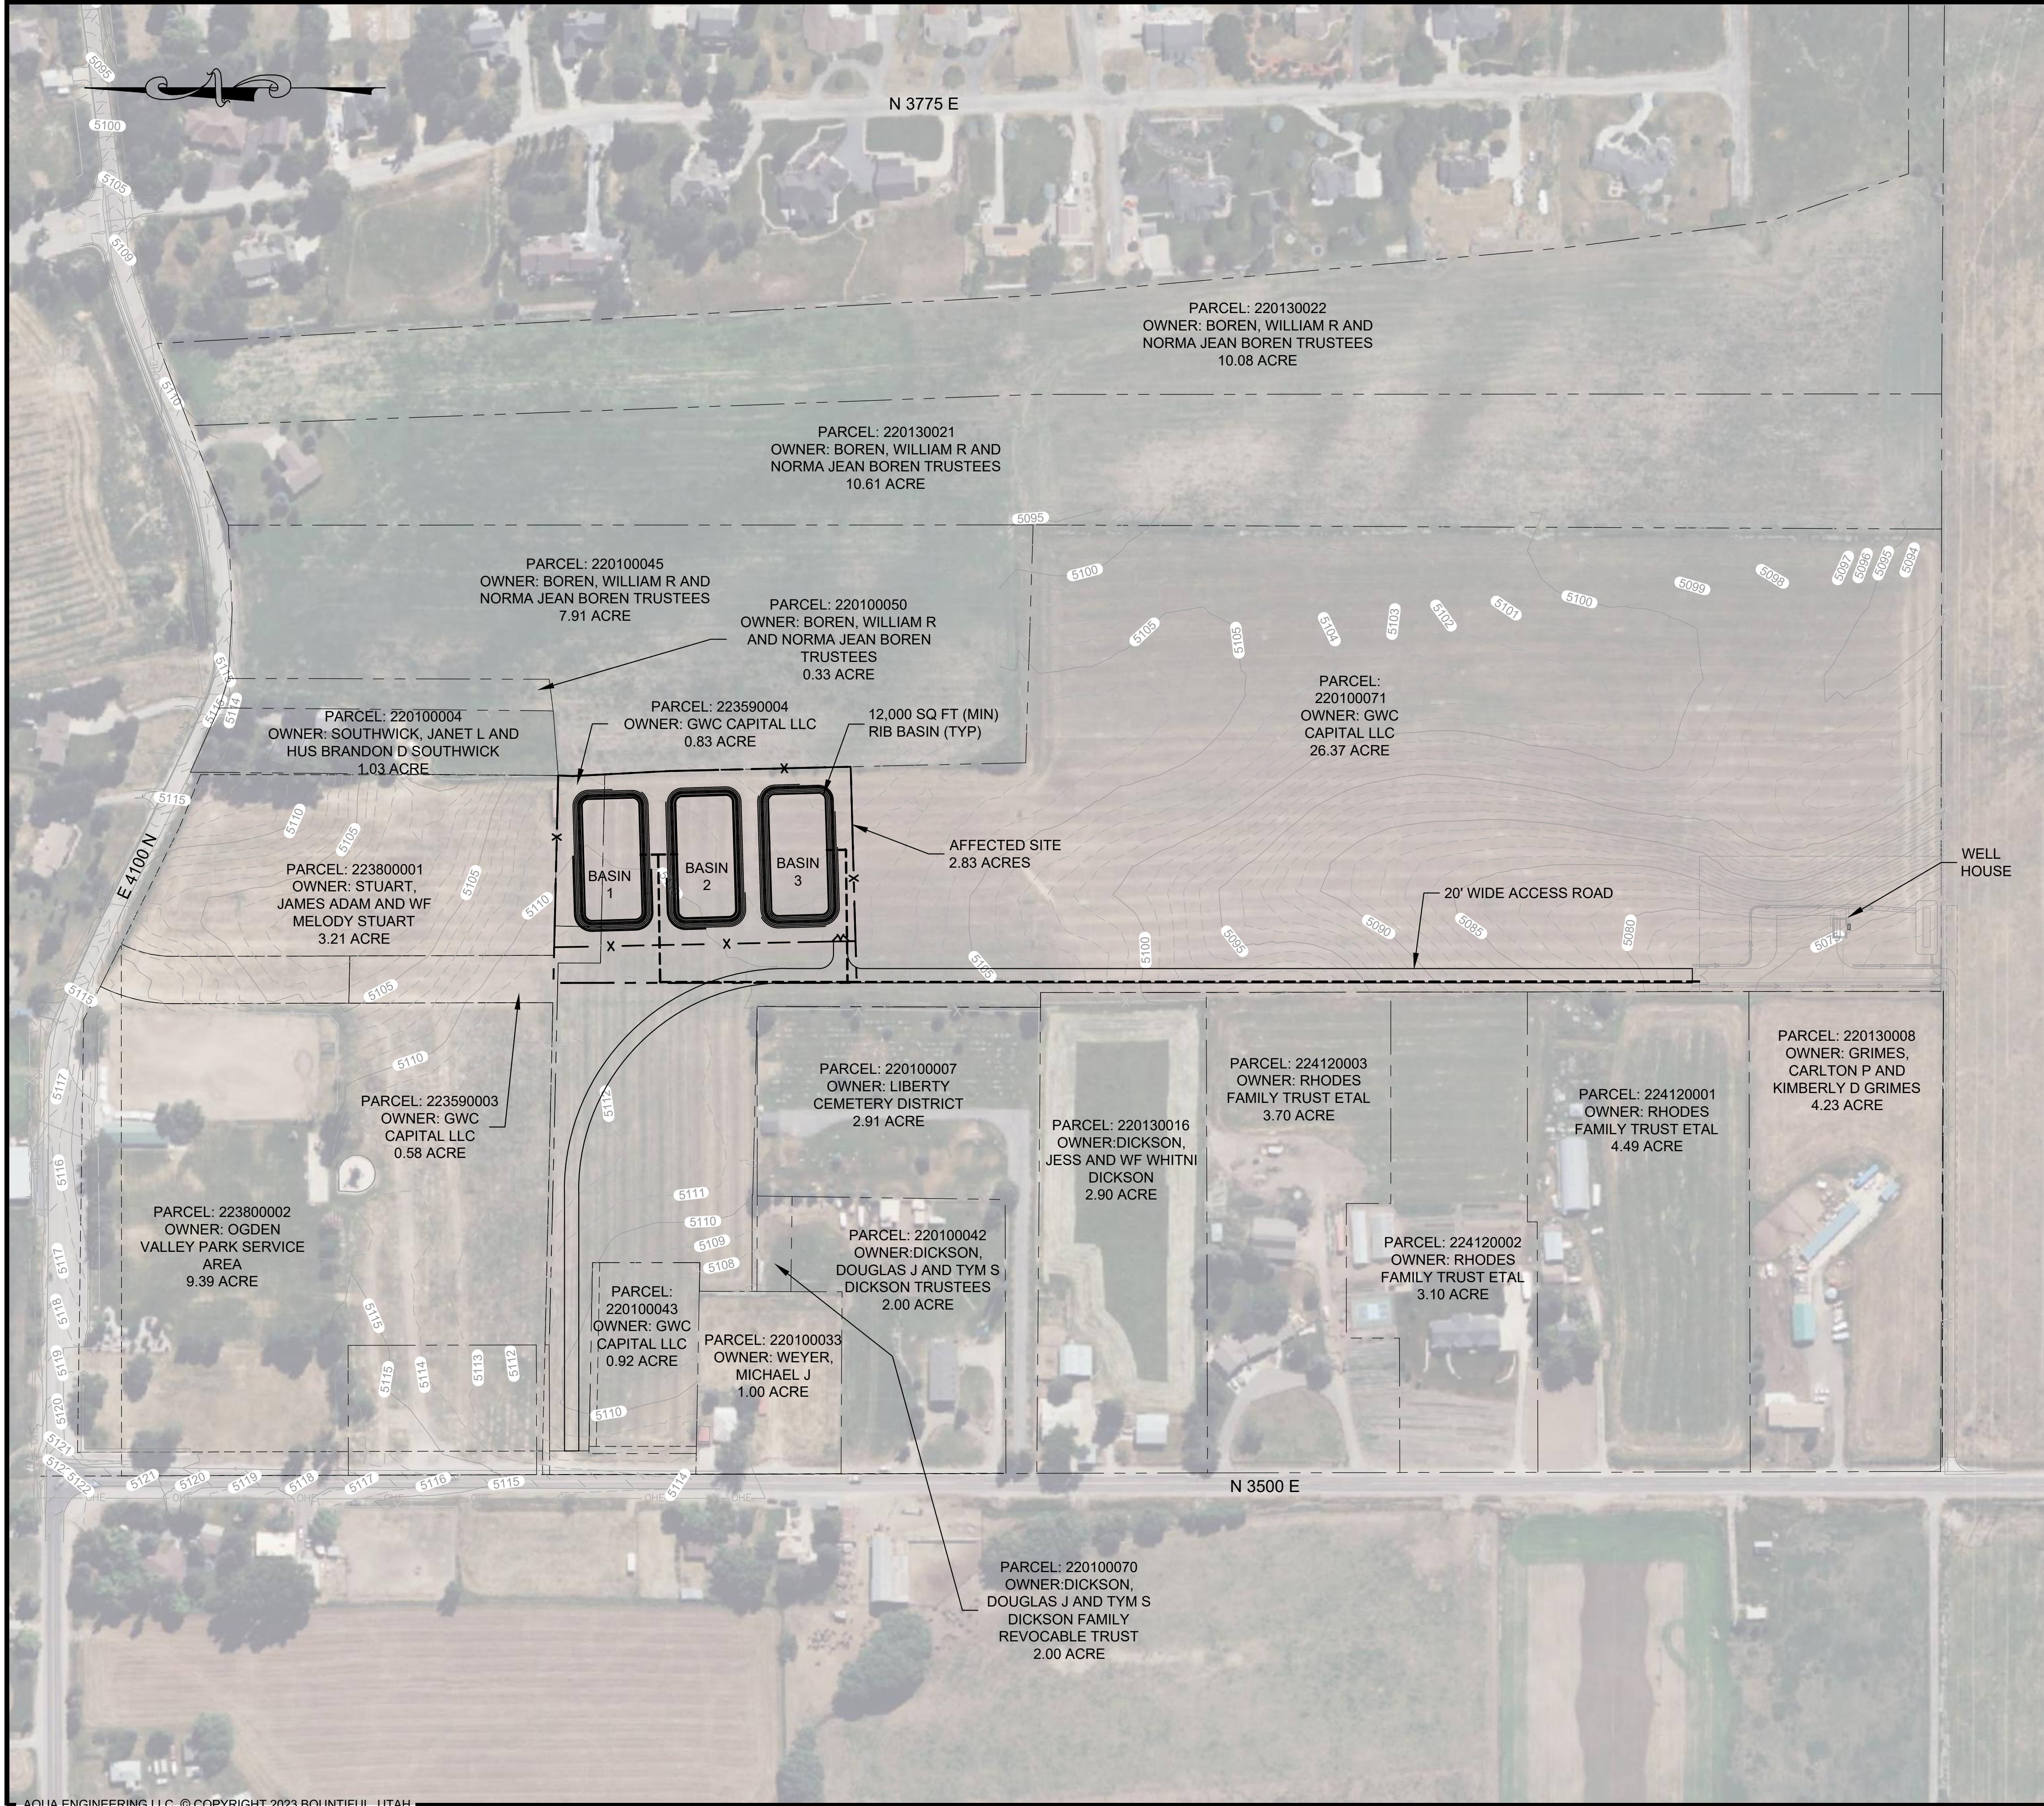

NOTES:

KEYNOTES:

RIB OVERALL SITE PLAN

1"=120'-0"

0 120 240

Scale in Feet

ORIGINAL			
NO.	DATE	DESIGN	DRAWN
0	09/25/2025	ML	DCH

CHECKED			
NO.	DATE	DESIGN	DRAWN
		ML	DCH

REVISIONS			
NO.	DATE	DESIGN	DRAWN

NORDIC VALLEY IMPROVEMENT DISTRICT

WASTEWATER TREATMENT

CIVIL

RIB OVERALL SITE PLAN

AQUA ENGINEERING

DRAWING NO.

01C203

SHEET