
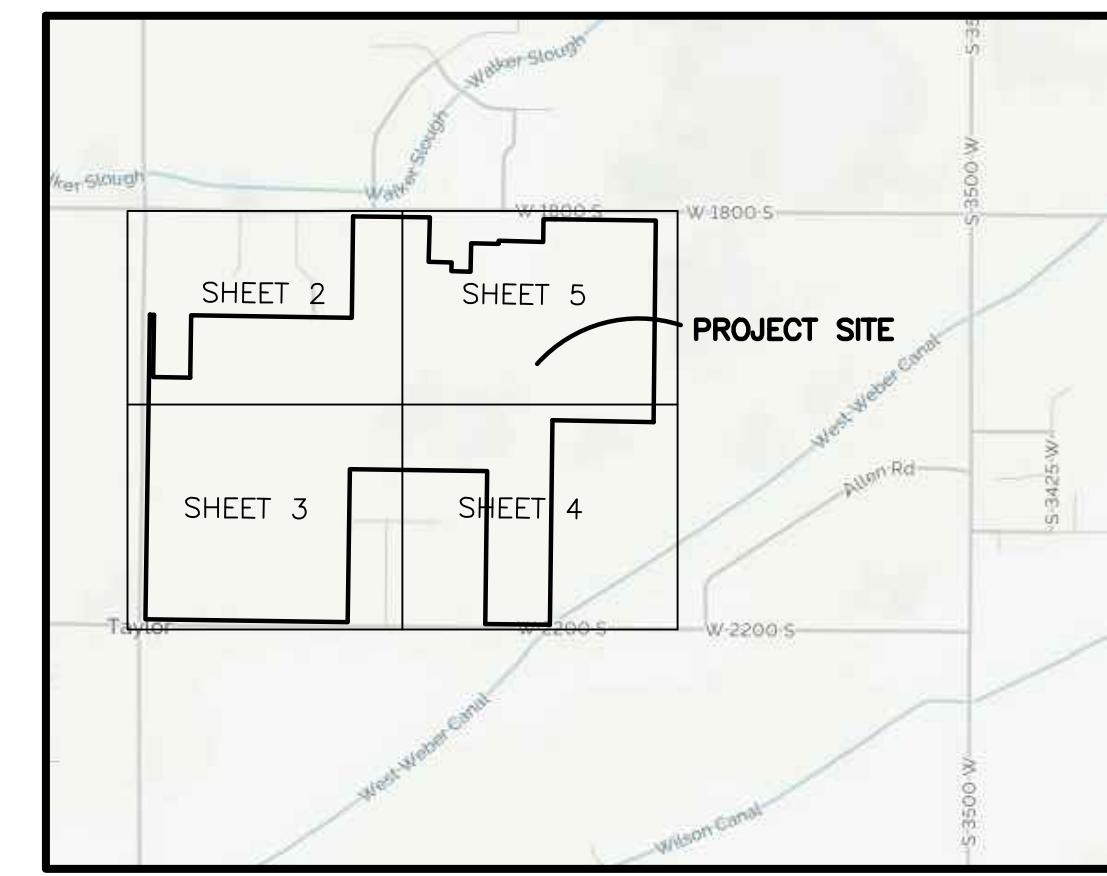


SUNSET EQUESTRIAN Cluster Subdivision

WEBER COUNTY, UTAH


Reeve & Associates, Inc. - Solutions You Can Build On

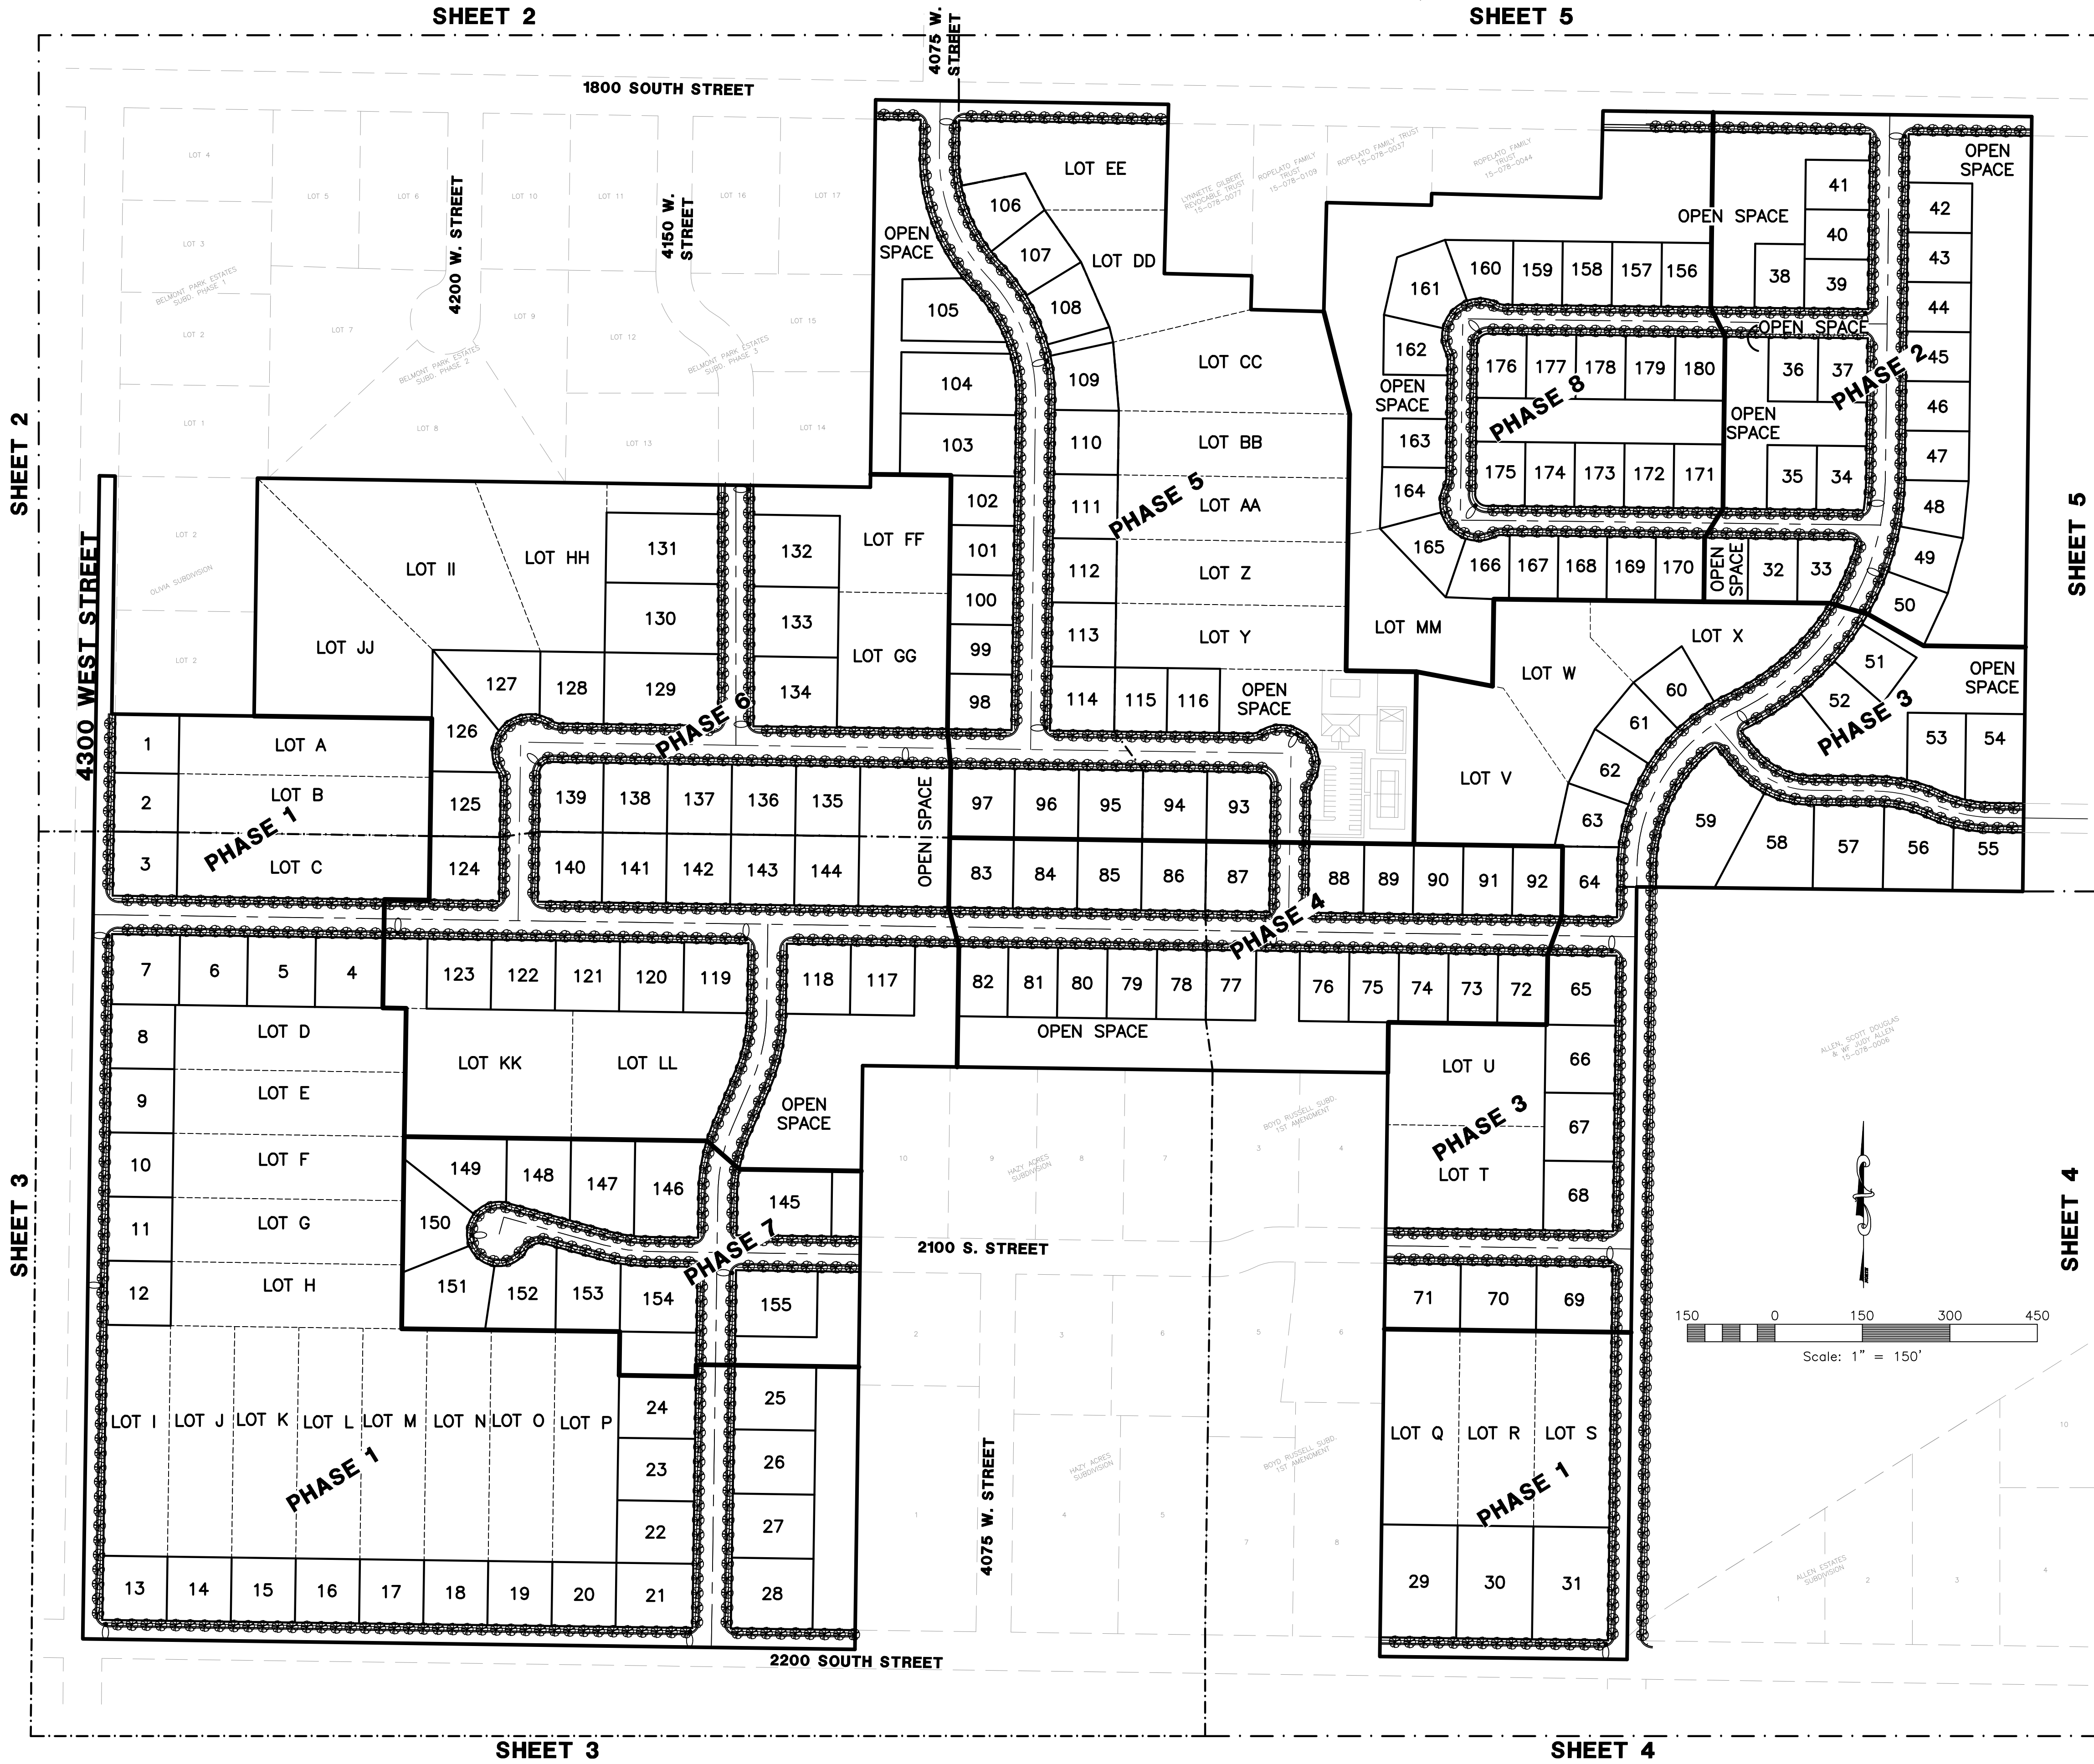


Street Tree Plant Table
Trees shall be planted 25' on center, per code.

Symbol	Tree Type (see specific species below)	Planting Size
	Deciduous Street Tree	2" cal.
	Acer trun. x plat. 'JFS-KW249'	Ruby Sunset Maple 2" cal.
	Cercis canadensis	Eastern Redbud 2" cal.
	Koeleruteria paniculata	Goldenrain Tree 2" cal.
	Malus 'Merilee'	Merilee Crabapple 2" cal.
	Malus 'Prairie Fire'	Prairie Fire Crabapple 2" cal.
	Malus 'Royal Raindrops'	Royal Raindrops Crabapple 2" cal.
	Malus 'Spring Snow'	Spring Snow Crabapple 2" cal.
	Pyrus 'Aristocrat'	Aristocrat Flowering Pear 2" cal.
	Pyrus 'Chanticleer'	Chanticleer Flowering Pear 2" cal.
	Syringa reticulata 'Ivory Silk'	Ivory Silk Tree Lilac 2" cal.


○ Street Light

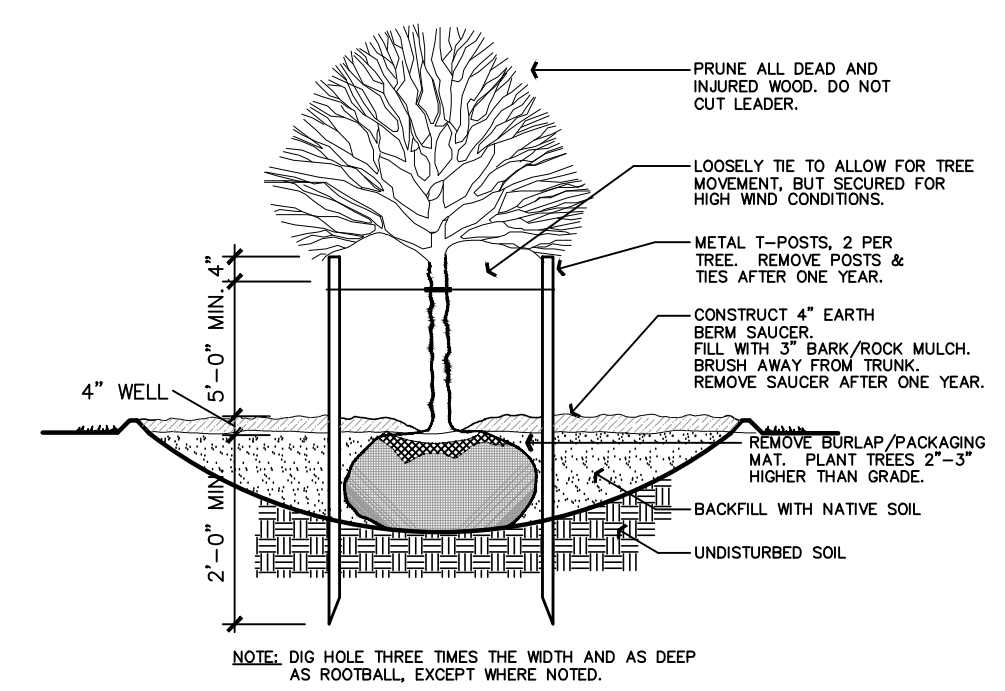

DECIDUOUS TREE PLANTING
SCALE: NOT TO SCALE

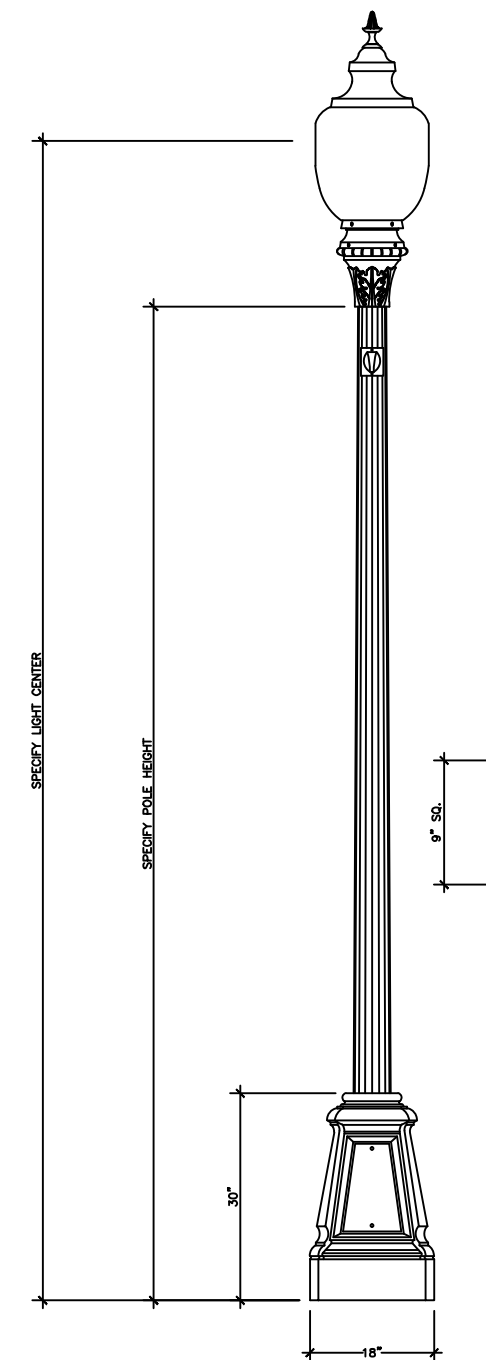

LAMP POST DETAIL
SCALE: NOT TO SCALE

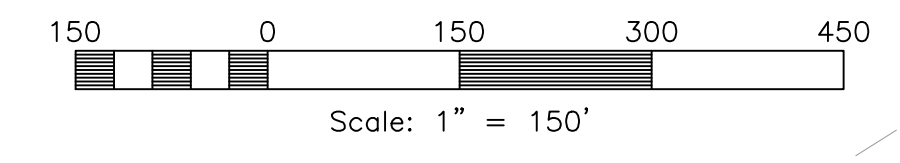

Reeve & Associates, Inc.
5160 SOUTH 1500 WEST RIVERDALE, UTAH 84405
TEL: (801) 921-3100 FAX: (801) 621-2666 WWW.REEVE-ASSOCIATES.COM
LAND PLANNERS • CIVIL ENGINEERS • LAND SURVEYORS
TRAFFIC ENGINEERS • STRUCTURAL ENGINEERS • LANDSCAPE ARCHITECTS

REVISIONS	DATE	DESCRIPTION
	08-23-17	ER City Revisions

Sunset Equestrian Cluster Subdivision
WEBER COUNTY, UTAH

Tree & Street Light Plan


REGISTERED PROFESSIONAL ENGINEER
375328
J. NATE REEVE
STATE OF UTAH

Project Info.
Engineer: N. REEVE
 Drafter: E. ROCHE
 Begin Date: 6-15-17
 Name: SUNSET EQUESTRIAN CLUSTER SUBDIVISION
 Number: 5336-05

Sheet **5**
1 Sheets

REVISIONS	DATE	DESCRIPTION
	08-23-17	ER City Revisions




Sunset Equestrian Cluster Subdivision
 WEBER COUNTY, UTAH
Tree & Street Light Plan

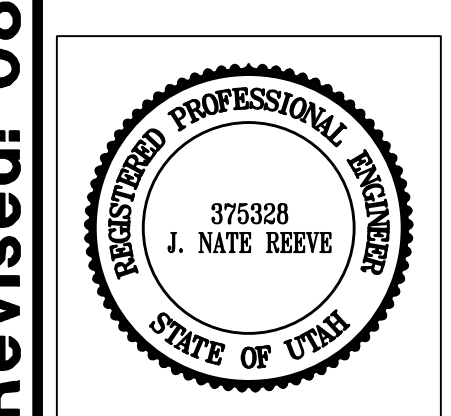

Project Info.

Engineer: N. REEVE
 Drafter: E. ROCHE
 Begin Date: 6-15-17
 Name: SUNSET EQUESTRIAN CLUSTER SUBDIVISION
 Number: 5336-05

Sheet	5
2	Sheets

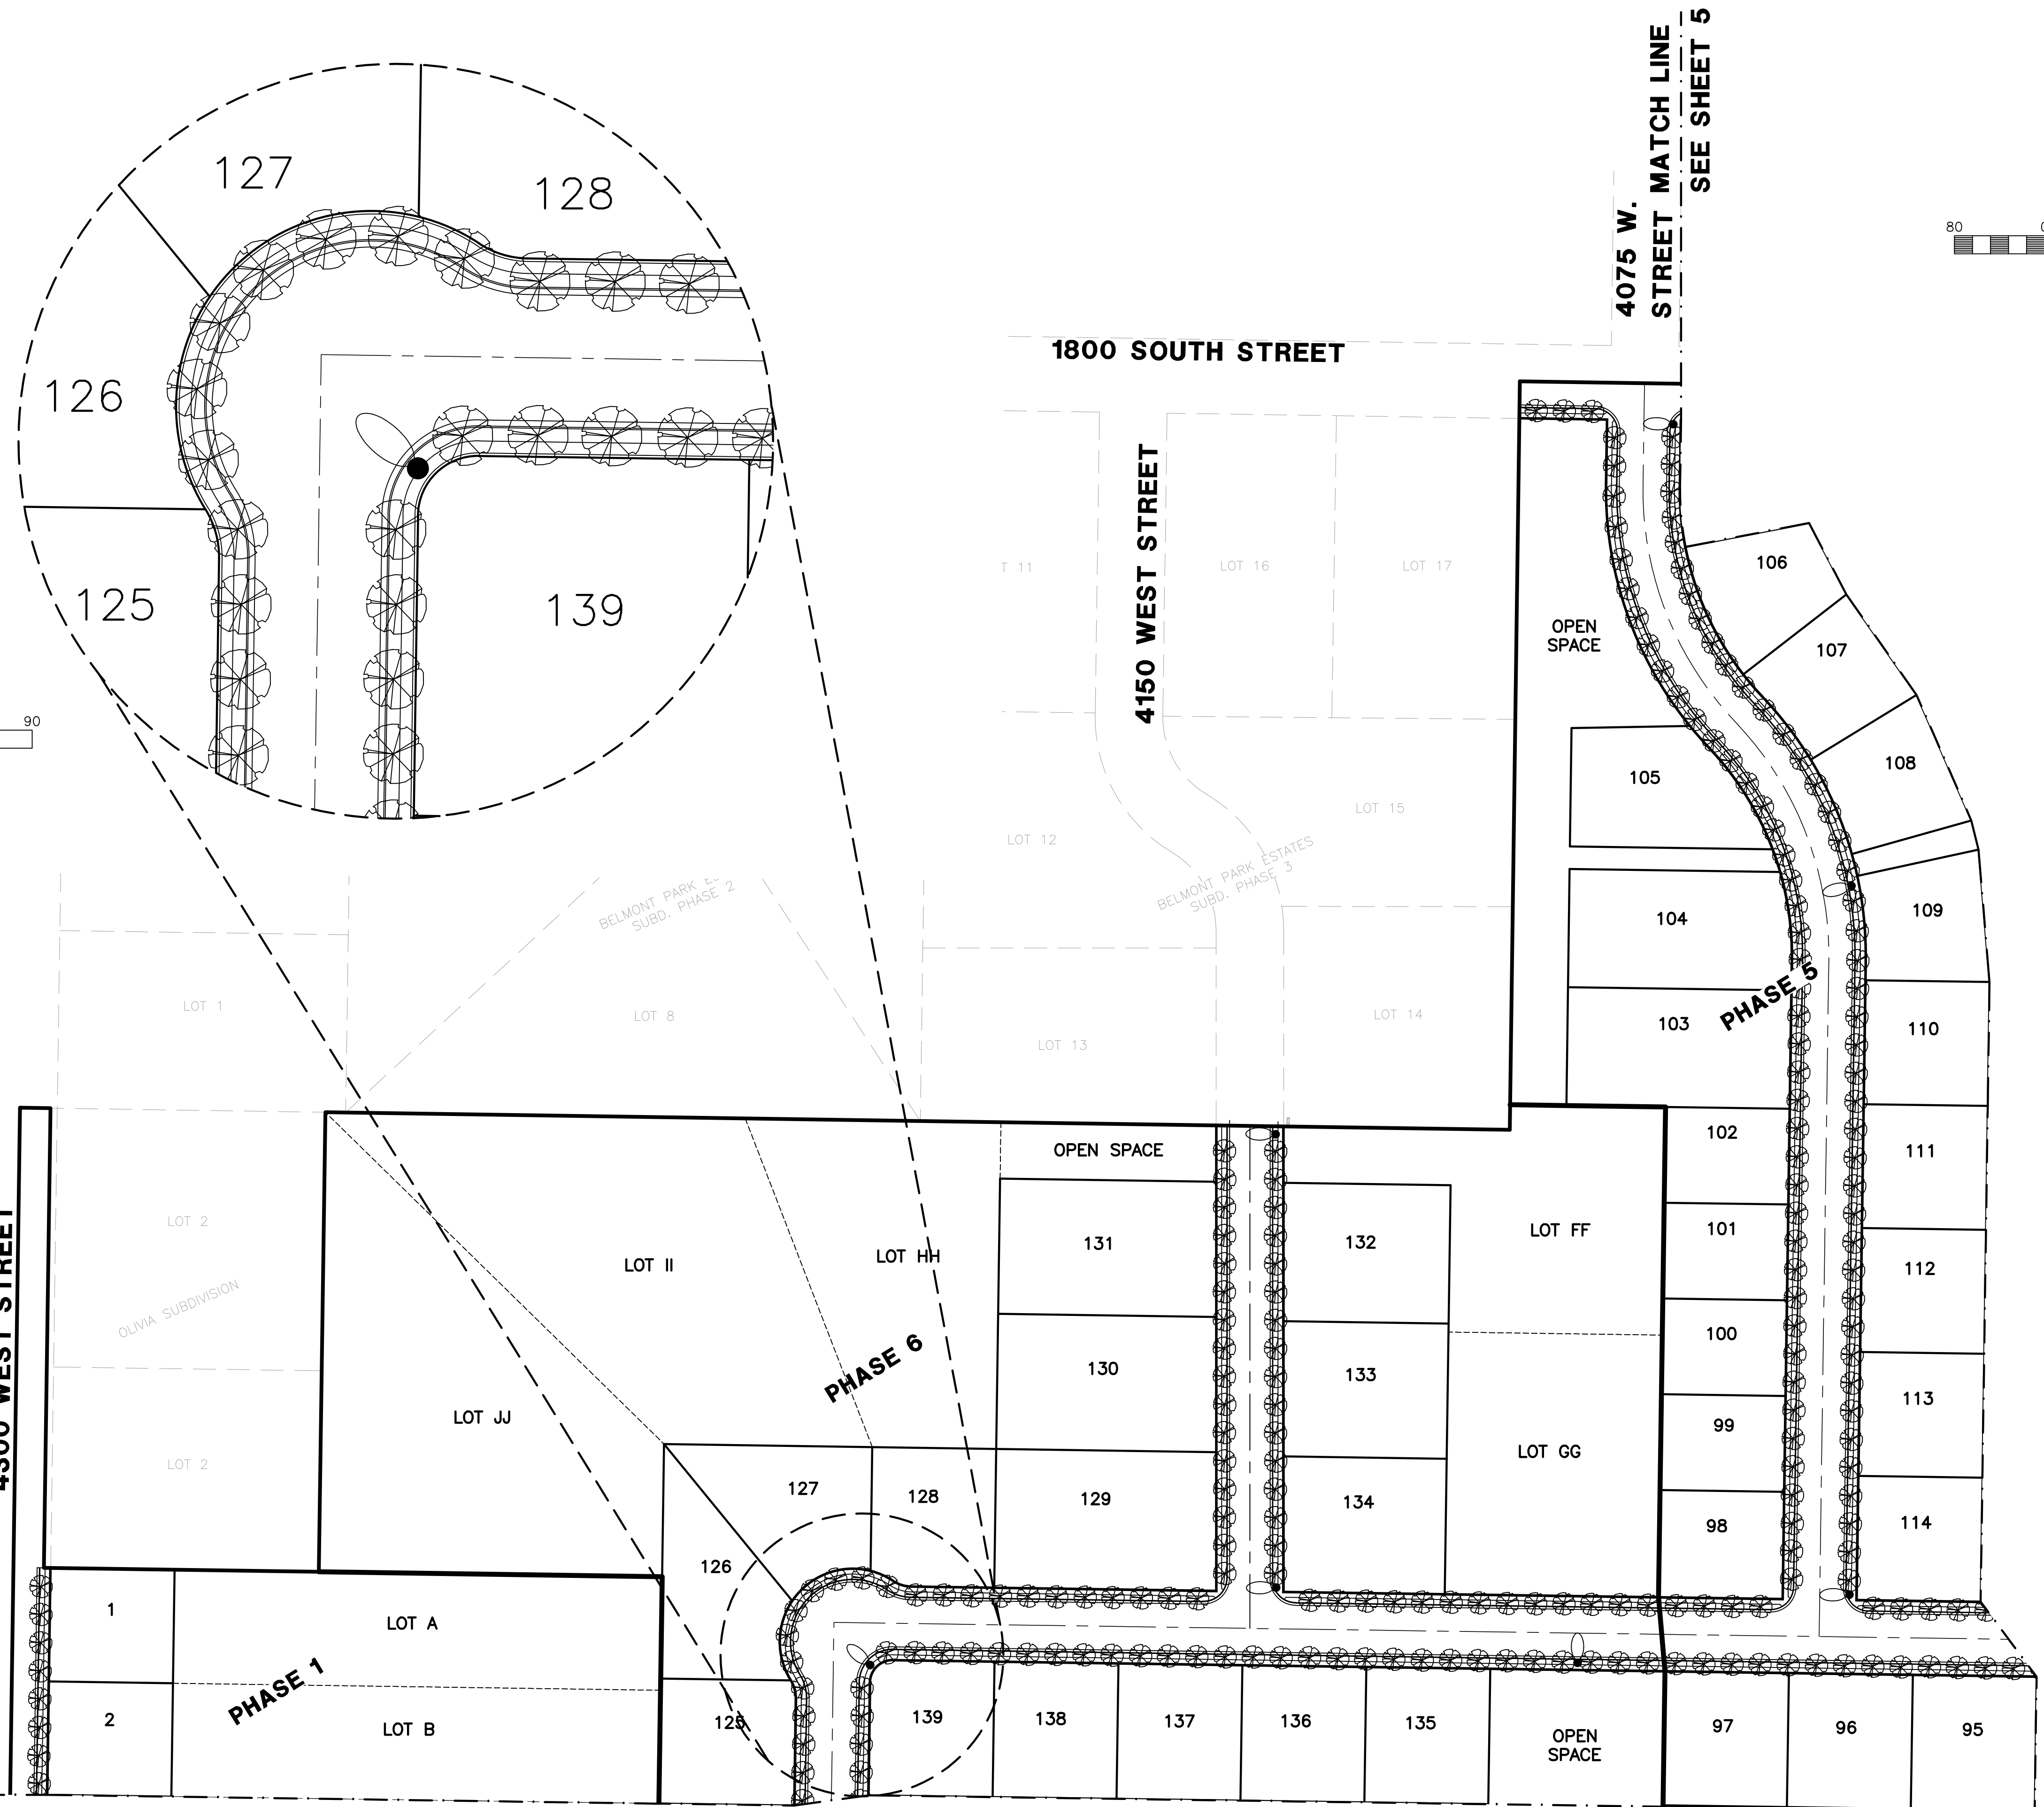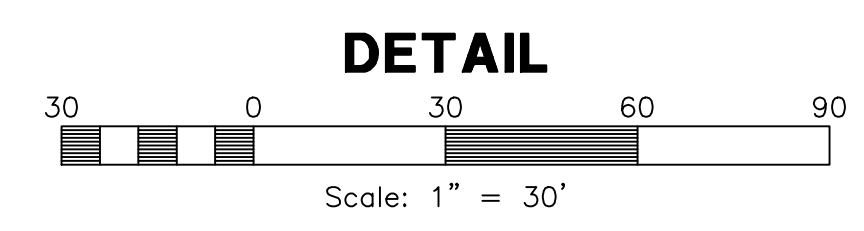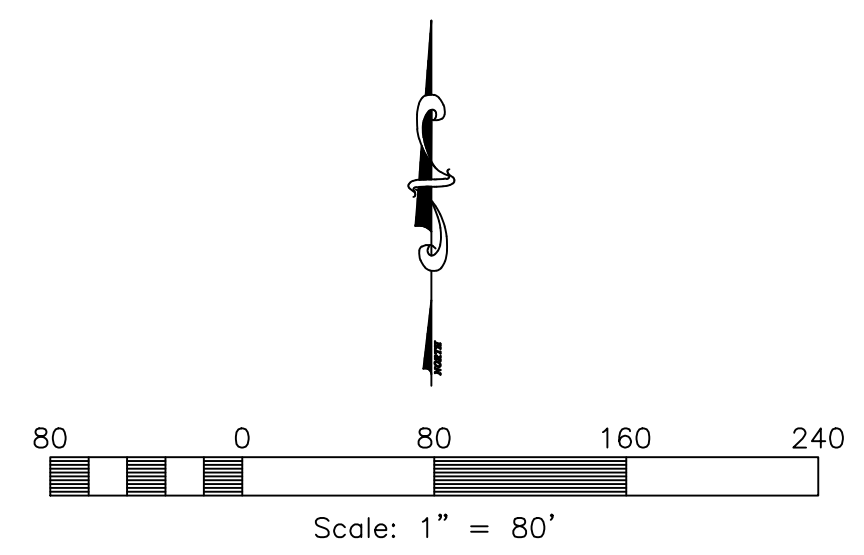

MATCH LINE
SEE SHEET 3

MATCH LINE
SEE SHEET 3

MATCH LINE
SEE SHEET 5


4075 W. STREET MATCH LINE
SEE SHEET 5

1/4/2016 | E. Roche | G:\3336\05\Landscape\Street Tree_Lighting Plan2.dwg


MATCH LINE
SEE SHEET 2

MATCH LINE
SEE SHEET 4

MATCH LINE
SEE SHEET 2

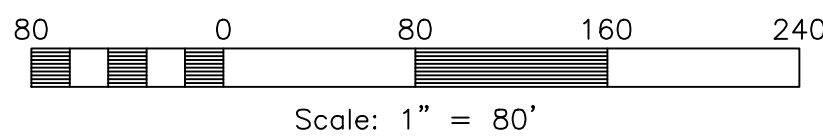

4300 WEST STREET

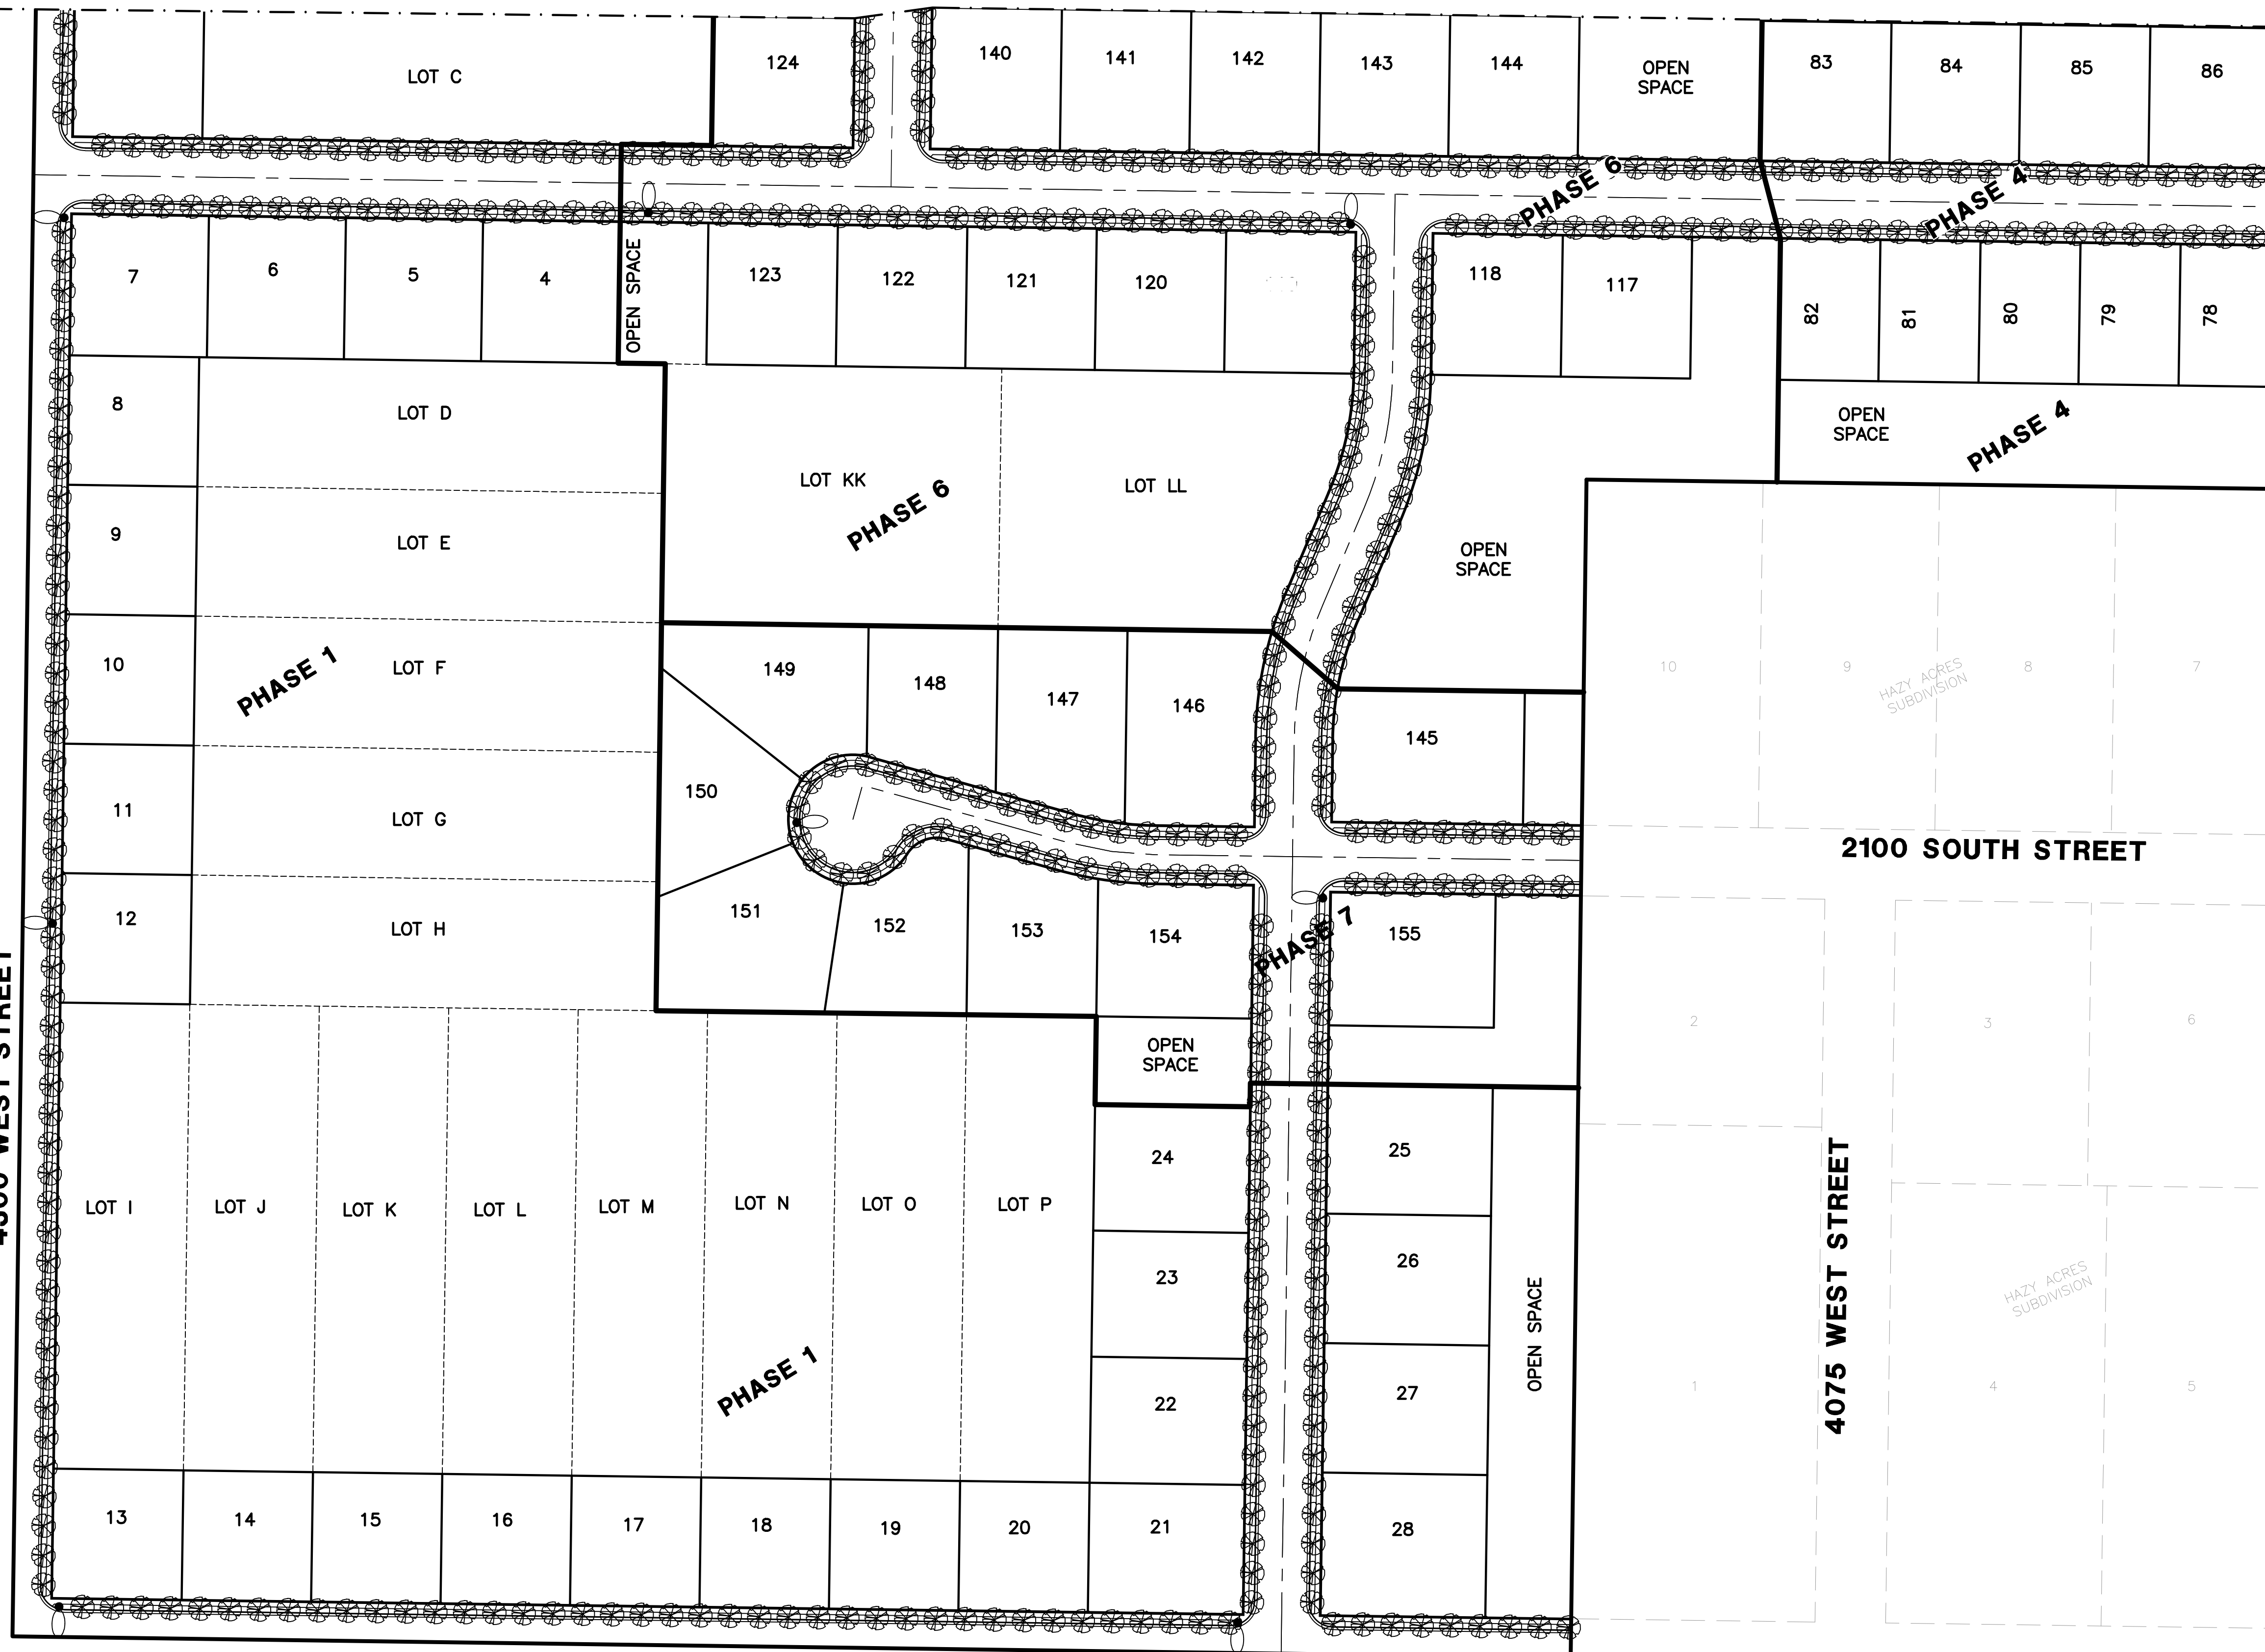

4300 WEST STREET

4075 WEST STREET

2100 SOUTH STREET


MATCH LINE
SEE SHEET 4

Reeve & Associates, Inc.
 5160 SOUTH 1500 WEST RIVERDALE, UTAH 84405
 TEL: (801) 821-3100 FAX: (801) 821-2666 www.reeve-assoc.com
 LAND PLANNERS • CIVIL ENGINEERS • LAND SURVEYORS
 TRAFFIC ENGINEERS • STRUCTURAL ENGINEERS • LANDSCAPE ARCHITECTS

REVISIONS	DATE	DESCRIPTION
	08-23-17	FR City Revisions

Sunset Equestrian Cluster Subdivision
 WEBER COUNTY, UTAH

Tree & Street Light Plan

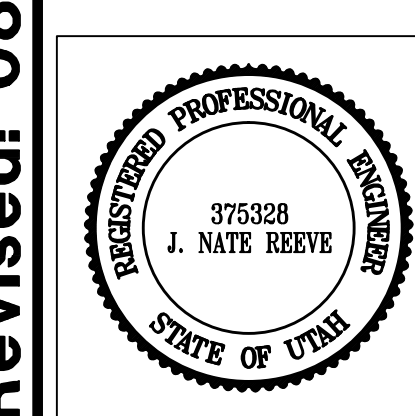

Project Info.

Engineer:	N. REEVE
Drafter:	E. ROCHE
Begin Date:	6-15-17
Name:	SUNSET EQUESTRIAN CLUSTER SUBDIVISION
Number:	5336-05


Revised: 08-23-17

MATCH LINE
SEE SHEET 5


MATCH LINE
SEE SHEET 3

MATCH LINE
SEE SHEET 5

MATCH LINE
SEE SHEET 3

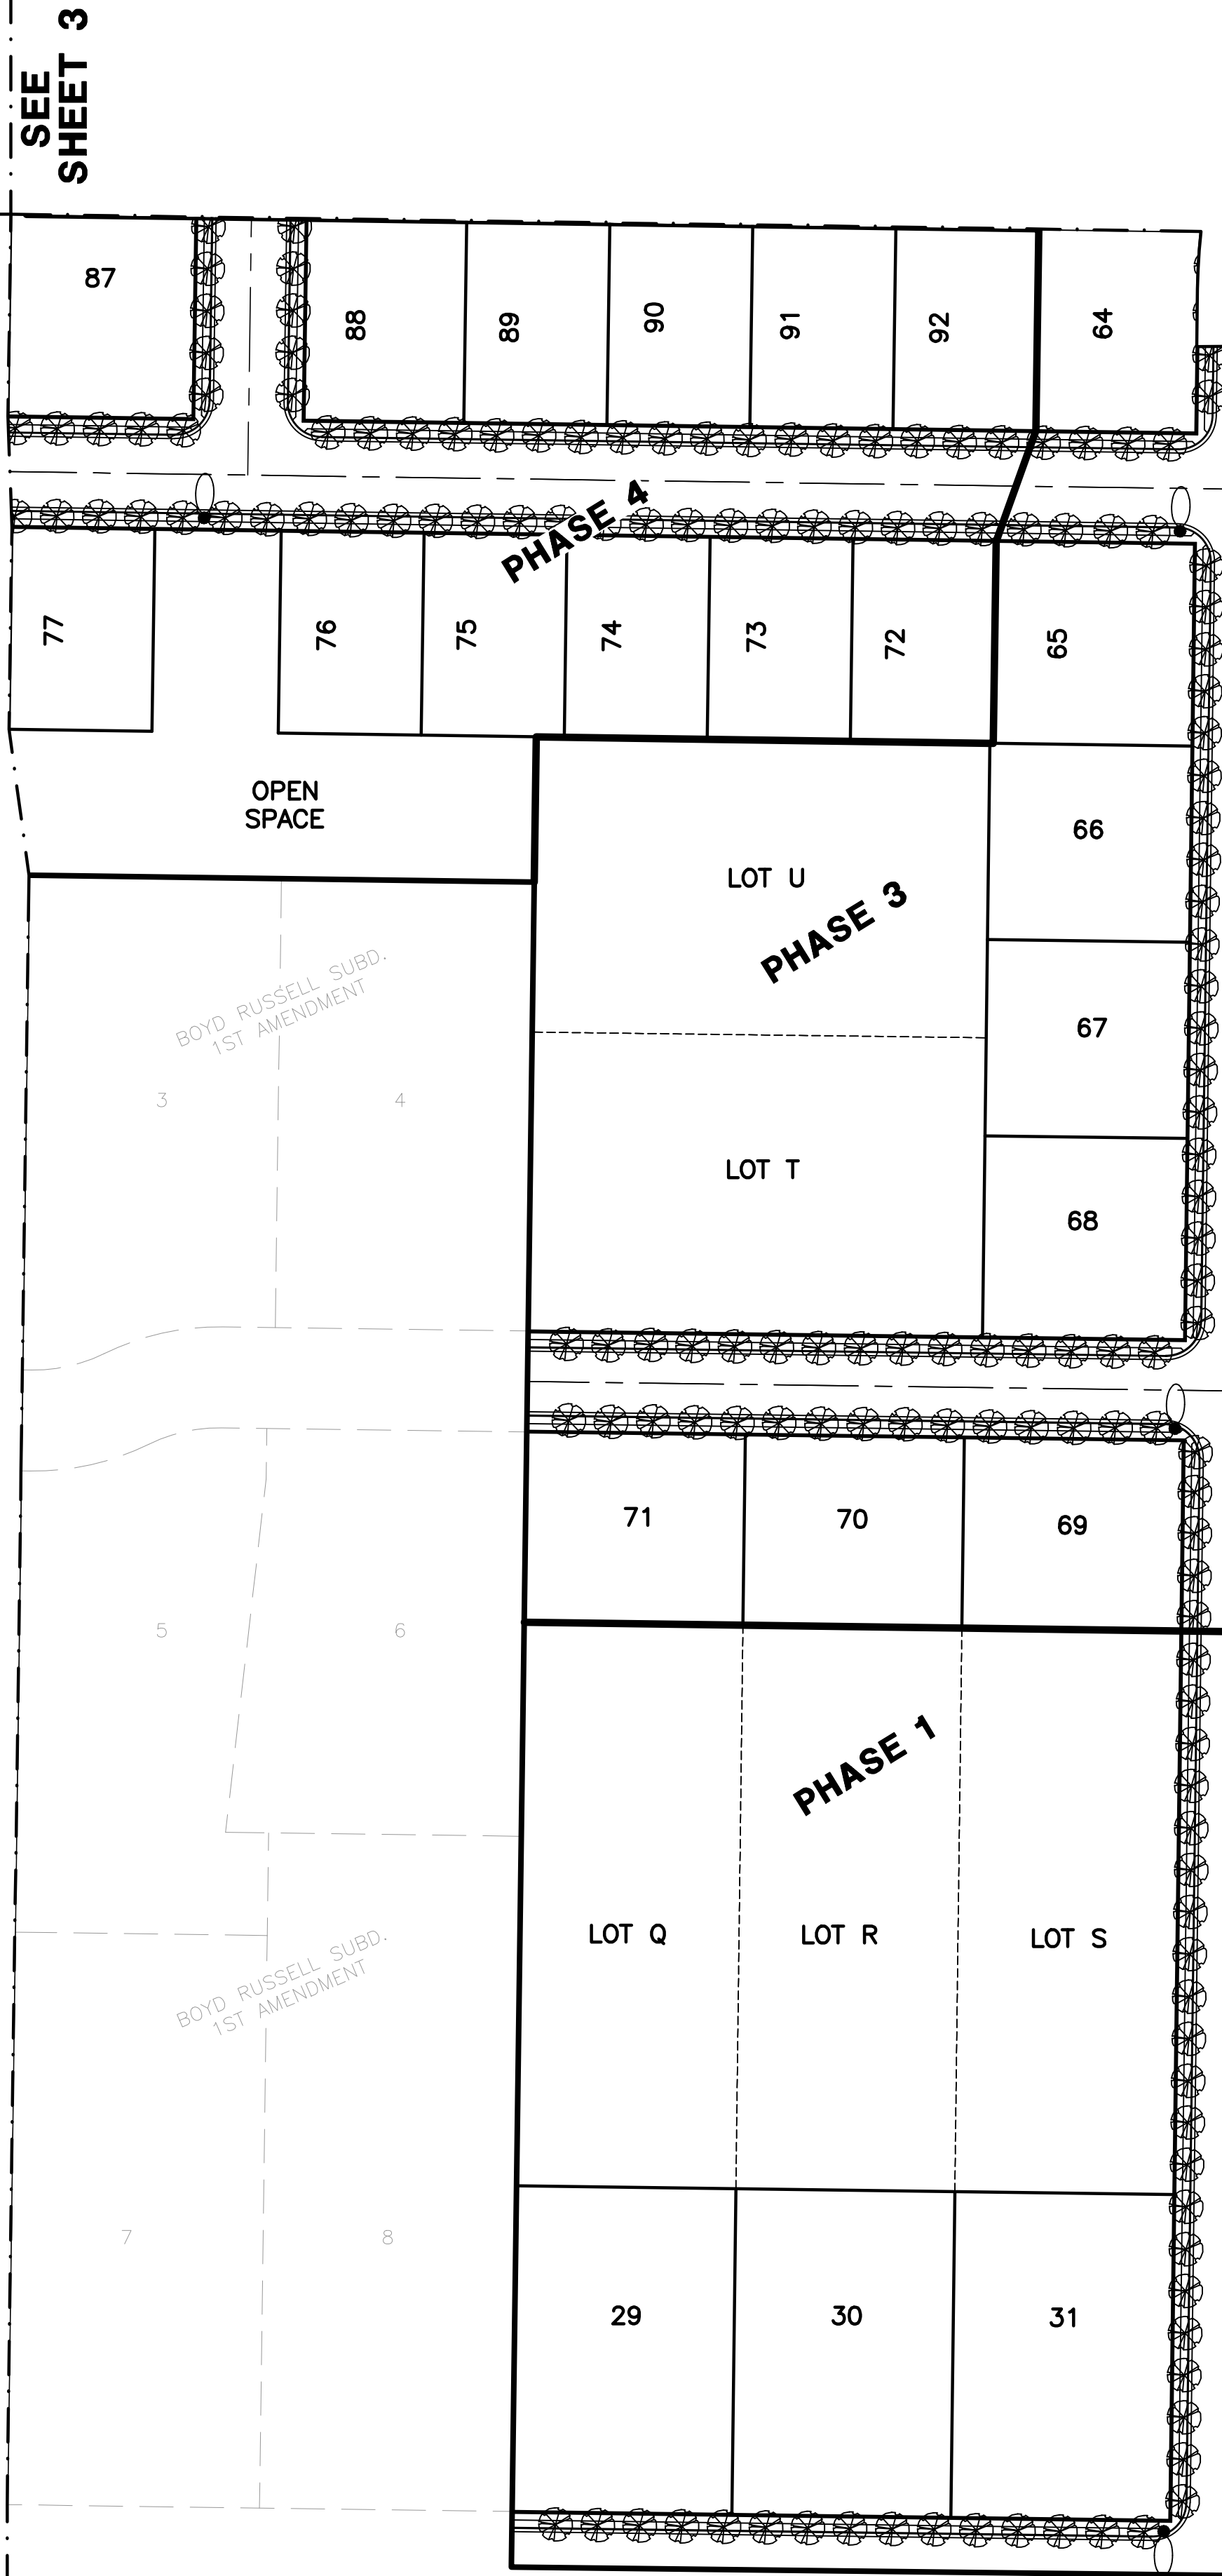

ALLEN, SCOTT DOU
& WIFE JUDY AL
15-078-007

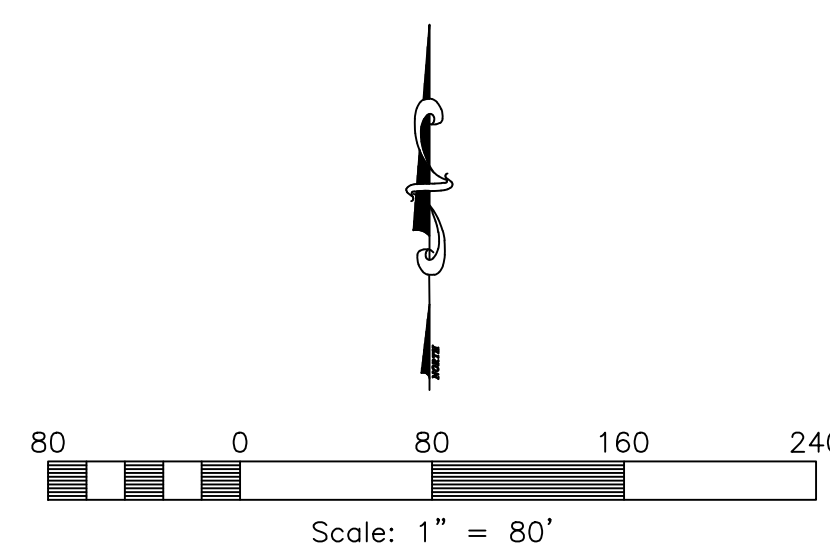


Reeve & Associates, Inc.
 5160 SOUTH 1500 WEST RIVERDALE, UTAH 84405
 TEL: (801) 821-3100 FAX: (801) 821-2666 www.reeve-assoc.com
 LAND PLANNERS • CIVIL ENGINEERS • LAND SURVEYORS
 TRAFFIC ENGINEERS • STRUCTURAL ENGINEERS • LANDSCAPE ARCHITECTS

REVISIONS	DESCRIPTION
DATE	DESCRIPTION
08-23-17	ER City Revisions


Sunset Equestrian Cluster Subdivision
 WEBER COUNTY, UTAH

Tree & Street Light Plan

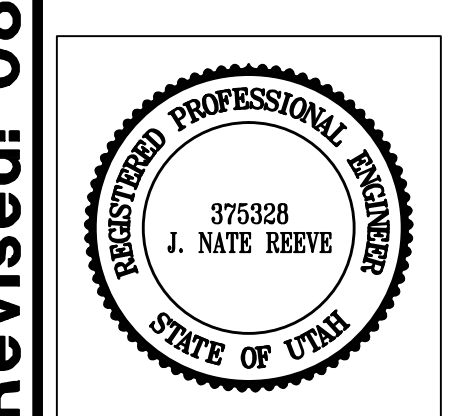

Project Info.


Engineer:	N. REEVE
Drafter:	E. ROCHE
Begin Date:	6-15-17
Name:	SUNSET EQUESTRIAN CLUSTER SUBDIVISION
Number:	5336-05

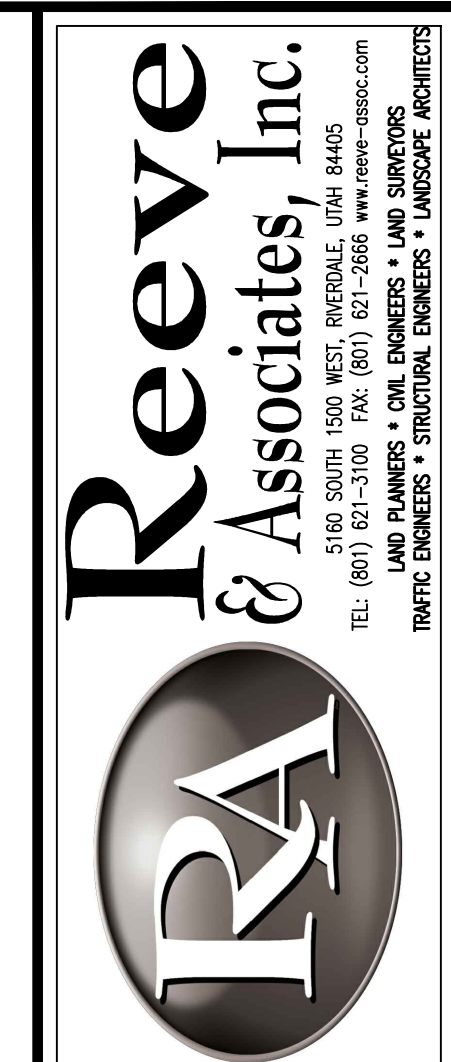

REVISIONS	DATE	DESCRIPTION
	08-23-17	FR City Revisions

Sunset Equestrian Cluster Subdivision
WEBER COUNTY, UTAH



Tree & Street Light Plan

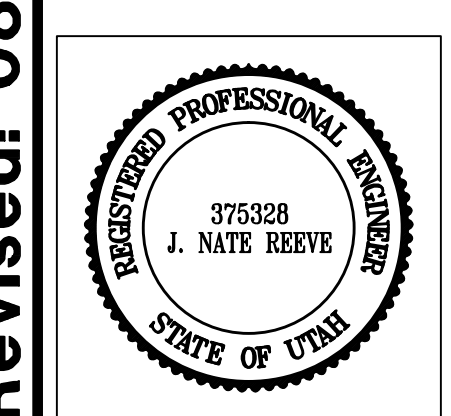

Project Info.

Engineer: N. REEVE
 Drafter: E. ROCHE
 Begin Date: 6-15-17
 Name: SUNSET EQUESTRIAN CLUSTER SUBDIVISION
 Number: 5336-05

MATCH LINE
SEE SHEET 2

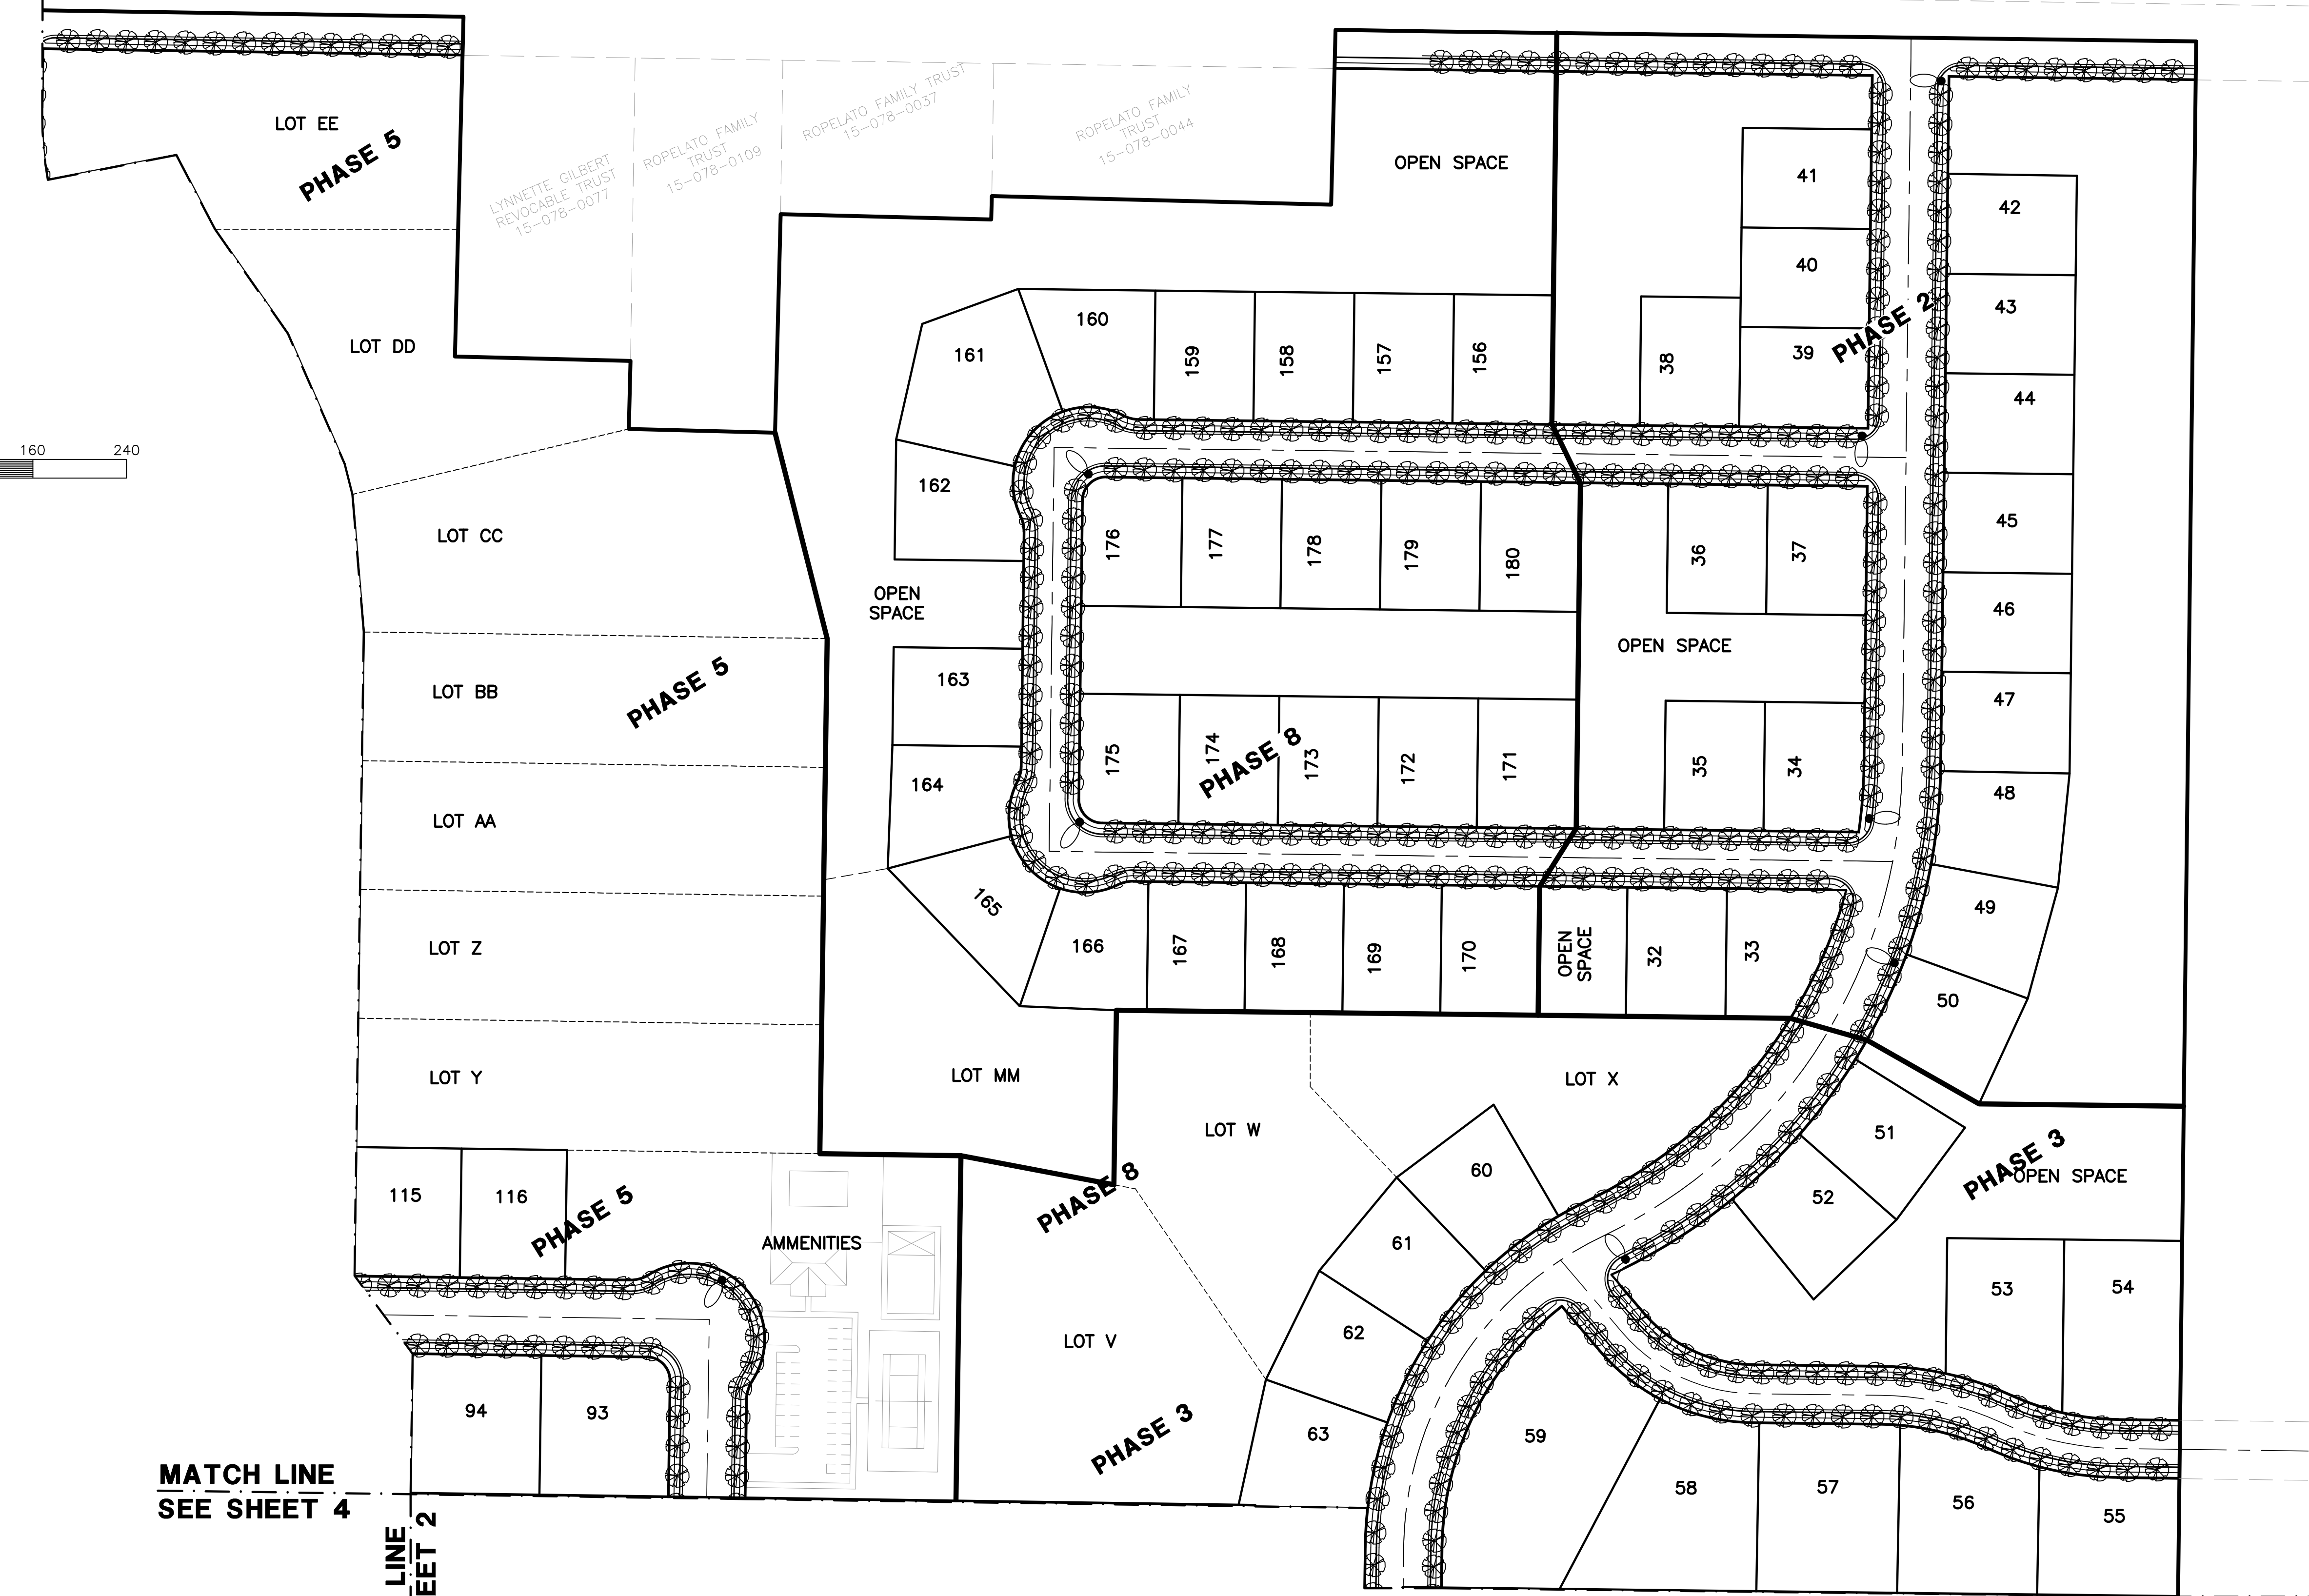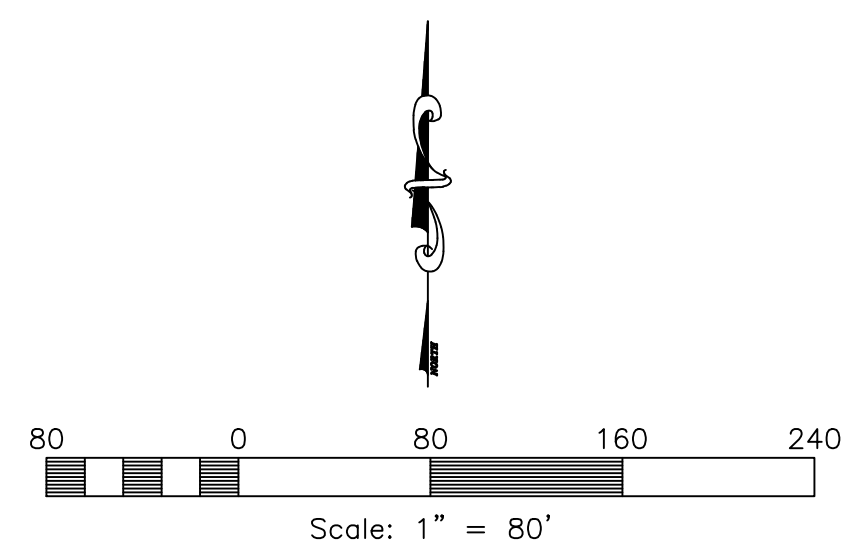

MATCH LINE
SEE SHEET 4

MATCH LINE
SEE SHEET 2

MATCH LINE
SEE SHEET 4