



UPPER MEZZ MECHANICAL PLAN
SCALE: 1/8" = 1'-0"

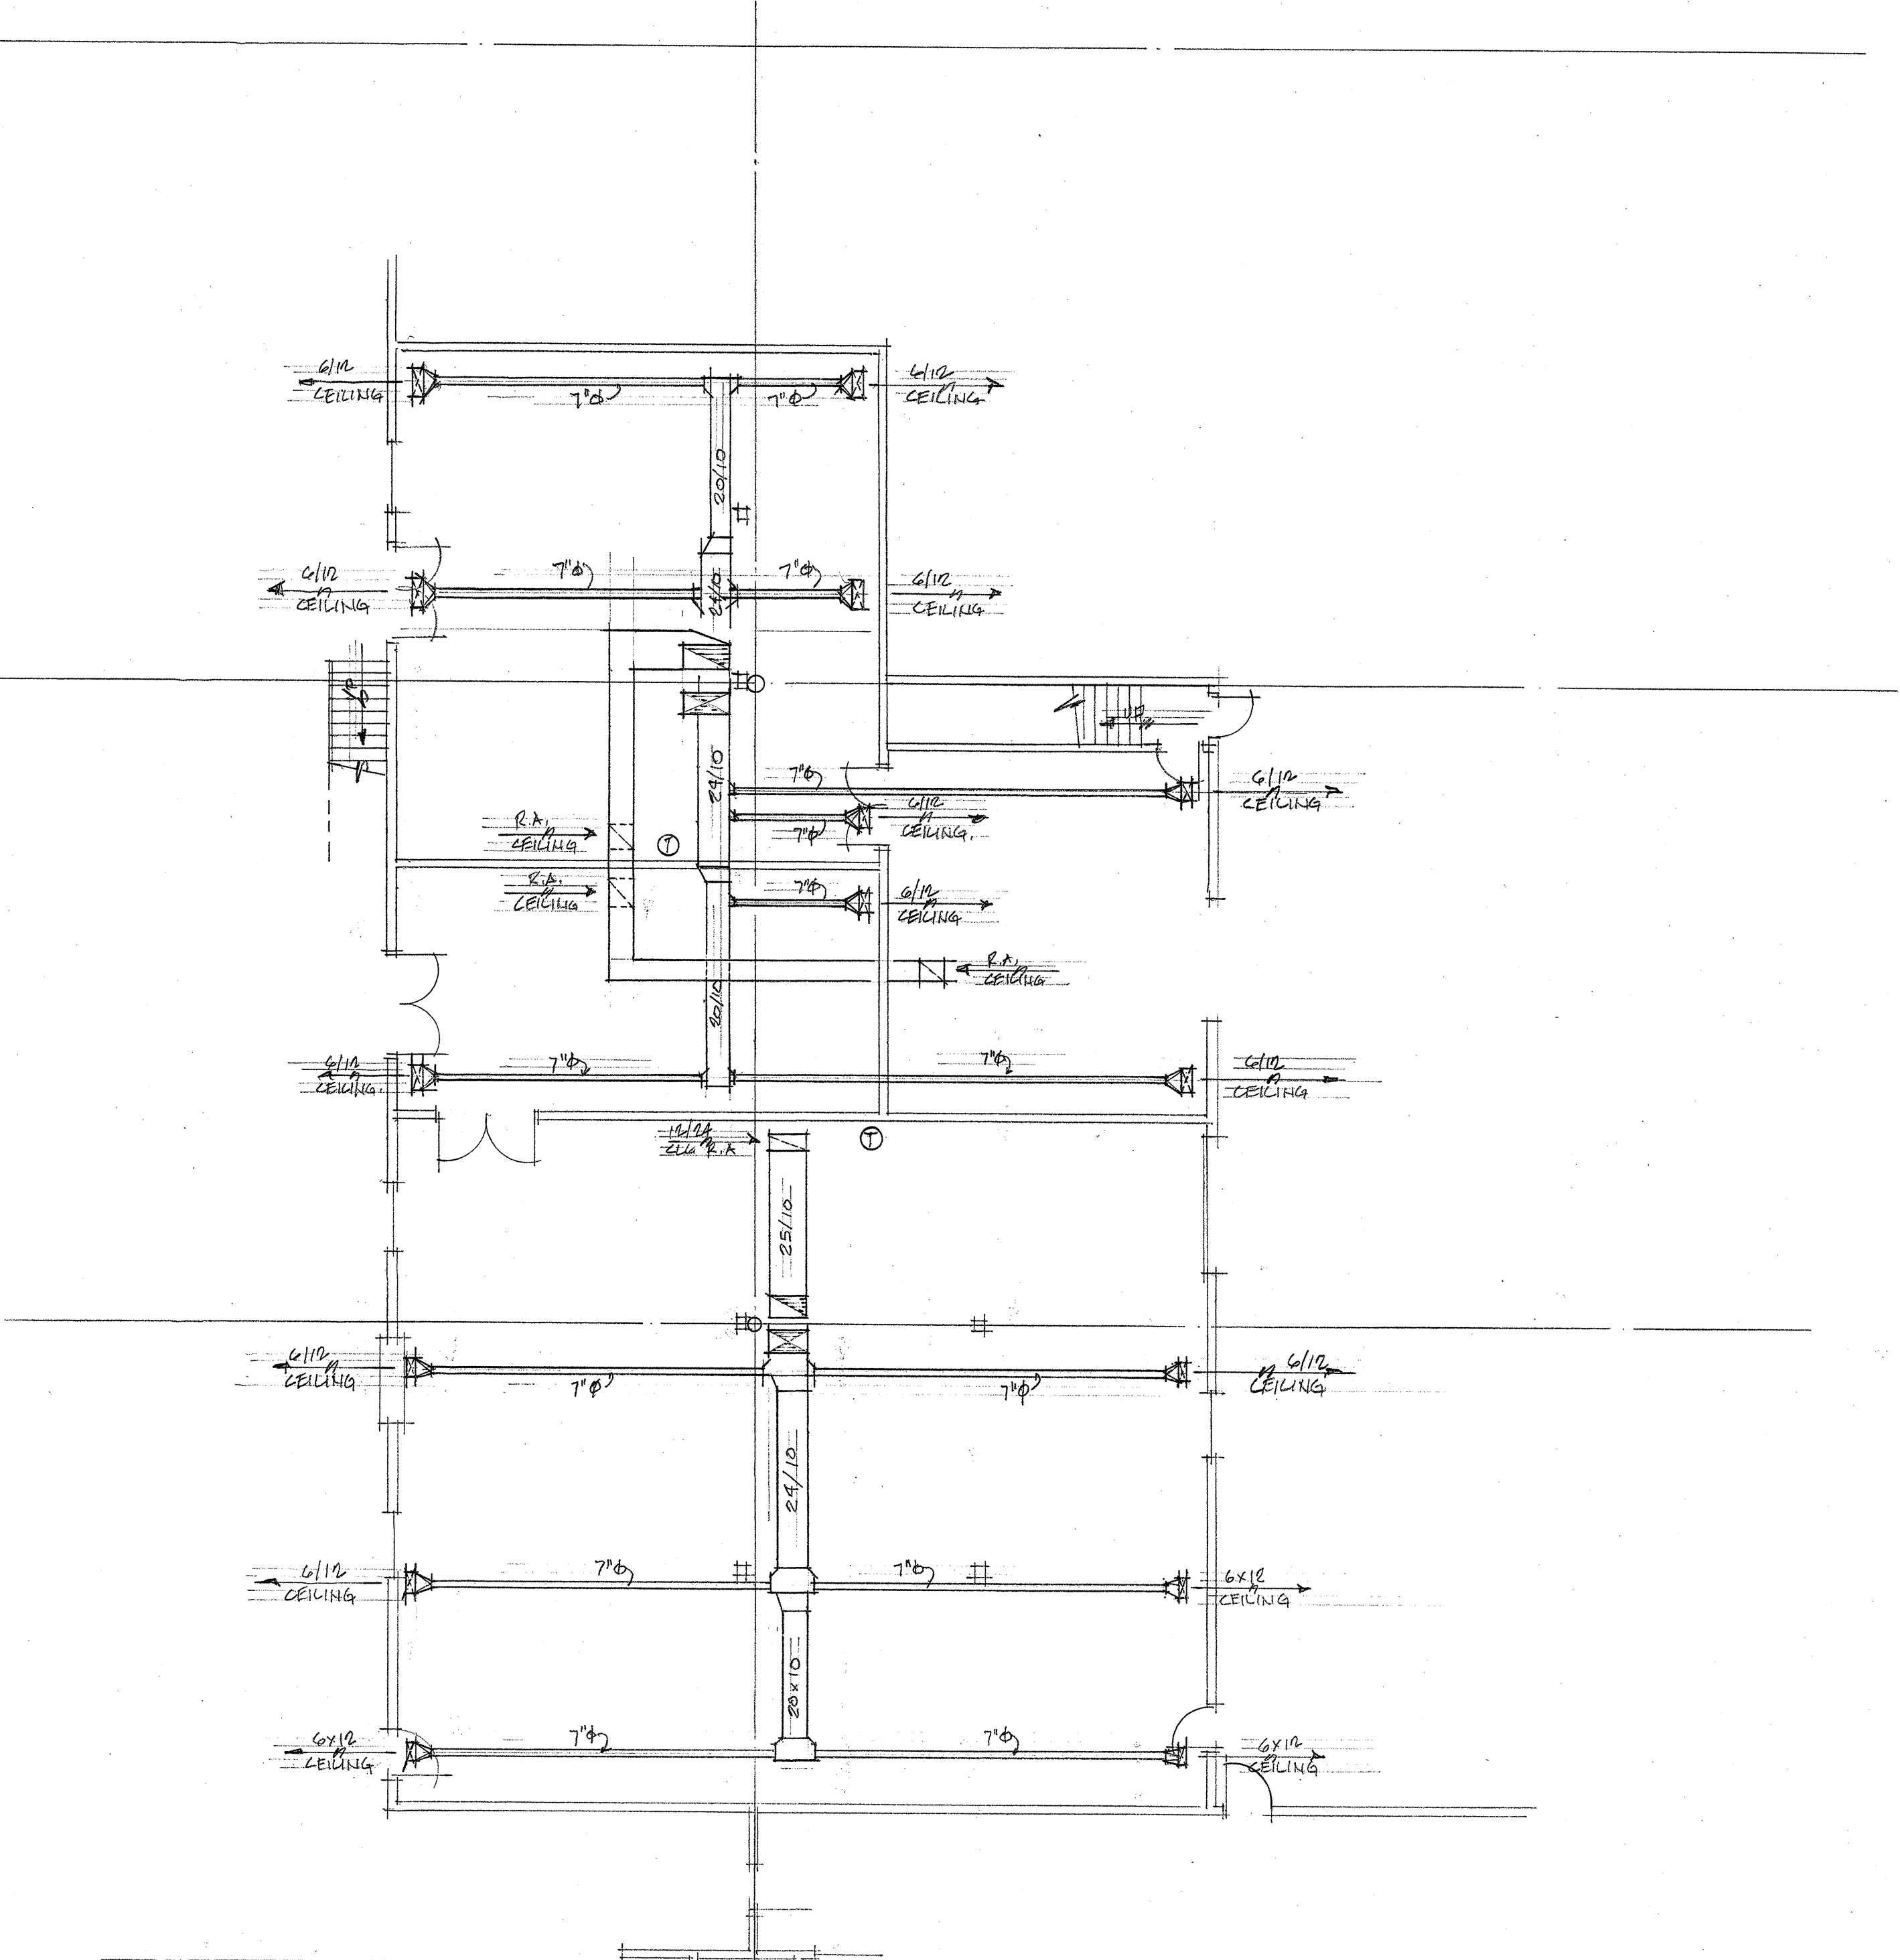

MAIN FLOOR MECHANICAL PLAN
SCALE: 1/8" = 1'-0"

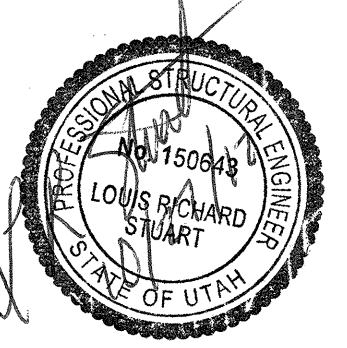

| | |
|---|------------------|
| MECHANICAL LAYOUT | |
| SPARTAN MECHANICAL 801-698-9511 | P.C.B. SOLUTIONS |
| CONTRACTOR LEON ROBINSON CONSTRUCTION PHNO 801-430-4044 | DATE: 10-06-2012 |