



COORDINATE POWER TO EQUIPMENT W/ EQUIPMENT SUPPLIER.

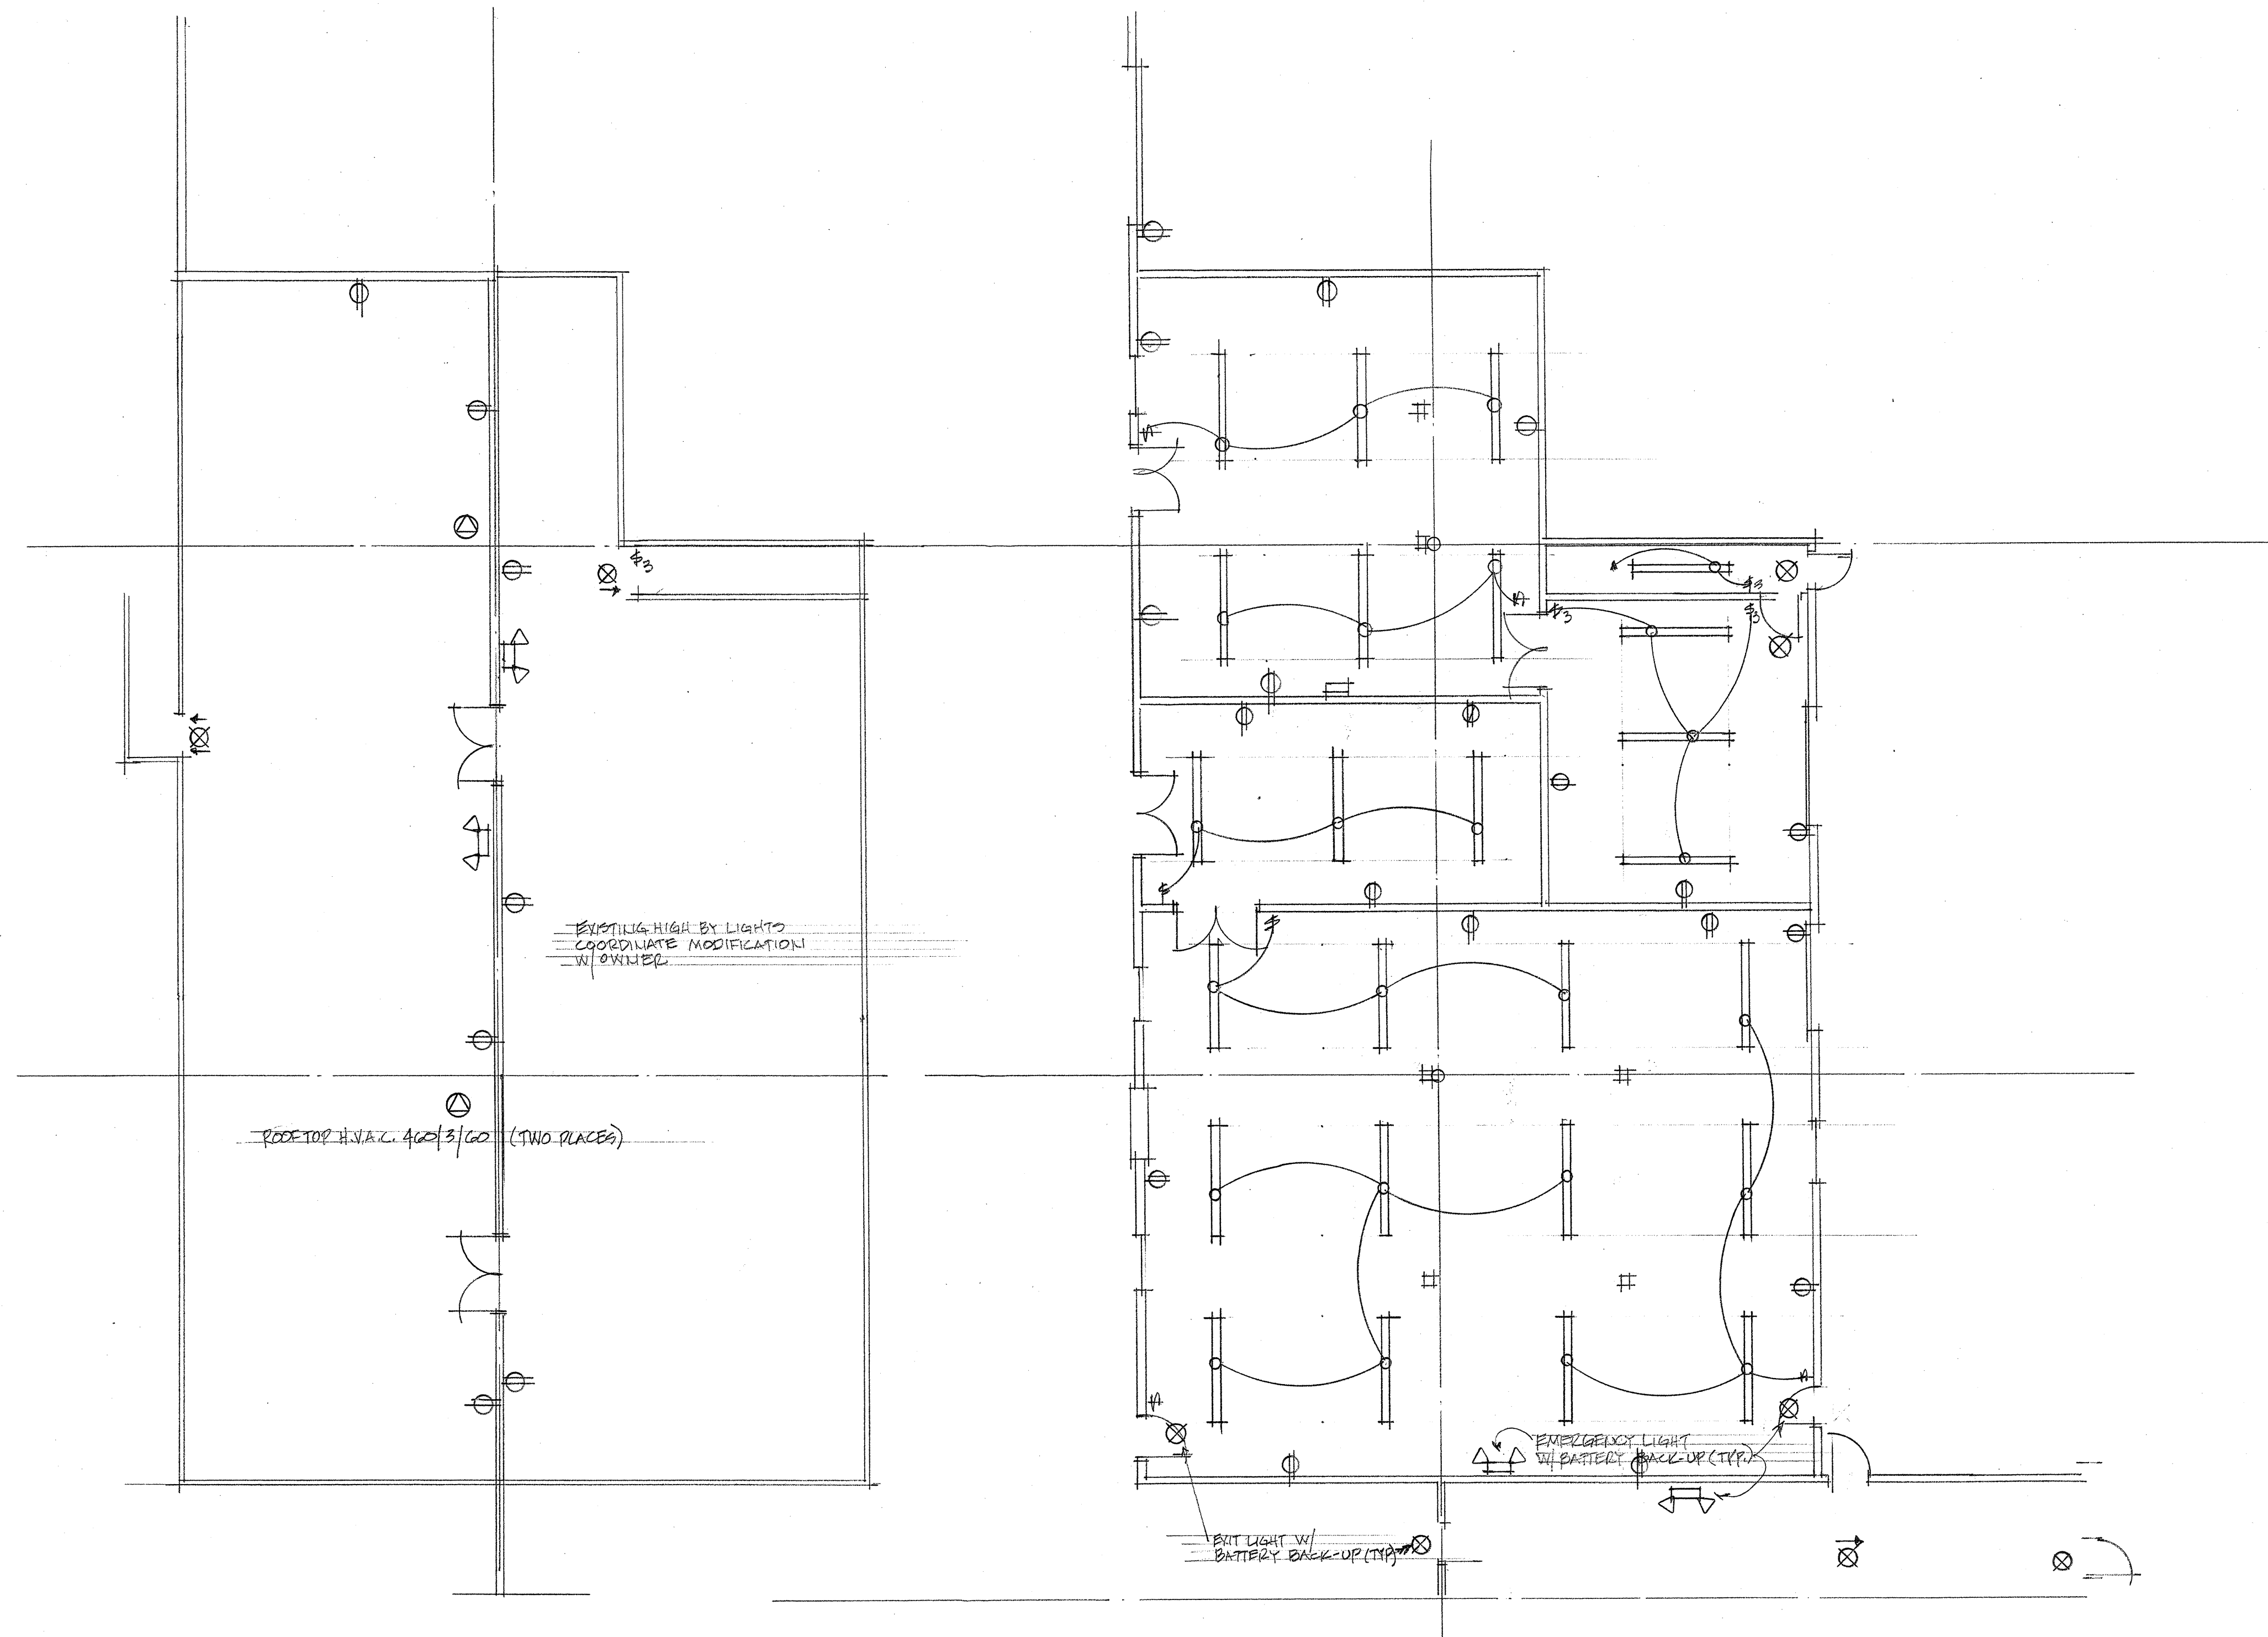

UPPER MEZ. ELECTRICAL PLAN  
SCALE: 1/8" = 1'-0"

MAIN FLOOR ELECTRICAL PLAN  
SCALE: 1/8" = 1'-0"

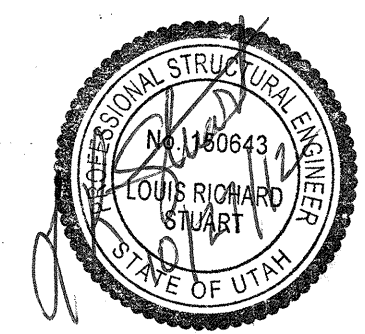

ELECTRICAL PLANS	
P.C.B. SOLUTIONS	
CONTRACTOR: LEON ROBERTSON CONSTRUCTION PHONE: 430-4044	10-26-12