
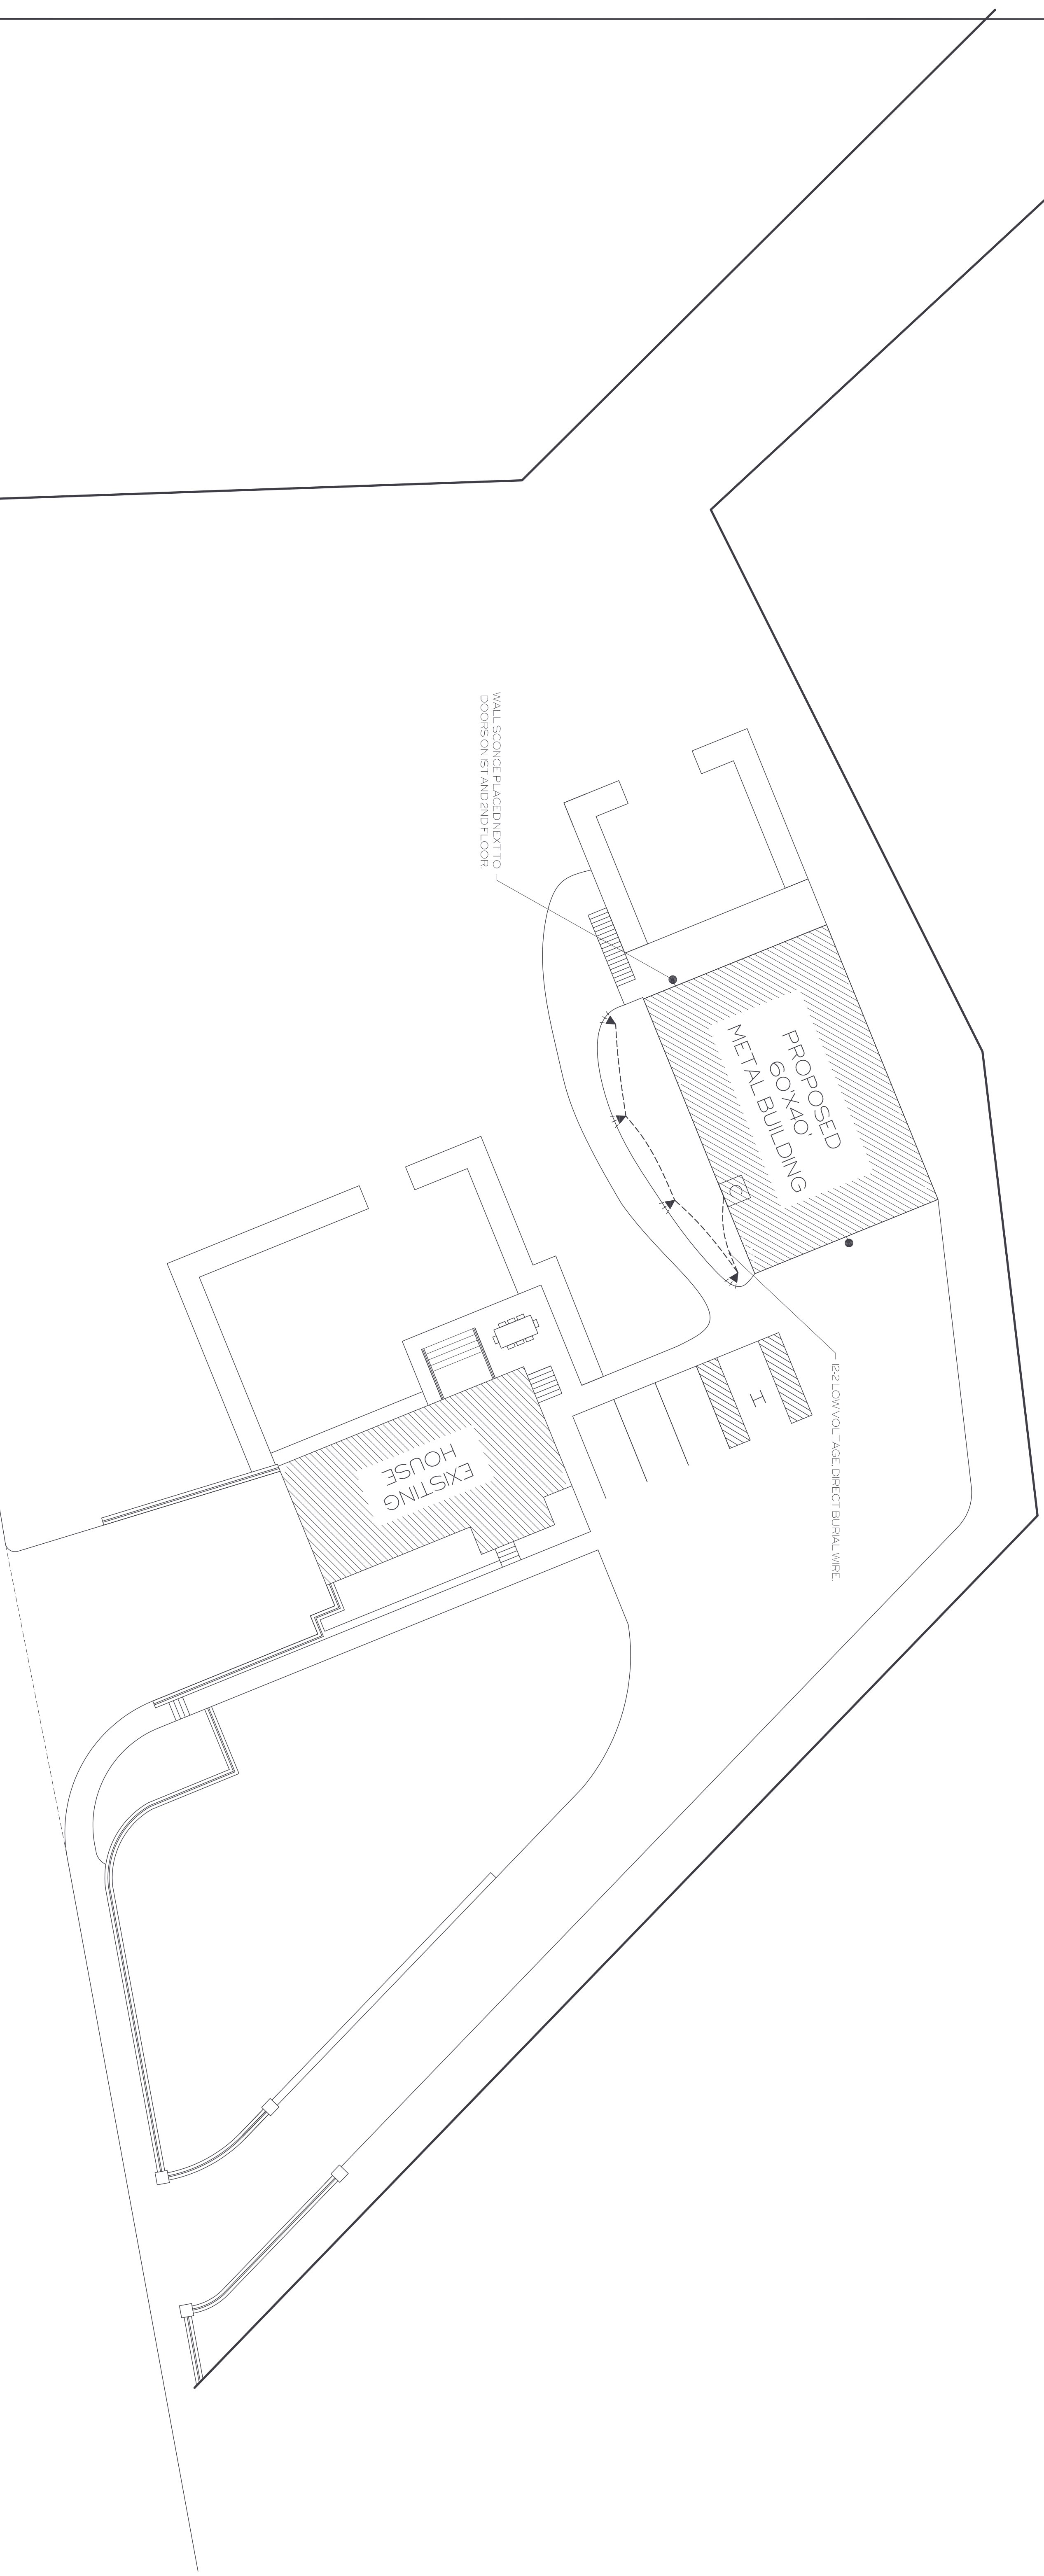
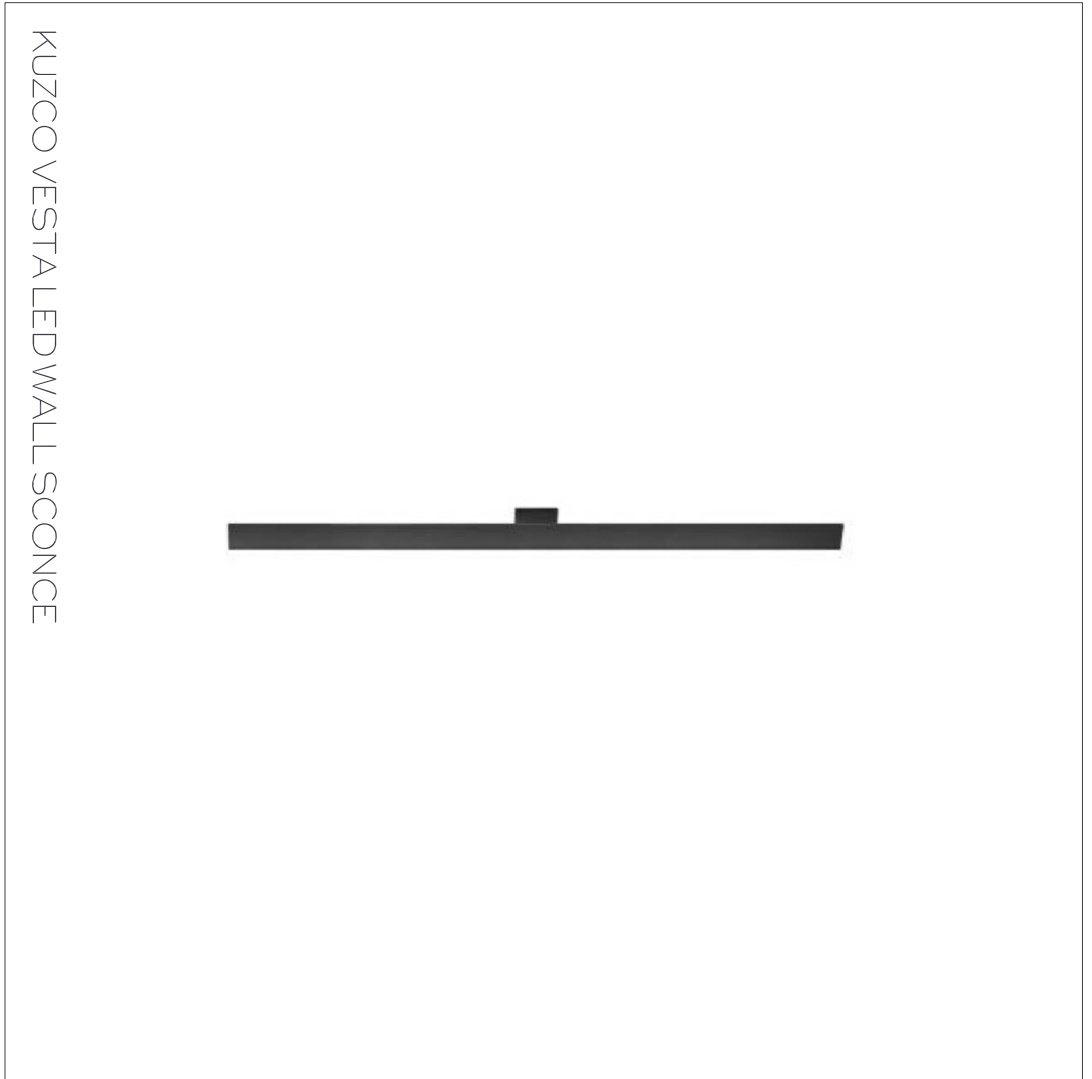


LIGHTING SPECS									
NAME	MODEL #	MANUFACTURER	WATTAGE	LUMENS	COLOR TEMP.	VOLTAGE	FINISH	SYMBOL	
FOREVER BRIGHT PATH LIGHT	SPJDS24	SPJ	2W	125	2700K	12V	BLACK	●	●
VESTA LED WALL SCONCE	AT7972	KUZCO	23W	1800	3000K	120V	BLACK	▲	▲
TRANSFORMER	E3SERIES	VISTA	150W (ALLOWED)				STAINLESS	□	□

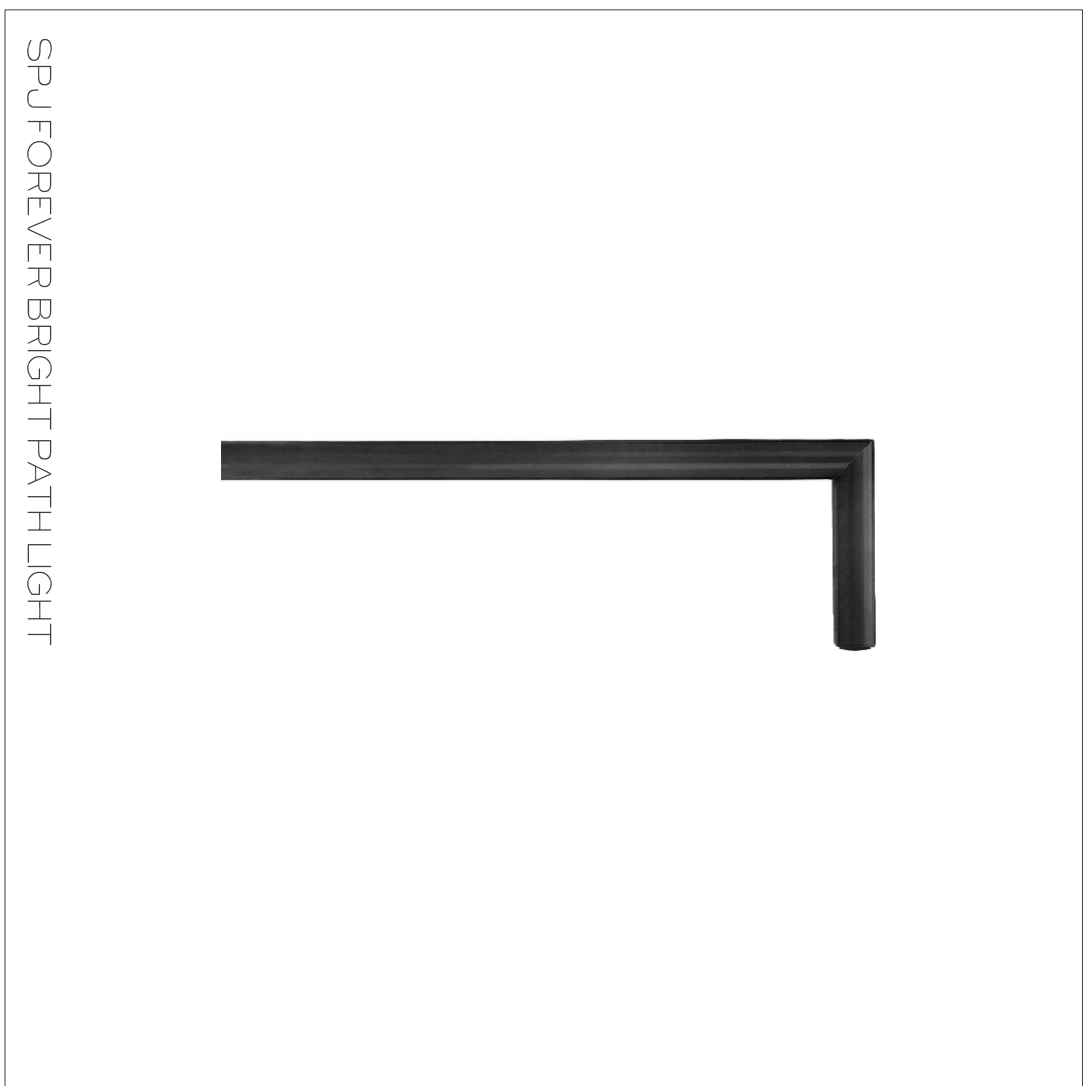

Terra Form Inc.

Philip Castiglia, Owner
 phone: (818) 535-0848
 email: aiskur@yahoo.com

CASTIGLIA PROPERTY
 4770 EAST 2650 NORTH . EDEN UTAH. 84310
EXTERIOR LIGHTING PLAN

Date: 5/26/21

Scale: 1/8" = 1'

