

# THE POINTE AT WOLF CREEK RESORT

## CONSTRUCTION SET EDEN, WEBER , UTAH

### TRAFFIC CONTROL & SAFETY NOTES

1. BARRICADING AND DETOURING SHALL BE IN CONFORMANCE WITH THE REQUIREMENTS OF THE CURRENT STATE OF UTAH DEPARTMENT OF TRANSPORTATION MANUAL OF TRAFFIC CONTROLS FOR CONSTRUCTION AND MAINTENANCE WORK ZONES, AND THE CURRENT COUNTY STANDARD DRAWING, AND SHALL BE APPROVED PRIOR TO ANY WORK.
2. NO STREET SHALL BE CLOSED TO TRAFFIC WITHOUT WRITTEN PERMISSION FROM THE COUNTY ENGINEER, EXCEPT WHEN DIRECTED BY LAW ENFORCEMENT OR FIRE OFFICIALS.
3. THE CONTRACTOR SHALL MAKE EVERY EFFORT TO PROVIDE FOR SMOOTH TRAFFIC FLOW AND SAFETY. ACCESS SHALL BE MAINTAINED FOR ALL PROPERTIES ADJACENT TO THE WORK.
4. DETOURING OPERATIONS FOR A PERIOD OF SIX CONSECUTIVE CALENDAR DAYS, OR MORE, REQUIRE THE INSTALLATION OF TEMPORARY STREET STRIPING AND REMOVAL OF INTERFERING STRIPING BY SANDBLASTING. THE DETOURING STRIPING PLAN OR CONSTRUCTION TRAFFIC CONTROL PLAN MUST BE SUBMITTED TO THE COUNTY ENGINEER FOR REVIEW AND APPROVAL.
5. ALL TRAFFIC CONTROL DEVICES SHALL BE RESTORED TO THEIR ORIGINAL CONDITION AT THE END OF THE WORK TO THE SATISFACTION OF THE COUNTY ENGINEER
6. TRAFFIC CONTROL DEVICES (TCDs) SHALL REMAIN VISIBLE AND OPERATIONAL AT ALL TIMES.

### UTILITY DISCLAIMER

THE CONTRACTOR IS SPECIFICALLY CAUTIONED THAT EXISTING UNDERGROUND UTILITIES AND IMPROVEMENTS ARE SHOWN IN THEIR APPROXIMATE LOCATIONS BASED UPON RECORD INFORMATION AVAILABLE AT THE TIME OF PREPARATION OF PLANS. LOCATIONS MAY NOT HAVE BEEN VERIFIED IN THE FIELD AND NO GUARANTEE IS MADE AS TO ACCURACY OR COMPLETENESS OF THE INFORMATION SHOWN. IT SHALL BE RESPONSIBILITY OF THE CONTRACTOR TO DETERMINE THE EXISTENCE AND LOCATION OF THOSE UTILITIES SHOWN ON THESE PLANS OR INDICATED IN THE FIELD BY LOCATING SERVICES. ANY ADDITIONAL COSTS INCURRED AS A RESULT OF CONTRACTOR'S FAILURE TO VERIFY LOCATIONS OF EXISTING UTILITIES PRIOR TO BEGINNING OF CONSTRUCTION IN THEIR VICINITY SHALL BE BORNE BY THE CONTRACTOR AND ASSUMED INCLUDED IN THE CONTRACT.

### NOTICE TO CONTRACTOR

ALL CONTRACTORS AND SUBCONTRACTORS PERFORMING WORK SHOWN ON OR RELATED TO THESE PLANS SHALL CONDUCT THEIR OPERATIONS SO THAT ALL EMPLOYEES ARE PROVIDED A SAFE PLACE TO WORK AND THE PUBLIC IS PROTECTED. ALL CONTRACTORS AND SUBCONTRACTORS SHALL COMPLY WITH THE "OCCUPATIONAL SAFETY AND HEALTH REGULATIONS OF THE U.S. DEPARTMENT OF LABOR AND THE STATE OF UTAH DEPARTMENT OF INDUSTRIAL RELATIONS CONSTRUCTION SAFETY ORDERS". THE CIVIL ENGINEER SHALL NOT BE RESPONSIBLE IN ANY WAY FOR CONTRACTORS AND SUBCONTRACTORS COMPLIANCE WITH SAID REGULATIONS AND ORDERS.

CONTRACTOR FURTHER AGREES THAT HE SHALL ASSUME SOLE AND COMPLETE RESPONSIBILITY FOR JOB-SITE CONDITIONS DURING THE COURSE OF CONSTRUCTION OF THIS PROJECT, INCLUDING SAFETY OF ALL PERSONS AND PROPERTY, THAT THIS REQUIREMENT SHALL APPLY CONTINUOUSLY AND NOT BE LIMITED TO NORMAL WORKING HOURS, AND THAT THE CONTRACTOR SHALL DEFEND, INDEMNIFY AND HOLD THE OWNER AND THE CIVIL ENGINEER HARMLESS FROM ANY AND ALL LIABILITY, REAL OR ALLEGED IN CONNECTION WITH THE PERFORMANCE OF WORK ON THIS PROJECT, EXCEPTING FOR LIABILITY ARISING FROM THE SOLE NEGLIGENCE OF THE OWNER OR ENGINEER.

### SANITARY SEWER GENERAL NOTES

1. ALL SANITARY SEWER CONSTRUCTION SHALL BE IN CONFORMANCE WITH WOLF CREEK WATER AND SEWER IMPROVEMENT (WCWSD) DISTRICT STANDARDS AND SPECIFICATIONS.
2. ALL GRAVITY SANITARY SEWER LINES SHALL BE SDR-35 PVC MATERIAL. SEWER LINE CONSTRUCTION AND MATERIALS SHALL CONFORM TO ASTM STANDARDS AND SPECIFICATIONS.
3. DISTANCES SHOWN ON PLANS ARE APPROXIMATE AND COULD VARY DUE TO VERTICAL ALIGNMENT.
4. RIM ELEVATIONS SHOWN ARE APPROXIMATE ONLY AND ARE NOT TO BE TAKEN AS FINAL ELEVATION. PIPELINE CONTRACTOR SHALL USE PRECAST CONCRETE ADJUSTMENT RINGS, GROUT AND STEEL SHIMS TO ADJUST THE MANHOLE FRAME TO THE REQUIRED FINAL GRADE IN CONFORMANCE WITH THE STANDARD SPECIFICATIONS. ALL FRAMES SHALL BE ADJUSTED TO FINAL GRADE.
5. ALL SANITARY SEWER MAIN TESTING SHALL BE IN ACCORDANCE WITH (WCWSD) STANDARDS AND SPECIFICATIONS. COPIES OF ALL TEST RESULTS SHALL BE PROVIDED TO THE PUBLIC WORKS SANITARY SEWER DEPARTMENT HEAD PRIOR TO FINAL ACCEPTANCE.
6. COMPACTION TESTING OF ALL TRENCHES WITH THE PROJECT SITE MUST BE ATTAINED AND RESULTS SUBMITTED PRIOR TO FINAL ACCEPTANCE.
7. CONTRACTOR IS RESPONSIBLE TO PROTECT ALL EXISTING STRUCTURES AND IMPROVEMENTS DURING INSTALLATION OF SANITARY SEWER LINE.
8. WHERE CONNECTION TO EXISTING UTILITY IS PROPOSED, CONTRACTOR SHALL VERIFY LOCATION AND ELEVATION AND NOTIFY OWNER/ENGINEER IF LOCATION AND ELEVATION OF EXISTING UTILITY VARIES FROM THE DESIGN.
9. CAMERA TESTING AND PRESSURE TESTING PER (WCWSD) STANDARD.

### SWPPP GENERAL NOTES

1. CONTRACTOR SHALL OBTAIN ALL NECESSARY PERMITS AS REQUIRED BY THE COUNTY AND STATE.
2. ALL STRUCTURAL EROSION MEASURES SHALL BE INSTALLED AS SHOWN ON THE SWPP PLAN, PRIOR TO ANY OTHER GROUND-DISTURBING ACTIVITY. ALL EROSION CONTROL MEASURES SHALL BE MAINTAINED IN GOOD REPAIR BY THE CONTRACTOR, UNTIL SUCH TIME AS THE ENTIRE DISTURBED AREAS ARE STABILIZED WITH HARD SURFACE OR LANDSCAPING.

### GENERAL NOTES

1. ALL MATERIALS, WORKMANSHIP AND CONSTRUCTION OF SITE IMPROVEMENTS SHALL MEET OR EXCEED THE STANDARDS AND SPECIFICATIONS SET FORTH BY THE COUNTY ENGINEER, PLANNING, CODES AND SPECIFICATIONS AND APPLICABLE STATE AND FEDERAL REGULATIONS. WHERE THERE IS CONFLICT BETWEEN THESE PLANS AND SPECIFICATIONS, OR ANY APPLICABLE STANDARDS, THE HIGHER QUALITY STANDARD SHALL APPLY.
2. THE CONTRACTOR IS SPECIFICALLY CAUTIONED THAT THE LOCATION AND OR ELEVATION OF EXISTING UTILITIES, AS SHOWN ON THESE PLANS IS BASED ON RECORDS OF THE VARIOUS UTILITY COMPANIES AND WHERE POSSIBLE, MEASUREMENTS TAKEN IN THE FIELD. THE INFORMATION IS NOT TO BE RELIED UPON AS BEING EXACT OR COMPLETE. THE CONTRACTOR MUST CALL THE LOCAL UTILITY LOCATION CENTER AT LEAST 48 HOURS BEFORE ANY EXCAVATION TO REQUEST EXACT FIELD LOCATIONS OF THE UTILITIES. PRIOR TO CONSTRUCTION, THE CONTRACTOR SHALL VERIFY PERTINENT LOCATIONS AND ELEVATIONS, ESPECIALLY AT THE CONNECTION POINTS AND AT POTENTIAL UTILITY CONFLICTS. IT SHALL BE THE RESPONSIBILITY OF THE CONTRACTOR TO RELOCATE ALL EXISTING UTILITIES THAT CONFLICT WITH THE PROPOSED IMPROVEMENTS SHOWN ON THESE PLANS.
3. THE CONTRACTOR IS RESPONSIBLE FOR OBTAINING ALL NECESSARY PERMITS FROM ALL APPLICABLE AGENCIES. THE CONTRACTOR SHALL NOTIFY THE DESIGNATED PUBLIC WORKS INSPECTOR AT LEAST 48 HOURS PRIOR TO THE START OF ANY EARTH DISTURBING ACTIVITY, OR CONSTRUCTION ON ANY AND ALL PUBLIC IMPROVEMENTS.
4. THE CONTRACTOR SHALL COORDINATE AND COOPERATE WITH THE COUNTY AND ALL UTILITY COMPANIES INVOLVED WITH REGARD TO RELOCATIONS OR ADJUSTMENTS OF EXISTING UTILITIES DURING CONSTRUCTION AND TO ASSURE THAT THE WORK IS ACCOMPLISHED IN A TIMELY FASHION AND WITH A MINIMUM DISRUPTION OF SERVICE.
5. THE CONTRACTOR SHALL HAVE ONE (1) COPY OF APPROVED PLANS, AND ONE (1) COPY OF THE APPROPRIATE STANDARDS AND SPECIFICATIONS AND A COPY OF ANY PERMITS AND EXTENSION AGREEMENTS NEEDED FOR THE JOB, ON SITE AT ALL TIMES.
6. THE CONTRACTOR SHALL BE RESPONSIBLE FOR ALL ASPECTS OF SAFETY INCLUDING BUT NOT LIMITED TO, EXCAVATION, TRENCHING, SHORING, TRAFFIC CONTROL, AND SECURITY.
7. IF DURING THE CONSTRUCTION PROCESS CONDITIONS ARE ENCOUNTERED BY THE CONTRACTOR, HIS SUBCONTRACTORS, OR OTHER AFFECTED PARTIES, WHICH COULD INDICATE A SITUATION THAT IS NOT IDENTIFIED IN THE PLANS OR SPECIFICATIONS, THE CONTRACTOR SHALL CONTACT THE ENGINEER IMMEDIATELY.
8. THE CONTRACTOR IS RESPONSIBLE FOR PROVIDING ALL LABOR AND MATERIALS NECESSARY FOR THE COMPLETION OF THE INTENDED IMPROVEMENTS SHOWN ON THESE DRAWINGS OR DESIGNATED TO BE PROVIDED, INSTALLED, CONSTRUCTED, REMOVED AND RELOCATED UNLESS SPECIFICALLY NOTED OTHERWISE.
9. THE CONTRACTOR SHALL BE RESPONSIBLE FOR KEEPING ROADWAYS FREE AND CLEAR OF ALL CONSTRUCTION DEBRIS AND DIRT TRACKED FROM THE SITE.
10. THE CONTRACTOR SHALL BE RESPONSIBLE FOR RECORDING AS-BUILT DRAWINGS ON A SET OF RECORD DRAWINGS KEPT AT THE CONSTRUCTION SITE, AND AVAILABLE TO THE COUNTY INSPECTOR AT ALL TIMES.
11. THE CONTRACTOR SHALL SEQUENCE INSTALLATION OF UTILITIES IN SUCH A MANNER AS TO MINIMIZE POTENTIAL UTILITY CONFLICTS. IN GENERAL, STORM SEWER AND SANITARY SEWER SHOULD BE CONSTRUCTED PRIOR TO INSTALLATION OF WATER LINES AND DRY UTILITIES.
12. IT SHALL BE THE RESPONSIBILITY OF THE CONTRACTOR TO COORDINATE ALL UTILITY RELOCATIONS CONSISTENT WITH THE CONTRACTORS SCHEDULE FOR THIS PROJECT, WHETHER SHOWN OR NOT SHOWN AS IT RELATES TO THE CONSTRUCTION ACTIVITIES CONTEMPLATED IN THESE PLANS.
13. FOLLOW RECOMMENDATIONS IN GEOTECH REPORT.
14. ROCK WALLS THAT ARE 4FT IN HEIGHT OR HIGHER REQUIRE AN ENGINEERED DESIGN. DESIGN WILL NEED TO BE STAMPED BY ENGINEER PROVIDE LETTER FROM THE ENGINEER STATING THAT THEY WERE INSTALLED PROPERLY.

### STORM DRAIN GENERAL NOTES

1. THE CONTRACTOR SHALL BE RESPONSIBLE FOR THE FOLLOWING:  
A)OBTAIN ALL REQUIRED PERMITS FROM THE COUNTY OR REGULATORY AGENCIES, INCLUDING PERMITS TO WORK IN THE RIGHT-OF-WAY.  
B)RESTORATION OF EXISTING IMPROVEMENTS INCLUDING BUT NOT LIMITED TO FENCES, SOD, LANDSCAPING, PAVEMENT, SPRINKLER SYSTEM.  
C)VERIFICATION AND PROTECTION OF ALL EXISTING IMPROVEMENTS WITHIN THE LIMITS OF CONSTRUCTION.  
D)PROVIDING AS-BUILT DRAWINGS TO THE COUNTY AND THE ENGINEER.  
E)ALL PERMITTING, DEVELOPMENT, LOCATION, CONNECTION AND INSPECTION AND SCHEDULING FOR SUCH.
2. ALL STORM SEWER CONNECTIONS SHALL BE IN CONFORMANCE WITH COUNTY STANDARDS AND SPECIFICATIONS.
3. RIM ELEVATIONS SHOWN ARE APPROXIMATE ONLY AND ARE NOT TO BE TAKEN AS FINAL ELEVATION. PIPELINE CONTRACTOR SHALL USE PRECAST CONCRETE ADJUSTMENT RINGS, GROUT, AND STEEL SHIMS TO ADJUST THE MANHOLE FRAME TO THE REQUIRED FINAL GRADE IN CONFORMANCE WITH COUNTY STANDARDS AND SPECIFICATIONS AND PLANS. ALL FRAMES SHALL BE ADJUSTED TO FINAL GRADE PRIOR TO PLACEMENT OF ASPHALT PAVING.
4. COMPACTION OF ALL TRENCHES WITHIN THE PROJECT SITE MUST BE ATTAINED AND COMPACTION RESULTS SUBMITTED PRIOR TO FINAL ACCEPTANCE.
5. ALL STORM DRAIN PIPES IN THE COUNTY RIGHT-OF-WAY SHALL BE RCP CL III.
6. ALL STORM SEWER MANHOLES IN PAVED AREAS SHALL BE FLUSH WITH THE PAVEMENT AND SHALL HAVE TRAFFIC BEARING LIDS. ALL STORM SEWER LIDS SHALL BE LABELED "STORM DRAIN".
7. WHERE CONNECTION TO EXISTING UTILITY IS PROPOSED, CONTRACTOR SHALL VERIFY LOCATION AND ELEVATION AND NOTIFY OWNER/ENGINEER IF LOCATION AND ELEVATION OF EXISTING UTILITY VARIES FROM THE DESIGN.

### GENERAL GRADING NOTES

1. ALL WORK SHALL BE IN ACCORDANCE WITH THE LATEST APWA STANDARDS AND SPECIFICATION FOR PUBLIC WORKS AND THE COUNTY STANDARDS. CONTRACTOR SHALL ENSURE POSITIVE DRAINAGE AWAY FROM BUILDING FOUNDATIONS AND ENTRIES. FINISHED GRADE AT FOUNDATION FOR WOOD FRAMED STRUCTURES SHALL BE 8 INCHES BELOW TOP OF FOUNDATION AND DRAINAGE SHALL BE A MINIMUM OF 5% WITHIN 10 FEET FROM THE BUILDING.
2. MAXIMUM SLOPES SHALL BE 3:1 FOR CUT AND FILL UNLESS OTHERWISE NOTED.
3. COMPACTION REQUIREMENTS AND TESTING SHALL BE PERFORMED TO MEET THE COUNTY STANDARDS.
4. NO FILL SHALL BE PLACED UNTIL VEGETATION HAS BEEN REMOVED AND SUB-GRADE PREPARED PER THE SOILS REPORT.
5. DUST SHALL BE CONTROLLED BY WATERING OR OTHER APPROVED METHODS.
6. CONTRACTOR SHALL COMPLY WITH STORM WATER POLLUTION PREVENTION PLAN BY INSTALLING BMP'S PRIOR TO COMMENCEMENT OF EXCAVATION ACTIVITIES.
7. ALL RECOMMENDATIONS OF THE GEOTECHNICAL REPORT AND ALL SUBSEQUENT REPORTS, ADDENDUM ETC. SHALL BE CONSIDERED A PART OF THIS GRADING PLAN AND SHALL BE COMPLIED WITH.
8. THE CONTRACTOR SHALL CONTACT BLUE STAKES FOR LOCATION MARKING PRIOR TO COMMENCING EXCAVATION ACTIVITIES.
9. COUNTY MAY REQUIRE A PRE-CONSTRUCTION MEETING BEFORE A PERMIT IS ISSUED.
10. STREETS ADJACENT TO THE PROJECT SHALL BE CLEAN AT ALL TIMES.
11. CONTRACTOR IS RESPONSIBLE FOR ARRANGING FOR ALL REQUIRED INSPECTIONS.
12. PRIOR TO TAKING WATER FROM A COUNTY FIRE HYDRANT, THE CONTRACTOR SHALL MAKE ARRANGEMENTS WITH THE WATER UTILITY TO OBTAIN A WATER METER.

### CULINARY WATER GENERAL NOTES

1. ALL INSTALLATION AND MATERIALS SHALL CONFORM TO WATER UTILITY STANDARDS, SPECIFICATIONS AND PLANS.
2. THRUST BLOCKING IS REQUIRED AT ALL BENDS AND FITTINGS. TIE RODS SHALL BE USED AT ALL BENDS AND FITTINGS WHERE THRUST BLOCKS DO NOT BEAR AGAINST UNDISTURBED SOIL.
3. ALL WATERLINES AT SEWER CROSSINGS SHALL BE LOCATED ABOVE AND HAVE AN 18-INCH VERTICAL SEPARATION FROM THE SEWER PIPE. IF THIS IS NOT PROVIDED, THE WATERLINE SHALL BE INSTALLED WITH 20 L.F. OF CONCRETE CASING CENTERED OVER THE SEWER PIPE.
4. DISINFECTION TESTS SHALL BE PERFORMED BY THE WATER UTILITY WITH COOPERATION FROM THE CONTRACTOR IN PERFORMING ANY NECESSARY EXCAVATION AND SUBSEQUENT BACKFILLING AT NO COST TO THE DISTRICT..
5. CHLORINATION OF COMPLETED WATER LINE. THE NEW WATER LINES SHALL BE DISINFECTED BY CHLORINATION. THE CONTRACTOR WILL BE RESPONSIBLE FOR ALL RELATED COSTS AND FEES RELATED TO THE CHLORINATION OF THE COMPLETED WATER LINE. THIS TEST SHALL BE PERFORMED PRIOR TO CONNECTION OF THE NEW WATER LINES TO THE EXISTING WATER SYSTEM. THE CONTRACTOR SHALL NOTIFY THE WATER UTILITY AT LEAST 24 HOURS BEFORE THE CHLORINATION IS DESIRED.
6. A MINIMUM HORIZONTAL CLEARANCE OF 10 FEET SHALL BE MAINTAINED FROM SANITARY SEWER MAINS.
7. UNLESS OTHERWISE SPECIFIED, ALL WATERLINES SHALL BE DUCTILE IRON CLASS 52 PER DISTRICT STANDARDS.
8. CONTRACTOR SHALL LOCATE VALVES PRIOR TO CONNECTION WITH EXISTING SYSTEM, BUT SHALL NOT OPERATE ANY VALVE WITHOUT PERMISSION FROM THE WATER UTILITY.
9. ALL WATER MAINS, VALVES, FIRE HYDRANTS, SERVICES AND APPURTENANCES SHALL BE INSTALLED, TESTED, AND APPROVED PRIOR TO PAVING.
10. THERE SHALL BE A WATER SUPPLY TO THE DEVELOPMENT BEFORE ANY WOOD CONSTRUCTION STARTS.

### WEBER FIRE DISTRICT GENERAL NOTES

1. FIRE FLOW: ALL DWELLINGS STRUCTURES OVER 5000 SQ. FT. WHICH DO NOT MEET THE FIRE FLOW REQUIREMENTS, SHALL BE EQUIPPED WITH AN NFPA 13D COMPLIANT FIRE SPRINKLER SYSTEM OR BE PROVIDED WITH AREA SEPARATIONS COMPLIANT WITH THE IBC/IRC. FOR MORE INFORMATION REGARDING FIRE FLOW, PLEASE CONTACT FIRE MARSHAL THUESON AT 801-782-3580.
2. ROADS AND BRIDGES SHALL BE DESIGNED, CONSTRUCTED AND MAINTAINED TO SUPPORT AN IMPOSED LOAD OF 75,000 LBS.
3. ALL ROADS SHALL BE DESIGNED, CONSTRUCTED, SURFACED AND MAINTAINED SO AS TO PROVIDE AN ALL-WEATHER DRIVING SURFACE.
4. FIRE ACCESS ROADS FOR THIS PROJECT SHALL BE COMPLETED AND APPROVED PRIOR TO ANY COMBUSTIBLE CONSTRUCTION. TEMPORARY ROADS SHALL MEET THE SAME REQUIREMENTS FOR HEIGHT, WIDTH AND IMPOSED LOADS AS PERMANENT ROADS.
5. ALL REQUIRED FIRE HYDRANTS AND WATER SYSTEMS SHALL BE INSTALLED, APPROVED AND FULLY FUNCTIONAL PRIOR TO ANY COMBUSTIBLE CONSTRUCTION.

ALL IMPROVEMENTS TO CONFORM TO CURRENT COUNTY STANDARDS AND SPECIFICATIONS

CULINARY WATER, SECONDARY WATER AND SEWER IMPROVEMENTS TO CONFORM TO THE WOLF CREEK WATER AND SEWER IMPROVEMENT DISTRICT STANDARDS AND SPECIFICATIONS

THE POINTE AT WOLF CREEK RESORT

CONSTRUCTION SET









**KEY NOTES:**

- 1A) 24" STANDARD CURB AND GUTTER (SEE DETAIL ON SHEET C5)
- 1B) 24" OPEN FACE CURB AND GUTTER (SEE DETAIL ON SHEET C5)
- 2) PROPOSED ASPHALT PAVING (3" ASPHALT / 8" BASE COURSE)
- 3) TYPICAL PARKING STRIPING TO BE 4" WHITE
- 4) TYPICAL "NO PARKING" STRIPING
- 5) ADA PARKING SYMBOL / REQUIRED ADA SIGN
- 6) EXISTING 30" STANDARD CURB AND GUTTER
- 7) PROPOSED SIDEWALK/CONCRETE
- 8) RETAINING WALL
- 9) EXISTING BOUNDARY
- 10) PROPOSED BOUNDARY
- 11) TRASH ENCLOSURE (SEE ARCHITECTURAL PLANS)
- 12) SAW CUT
- 13) EXISTING TRASH ENCLOSURE
- 14) TRAIL
- 15) MONUMENT
- 16) BOLLARD LIGHT (SEE DETAIL)
- 17) ADA RAMP
- 18) ACCESS RAMP WITH RAILINGS PER ADA REQ.
- 19) STAIRS WITH RAILINGS
- 20) UNDERGROUND DETENTION AREA

**SITE INFORMATION**

BUILDING	29,919 SF	22.55%
ASPHALT/CONCRETE	45,175 SF	34.05%
LANDSCAPING/GRAVEL	42,769 SF	32.23%
STAIRS/PATIOS/OTHER	14,823 SF	11.17%
<b>TOTAL SITE AREA:</b>	<b>132,686</b>	<b>100.0%</b>
	<b>3.05 ACRES</b>	
<b>PARKING STALLS PROVIDED:</b>	<b>85 SPACES</b>	
<b>(INCLUDES 6 HANDICAP STALLS)</b>		

- BUILDING
- SIDEWALK
- TBC
- ASPHALT
- PARKING STRIP
- EX. SIDEWALK
- EX. TBC
- EX. ASPHALT
- SETBACK LINE
- ADJOINER
- EASEMENT
- PARKING EASEMENT
- BOUNDARY LINE
- BOUNDARY LINE ADDITION
- ZONING EXCHANGE
- 22,885 SF
- NEW ASPHALT 39,485 SF
- NEW CONCRETE 9,470 SF
- ▨ OPEN FACE CURB AND GUTTER
- ▨ ASPHALT PATCH
- ▨ DETENTION AREA

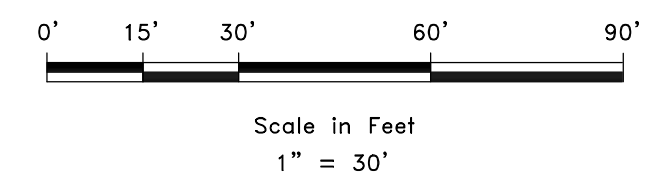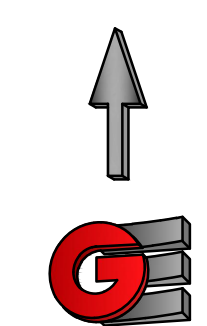

REVISIONS	
DATE	DESCRIPTION
10-9-2021	REVISED DETENTION/SD

SCALE: 1" = 30'  
 DATE: 9-10-21  
 DESIGN: RC  
 DRAWN: LZ  
 CHECKED: RC

**SITE PLAN**

**THE POINTE - CONSTRUCTION SET**

**3718 WOLF CREEK DR**

**WEBER COUNTY, UTAH**


**GARDNER ENGINEERING**

CIVIL - LAND PLANNING  
MUNICIPAL - LAND SURVEYING

51150 SOUTH 375 EAST OGDEN, UT  
OFFICE: 801.476.0202 FAX: 801.476.0066

**CE1-01**



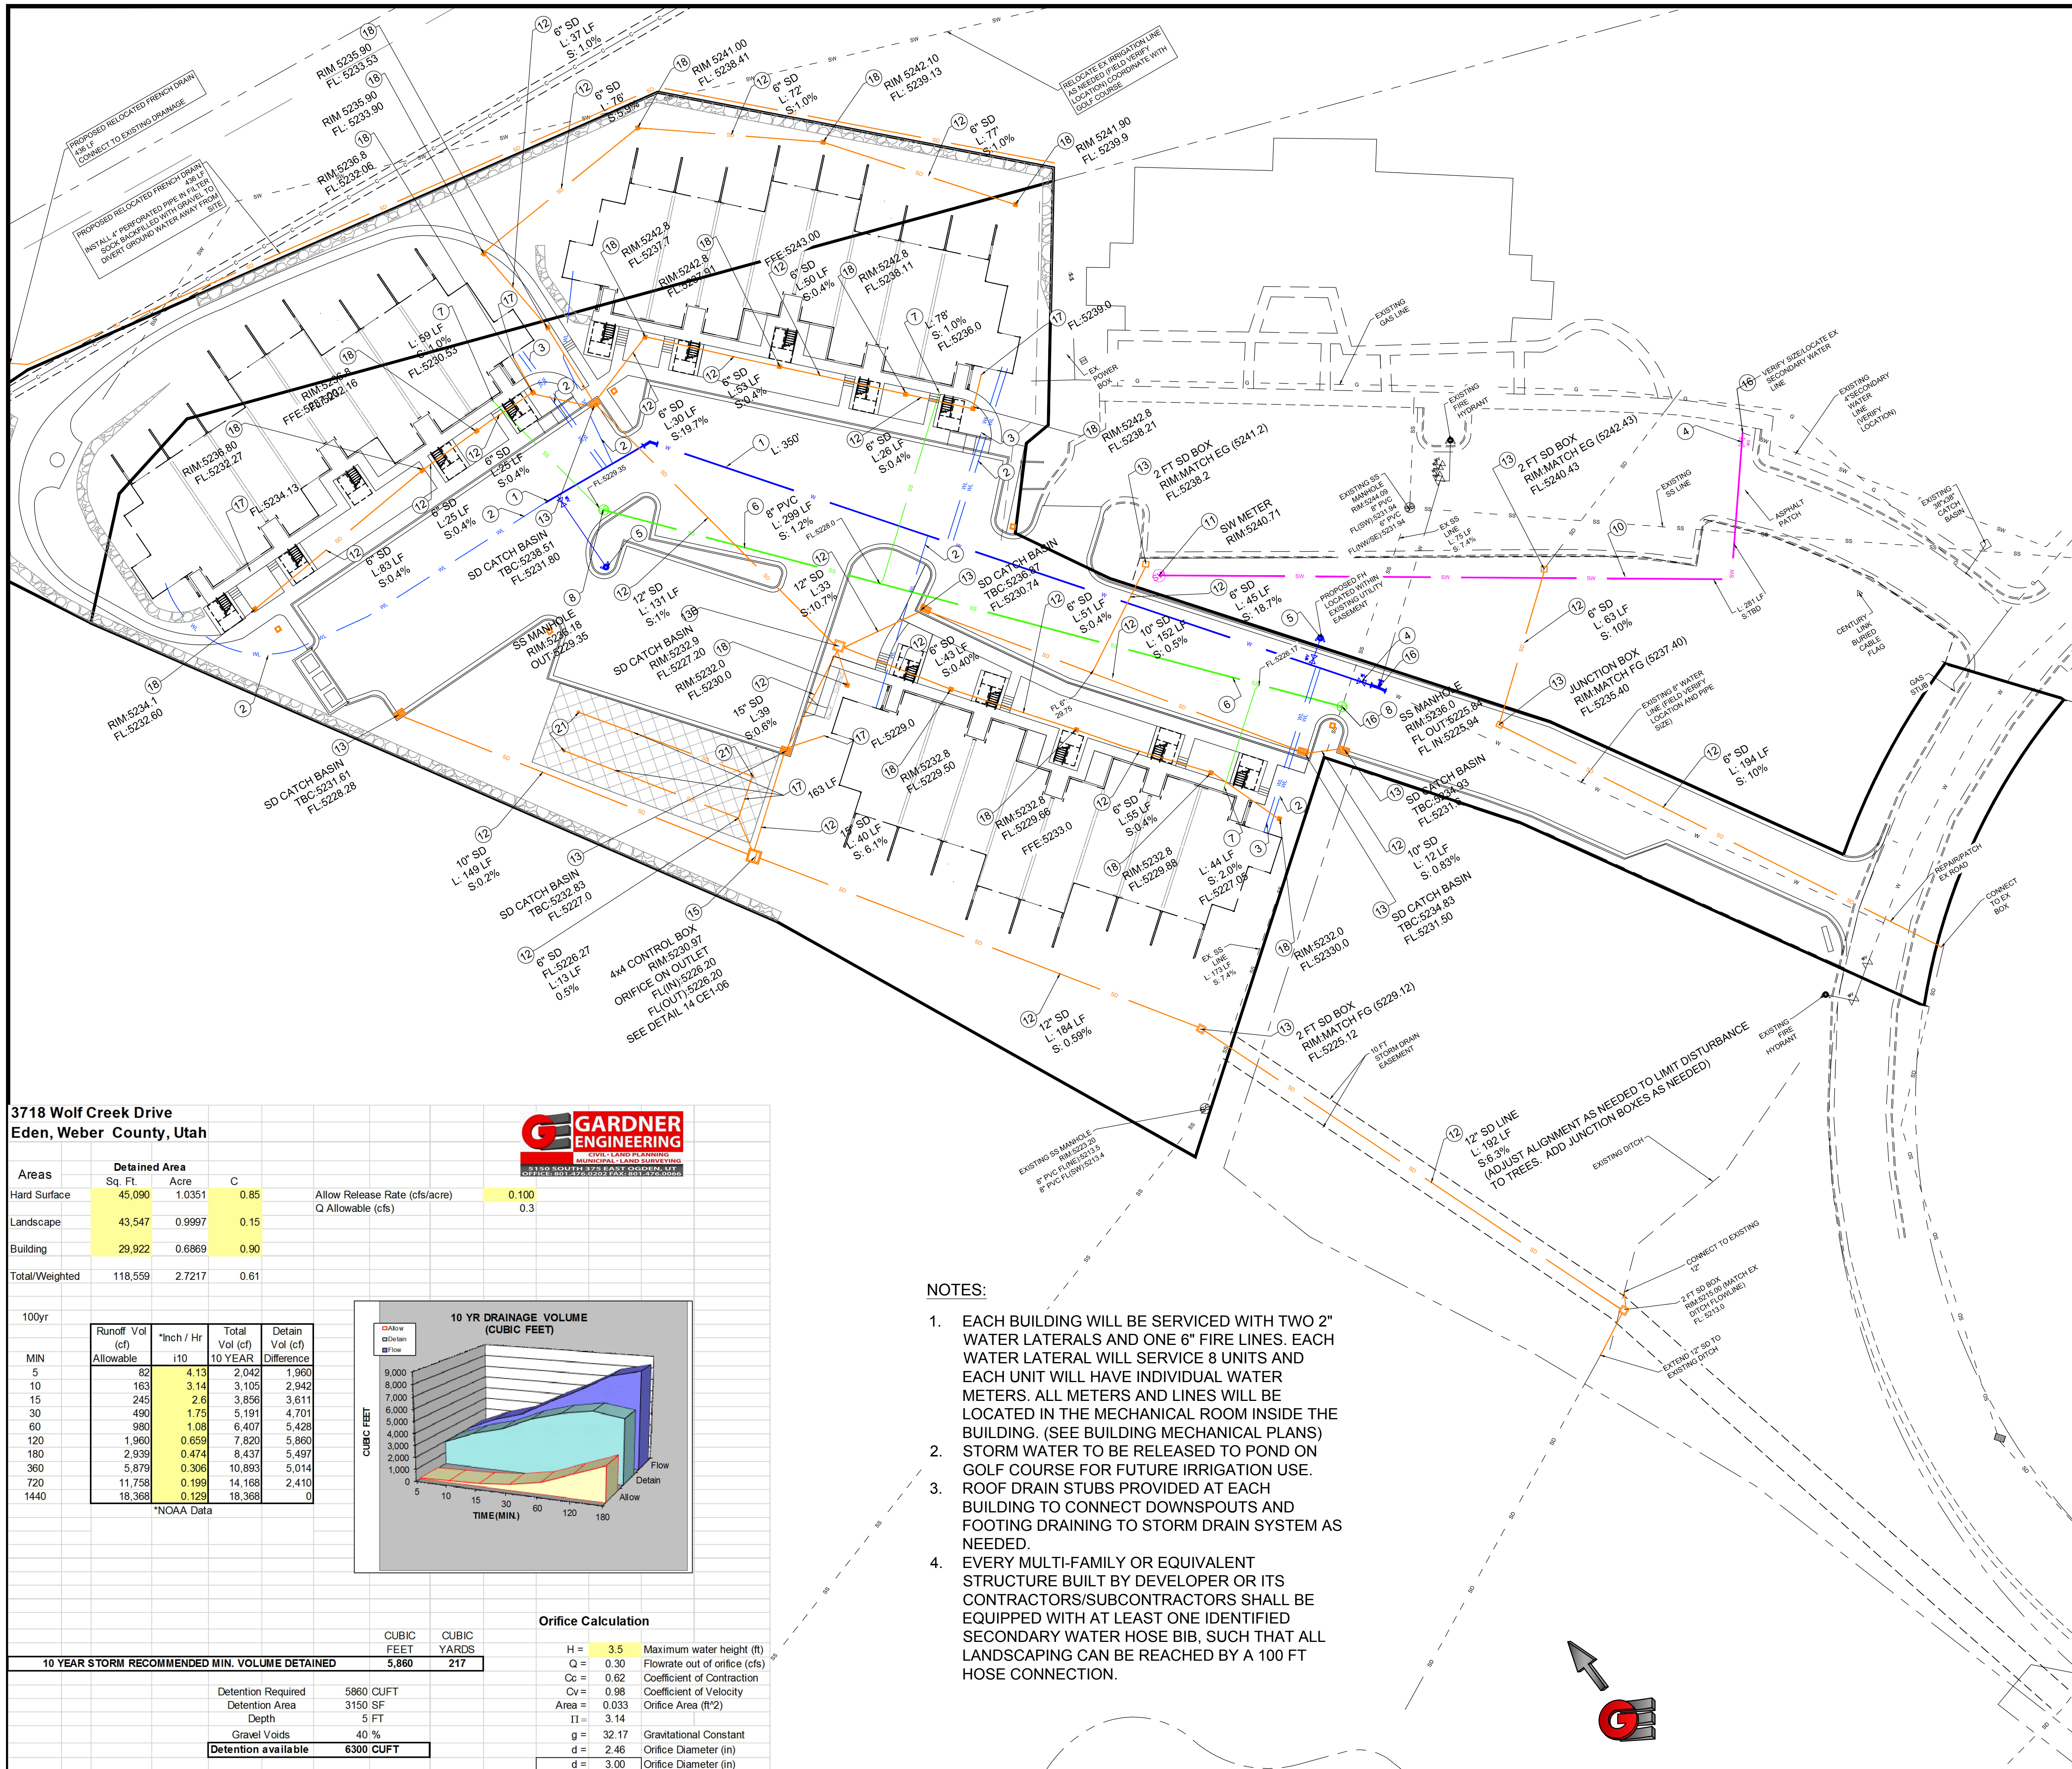

**KEY NOTES:**

- 1 8" DUCTILE IRON CLASS 52 WATER LINE (PER DISTRICT STANDARDS)
- 2 2" WATER LATERAL (SEE NOTE 1) (PER DISTRICT STANDARDS)
- 3 6" FIRE LINE (PER DISTRICT STANDARDS) (SEE NOTE 1)
- 4 GATE VALVE (PER DISTRICT STANDARDS)
- 5 INSTALL FIRE HYDRANT ASSEMBLY (PER DISTRICT STANDARDS)
- 6 8" PVC SDR-35 SEWER LINE (PER DISTRICT STANDARDS)
- 7 6" PVC SEWER LATERAL (COORDINATE WITH BUILDING PLANS)
- 8 4' SEWER MANHOLE (PER DISTRICT STANDARDS)
- 9 SEWER CLEANOUT (PER DISTRICT STANDARDS)
- 10 4" SECONDARY WATER LINE (SIZE PER LANDSCAPING PLAN) (PER DISTRICT STANDARDS)
- 11 SECONDARY WATER METER (SIZE PER LANDSCAPING PLAN) (PER DISTRICT STANDARDS)
- 12 STORM DRAIN LINE (PER DISTRICT STANDARDS)
- 13 SD BOX (SEE NOTE FOR SIZE)
- 13B 3X3 SD BOX (SEE DETAIL)
- 14 STORM DRAIN DETENTION
- 15 STORM DRAIN CONTROL BOX (SEE DETAIL)
- 16 CONNECT TO EXISTING
- 17 ROOF DRAIN STUB (COORDINATE WITH BUILDING PLAN) (SEE NOTE 3)
- 18 12" INLINE DRAIN BOX
- 19 CUT OFF DRAIN
- 20 10" PERFORATED PIPE PVC (0% SLOPE)
- 21 PERFORATED PIPE CLEANOUT

**LEGEND**

- w — WATER
- wl — WATER LATERAL
- ex. w — EX. WATER
- ss — SEWER
- ex. ss — EX. SEWER
- sd — STORM DRAIN
- ex. sd — EX. STORM DRAIN
- sw — SECONDARY WATER
- ex. sw — EX. SECONDARY WATER
- — BUILDING
- — SIDEWALK
- — TBC
- — ASPHALT
- — PARKING STRIP
- — EX. SIDEWALK
- — EX. TBC
- — EX. ASPHALT
- — SETBACK LINE
- — ADJOINER
- — EASEMENT
- — BOUNDARY LINE
- — BOUNDARY LINE ADDITION
- — ZONING EXCHANGE 22,885 SF
- — NEW ASPHALT
- — NEW CONCRETE
- — LANDSCAPING
- — DETENTION AREA

**NOTES:**


1. EACH BUILDING WILL BE SERVICED WITH TWO 2" WATER LATERALS AND ONE 6" FIRE LINES. EACH WATER LATERAL WILL SERVICE 8 UNITS AND EACH UNIT WILL HAVE INDIVIDUAL WATER METERS. ALL METERS AND LINES WILL BE LOCATED IN THE MECHANICAL ROOM INSIDE THE BUILDING. (SEE BUILDING MECHANICAL PLANS)
2. STORM WATER TO BE RELEASED TO POND ON GOLF COURSE FOR FUTURE IRRIGATION USE. ROOF DRAIN STUBS PROVIDED AT EACH BUILDING TO CONNECT DOWNSPOUTS AND FOOTING DRAINING TO STORM DRAIN SYSTEM AS NEEDED.
3. EVERY MULTI-FAMILY OR EQUIVALENT STRUCTURE BUILT BY DEVELOPER OR ITS CONTRACTORS/SUBCONTRACTORS SHALL BE EQUIPPED WITH AT LEAST ONE IDENTIFIED SECONDARY WATER HOSE BIB, SUCH THAT ALL LANDSCAPING CAN BE REACHED BY A 100 FT HOSE CONNECTION.

**3718 Wolf Creek Drive  
Eden, Weber County, Utah**

Areas	Detained Area		
	Sq. Ft.	Acre	C
Hard Surface	45,090	1.0351	0.85
Landscape	43,547	0.9997	0.15
Building	29,922	0.6869	0.90
Total/Weighted	118,559	2.7217	0.61



MIN	Runoff Vol (cf)	*Inch / Hr	Total Vol (cf)	Detain Vol (cf)
	Allowable	i10	10 YEAR	Difference
5	82	4.13	2,042	1,960
10	163	3.14	3,105	2,942
15	245	2.6	3,856	3,611
30	490	1.75	5,191	4,701
60	980	1.08	6,407	5,428
120	1,960	0.659	7,820	5,860
180	2,939	0.474	8,437	5,497
360	5,879	0.306	10,893	5,014
720	11,758	0.199	14,168	2,410
1440	18,368	0.129	18,368	0

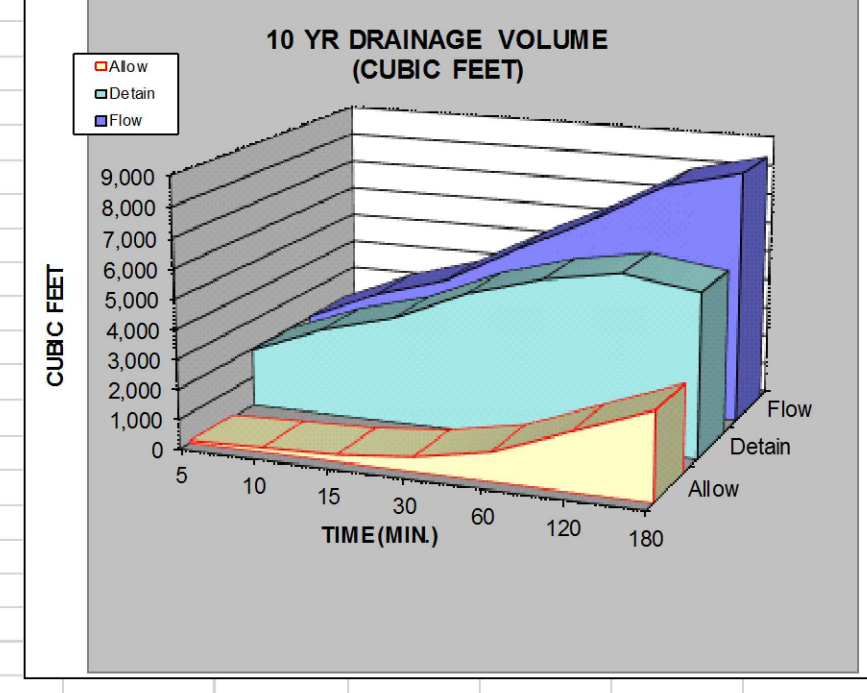

**Orifice Calculation**

H = 3.5	Maximum water height (ft)
Q = 0.30	Flowrate out of orifice (cfs)
Cc = 0.62	Coefficient of Contraction
Cv = 0.98	Coefficient of Velocity
Area = 0.033	Orifice Area (ft <sup>2</sup> )
II = 3.14	
g = 32.17	Gravitational Constant
d = 2.46	Orifice Diameter (in)
d = 3.00	Orifice Diameter (in)

10 YEAR STORM RECOMMENDED MIN. VOLUME DETAINED	5,860 CUFT
Detention Required	5860 CUFT
Detention Area	3150 SF
Depth	5 FT
Gravel Voids	40 %
Detention available	6300 CUFT

REVISIONS	DATE	DESCRIPTION
1	10-21-21	ADDED SD TO DRAIN EX. PARKING
2	10-9-2021	ADDED RELOCATED FRENCH DRAIN
3	10-9-2021	REVISED DETENTION/SD

SCALE	DATE	DESIGNER	DRAWN	CHECKED
1" = 30'	9-9-21	RC	LZ	RC

UTILITY PLAN  
THE POINTE - CONSTRUCTION SET  
3718 WOLF CREEK DR  
WEBER COUNTY, UTAH

**GARDNER ENGINEERING**  
CIVIL-LAND PLANNING  
MUNICIPAL-LAND SURVEYING  
5150 SOUTH 375 EAST OGDEN, UT  
OFFICE: 801-476-0202 FAX: 801-476-0066

CE1-02







**ABBREVIATIONS:**

- EG - EXISTING GROUND
- TBC - TOP BASE CURB
- LIP - LIP OF GUTTER
- TA - TOP OF ASPHALT
- FG - FINISHED GROUND
- TC - TOP OF CONCRETE
- TW - TOP OF WALL
- BW - BOTTOM OF WALL

- OPEN FACE CURB AND GUTTER
- EXISTING 10.0' CONTOUR
- EXISTING 10.0' CONTOUR
- NEW 2.0' DESIGN CONTOUR
- NEW 10.0' DESIGN CONTOUR

**NOTES:**

1. -----

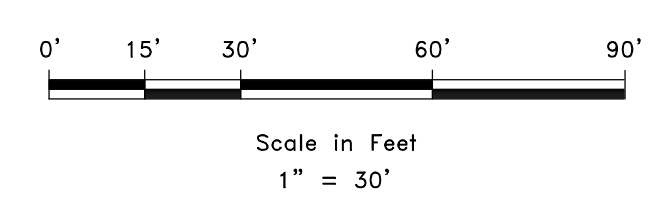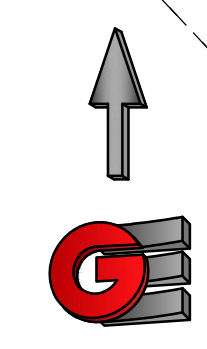

SCALE	1" = 30'
DATE	9-9-21
DESIGN	RC
DRAWN	LZ
CHECKED	RC

REVISIONS	DESCRIPTION
DATE	
10-9-2021	REVISED DETENTION/SD

DWG: 191301 - THE POINTE, 3718 WOLF CREEK DR, WEBER COUNTY, UTAH - CONSTRUCTION SET REV 11092.DWG

**GRADING PLAN**  
**THE POINTE - CONSTRUCTION SET**  
**3718 WOLF CREEK DR**  
**WEBER COUNTY, UTAH**

**GARDNER ENGINEERING**  
 CIVIL-LAND PLANNING  
 MUNICIPAL-LAND SURVEYING  
 5150 SOUTH 375 EAST OGDEN, UT  
 OFFICE: 801.476.0202 FAX: 801.476.0066


CE1-03

R:1201 - Lewis Home/SUD, THE POINTE DESIGN/DWG THE POINTE - Construction Set Rev 11092.DWG, CE1-03 - GRADING 11/10/2021 12:04:12 AM, ARCH: M, SUD: C, CAD: R, 16.00, Bldg: 1, 1



**EROSION CONTROL NOTES:**

1. SANDBAGS WILL BE PLACED AT DISCHARGE LOCATIONS TO CONTAIN AND DIVERT STORM WATER THROUGH THE INLET PROTECTION.
2. AN EARTHEN BERM 6" HIGH WILL BE CONSTRUCTED TO CONTAIN THE STORM WATER AND DIVERT IT TO DISCHARGE AREAS.
3. STORM WATER WILL BE DISCHARGED INTO AN EXISTING DRAINAGE SYSTEM. EXISTING LINES SHALL BE INSPECTED PRIOR TO CERTIFICATE OF OCCUPANCY AND CLEANED IF NECESSARY.
4. THE STORM WATER POLLUTION PREVENTION PLAN SHALL CONFORM TO ALL STATE DIVISION OF ENVIRONMENTAL PROTECTION REGULATIONS.

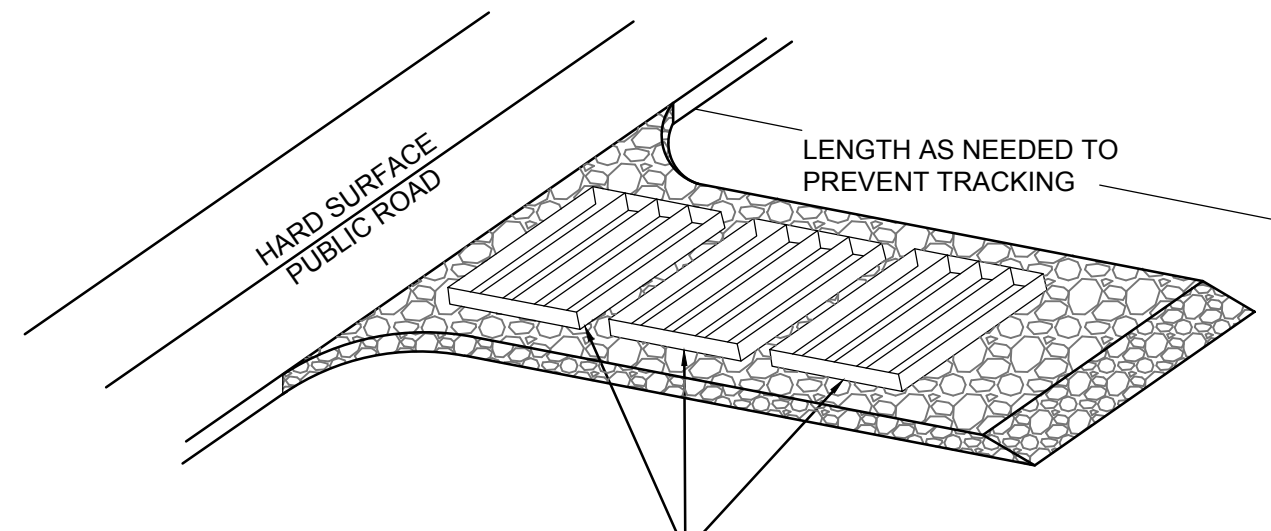

A SERIES OF STEEL PLATES (3 OR MORE) WITH RUMBLE STRIPS OR MIN. 3" COARSE AGGREGATE.

**ENTRANCE STABILIZATION NOTES:**


1. SEDIMENTS AND OTHER MATERIALS SHALL NOT BE TRACKED FROM THE SITE BY VEHICLE TRAFFIC. THE CONSTRUCTION ENTRANCE ROADWAYS SHALL BE STABILIZED SO AS TO PREVENT SEDIMENTS FROM BEING DEPOSITED INTO THE STORM DRAIN SYSTEMS. DEPOSITIONS MUST BE SWEEPED UP IMMEDIATELY AND MAY NOT BE WASHED DOWN BY RAIN OR OTHER MEANS INTO THE STORM DRAIN SYSTEM.
2. STABILIZED CONSTRUCTION ENTRANCE SHALL BE:
  - a. LOCATED AT ANY POINT WHERE TRAFFIC WILL BE ENTERING OR LEAVING A CONSTRUCTION SITE TO OR FROM A PUBLIC RIGHT-OF-WAY, STREET, ALLEY AND SIDEWALK OR PARKING AREA.
  - b. A SERIES OF STEEL PLATES WITH "RUMBLE STRIPS", AND/OR MIN. 3" COARSE AGGREGATE WITH LENGTH, WIDTH AND THICKNESS AS NEEDED TO ADEQUATELY PREVENT ANY TRACKING ONTO PAVED SURFACES.
3. ADDING A WASH RACK WITH A SEDIMENT TRAP LARGE ENOUGH TO COLLECT ALL WASH WATER CAN GREATLY IMPROVE EFFICIENCY.
4. ALL VEHICLES ACCESSING THE CONSTRUCTION SITE SHALL UTILIZE THE STABILIZED CONSTRUCTION ENTRANCE SITES.

**STREET MAINTENANCE NOTES:**

1. REMOVE ALL SEDIMENT DEPOSITED ON PAVED ROADWAYS IMMEDIATELY.
2. SWEEP PAVED AREAS THAT RECEIVE CONSTRUCTION TRAFFIC WHENEVER SEDIMENT BECOMES VISIBLE.
3. PAVEMENT WASHING WITH WATER IS PROHIBITED IF IT RESULTS IN A DISCHARGE TO THE STORM DRAIN SYSTEM.


**NOTE:**

CONTRACTOR SHALL COMPLETE AND SUBMIT A STATE NOTICE OF INTENT (NOI) AND A STORM WATER POLLUTION PREVENTION PLAN BOOKLET

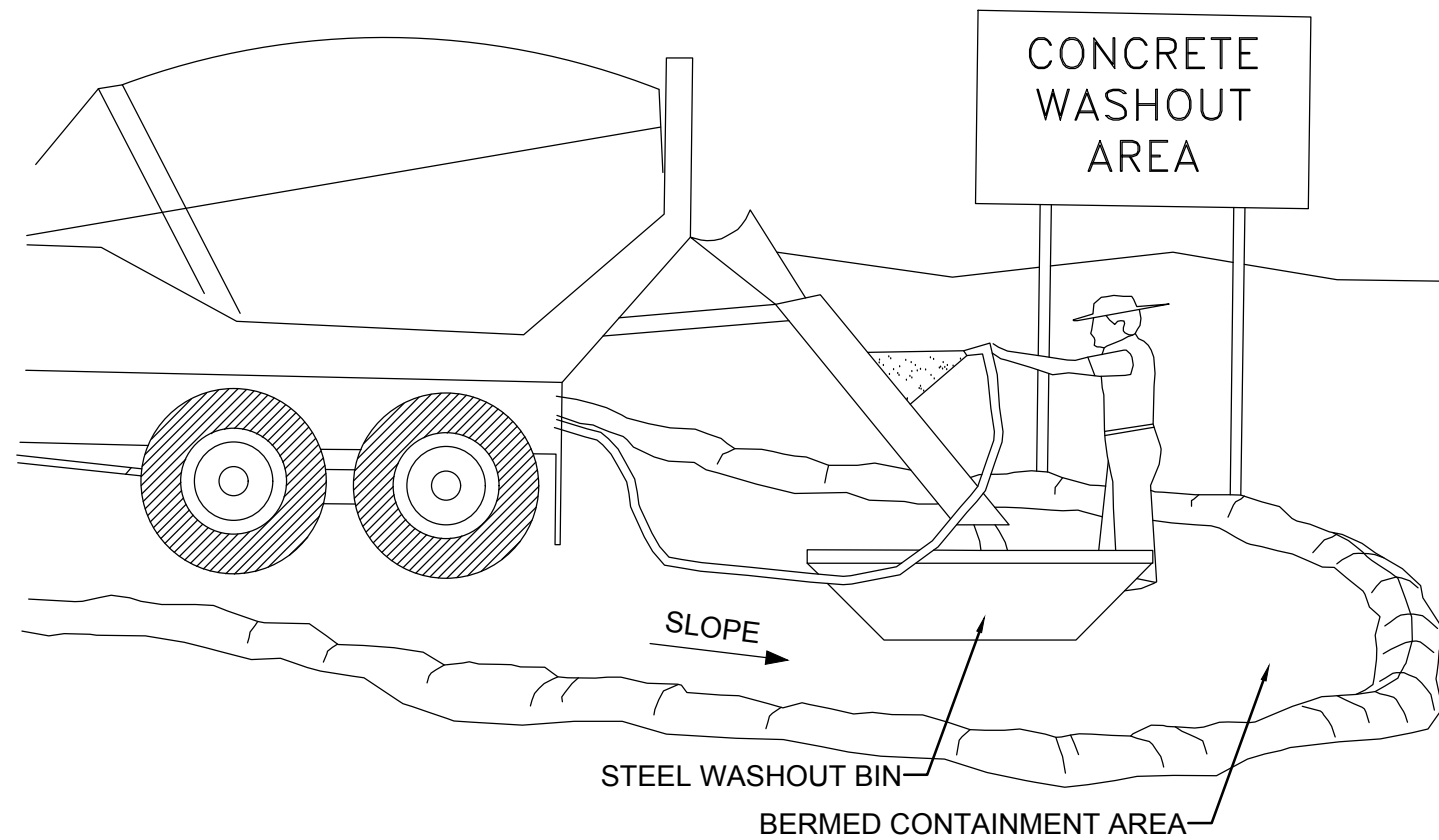


**NOTES:**

1. EXCESS AND WASTE CONCRETE SHALL BE DISPOSED OF OFF SITE OR AT DESIGNATED AREAS ONLY.
2. EXCESS AND WASTE CONCRETE SHALL NOT BE WASHED INTO THE STREET OR INTO A DRAINAGE SYSTEM.
3. FOR WASHOUT OF CONCRETE AND MORTAR PRODUCTS ONSITE, A DESIGNATED CONTAINMENT FACILITY OF SUFFICIENT CAPACITY TO RETAIN LIQUID AND SOLID WASTE SHALL BE PROVIDED.
4. ONSITE CONCRETE WASHOUT CONTAINMENT FACILITY SHALL BE A STEEL BIN OR APPROVED ALTERNATE.
5. SLURRY FROM CONCRETE AND ASPHALT SAW CUTTING SHALL BE VACUUMED OR CONTAINED, DRIED, PICKED UP AND DISPOSED OF PROPERLY.

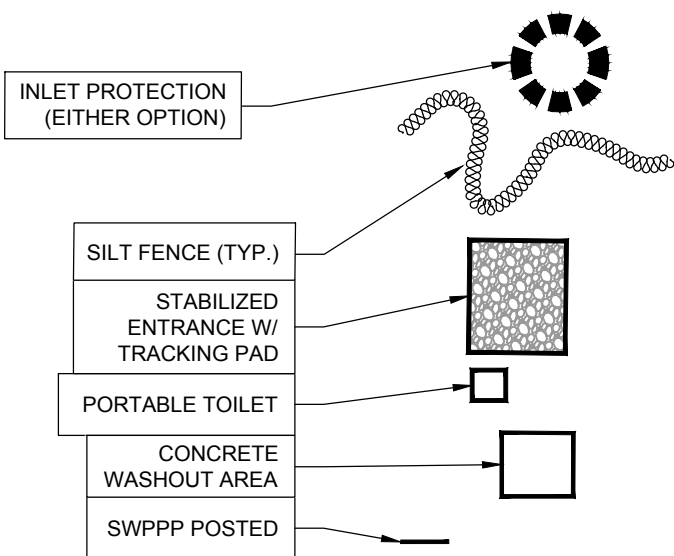


1B INLET PROTECTION - OPTION 2

Scale: NTS

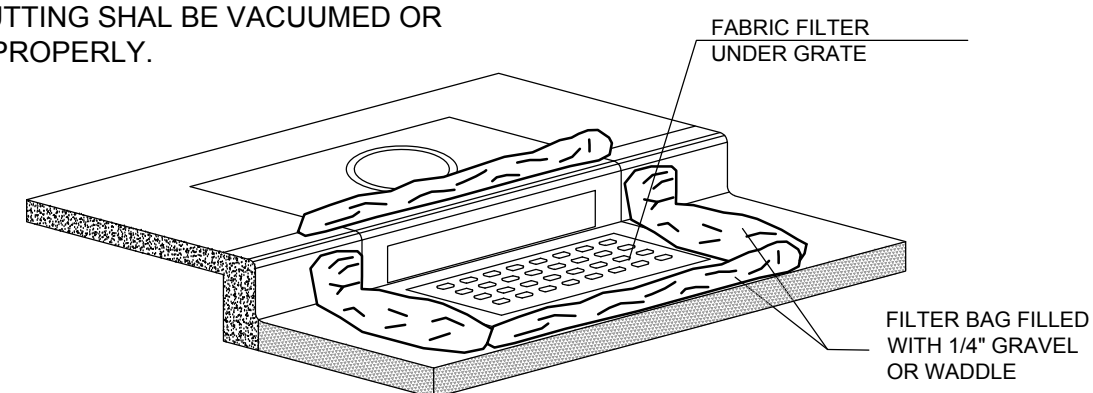


**INSTALLATION NOTES**

1. PLACEMENT: PLACE CG TIGHTLY AGAINST CURB OPENING AND COVER ENTIRE GRATE. CG SHOULD EXTEND AT LEAST 2 INCHES PAST GRATE TOWARDS STREET.
2. OVERLAP FOR LONG OPENINGS: OVERLAP CG UNITS AT LONGER OPENINGS.
3. ANCHOR: ANCHOR CG SO THAT WATER CANNOT FLOW BEHIND IT.
4. ALTERNATE ANCHOR METHODS: A) INSTALL GRAVEL BAGS AT EACH SIDE OF CG - HALF-ON AND HALF-OFF THE EDGES. USE HALF-FILLED GRAVEL BAGS (15 OR 20 LBS). ROUND ROCK IS RECOMMENDED. OR B) ATTACH WITH 16 GAUGE TIE-WIRE. CUT WIRE TO 18" LENGTH. AT EACH CORNER OF CG, FEED ONE END OF WIRE DOWN THROUGH CG, AROUND GRATE BAR, AND BACK UP THRU CG. ABOVE GROUND, TWIST WIRES SEVERAL TIMES, CUT-OFF EXCESS. OR C) FASTEN WITH CONCRETE ANCHORS/NAILS AT THE OUTSIDE EDGES OF CG.

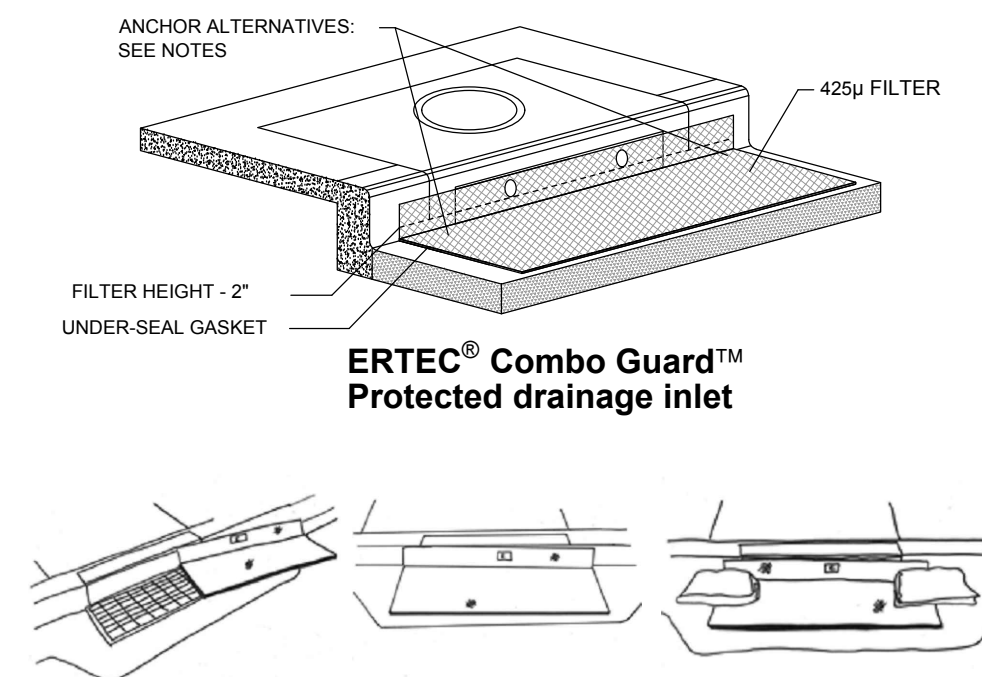


1A INLET PROTECTION - OPTION 1

Scale: NTS

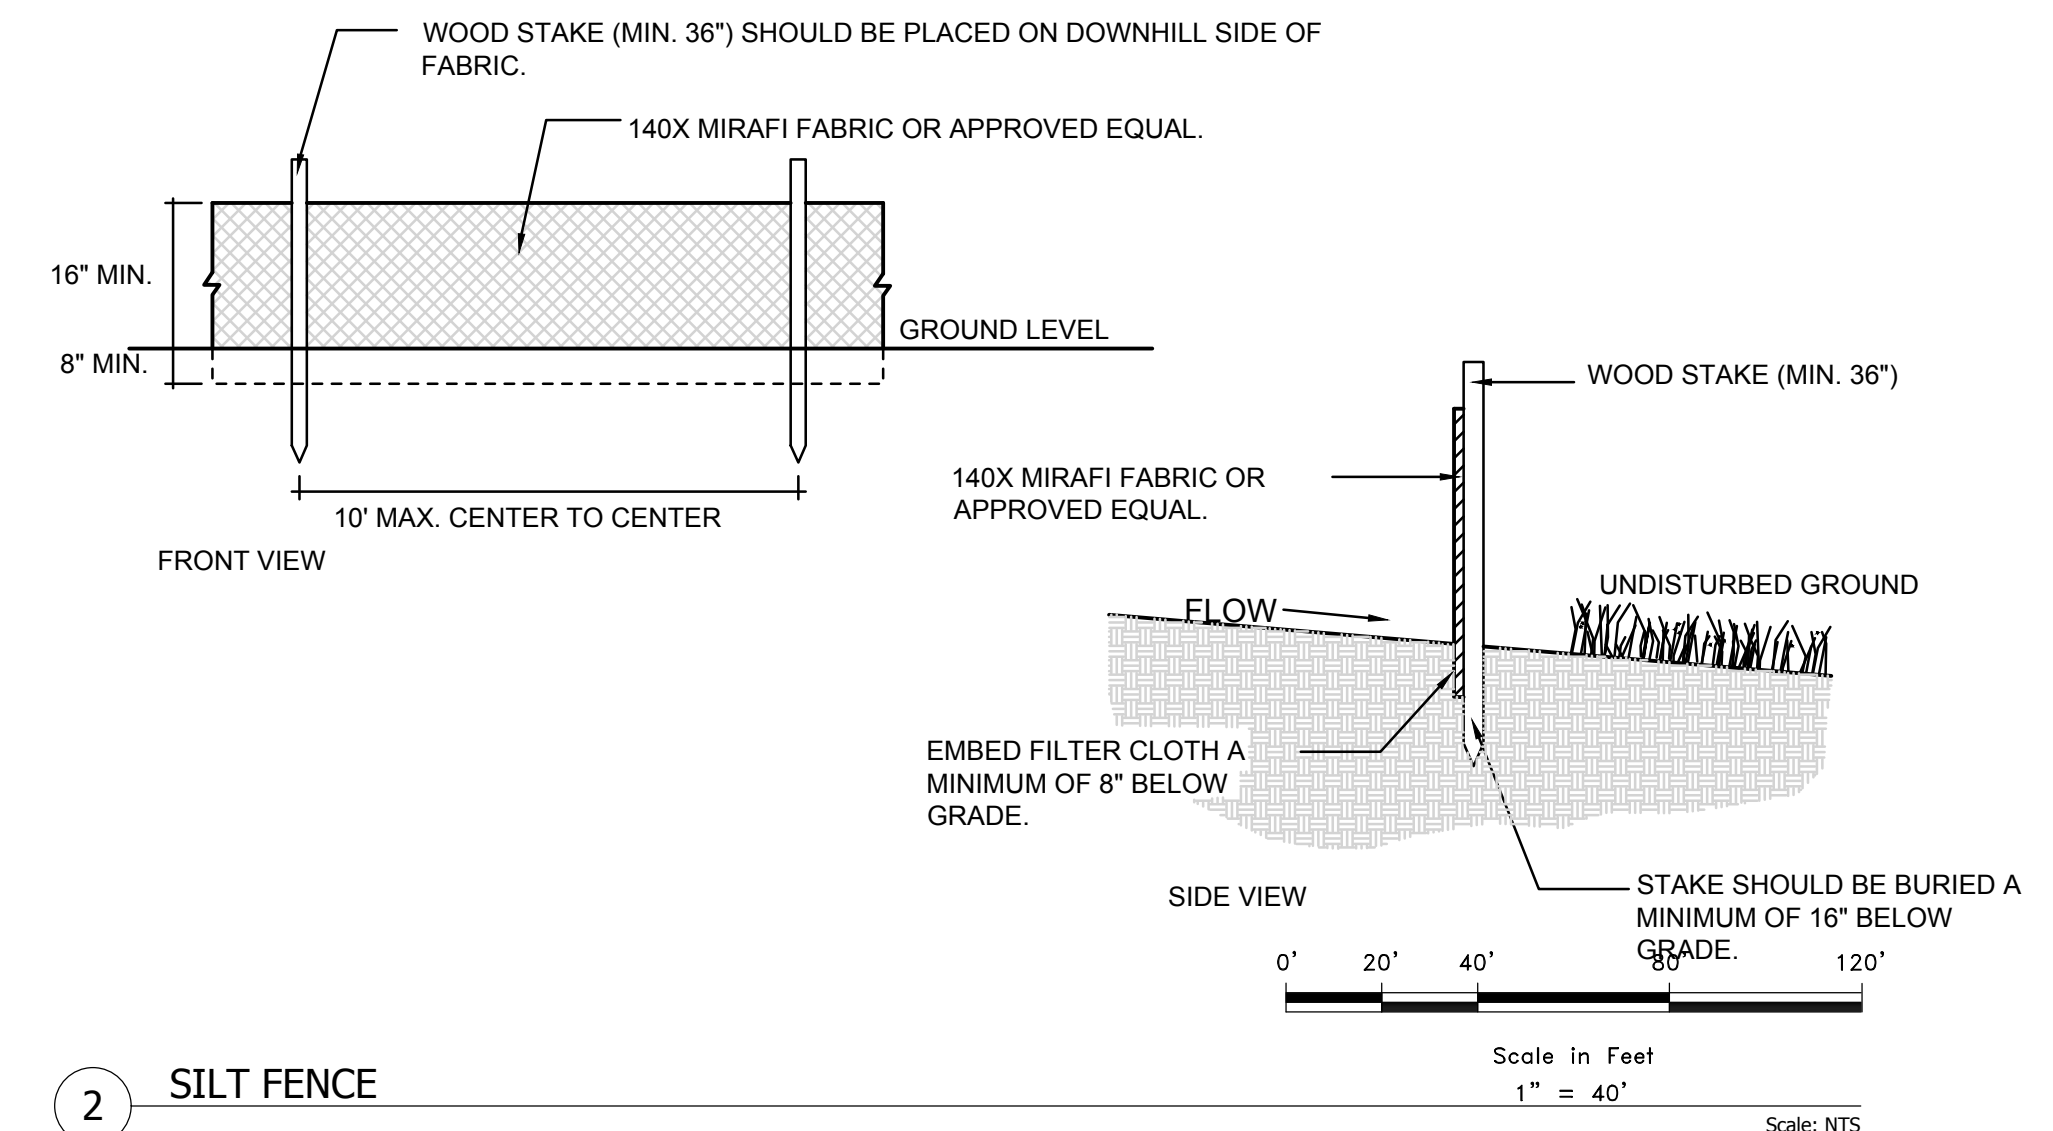

2 SILT FENCE

Scale: NTS

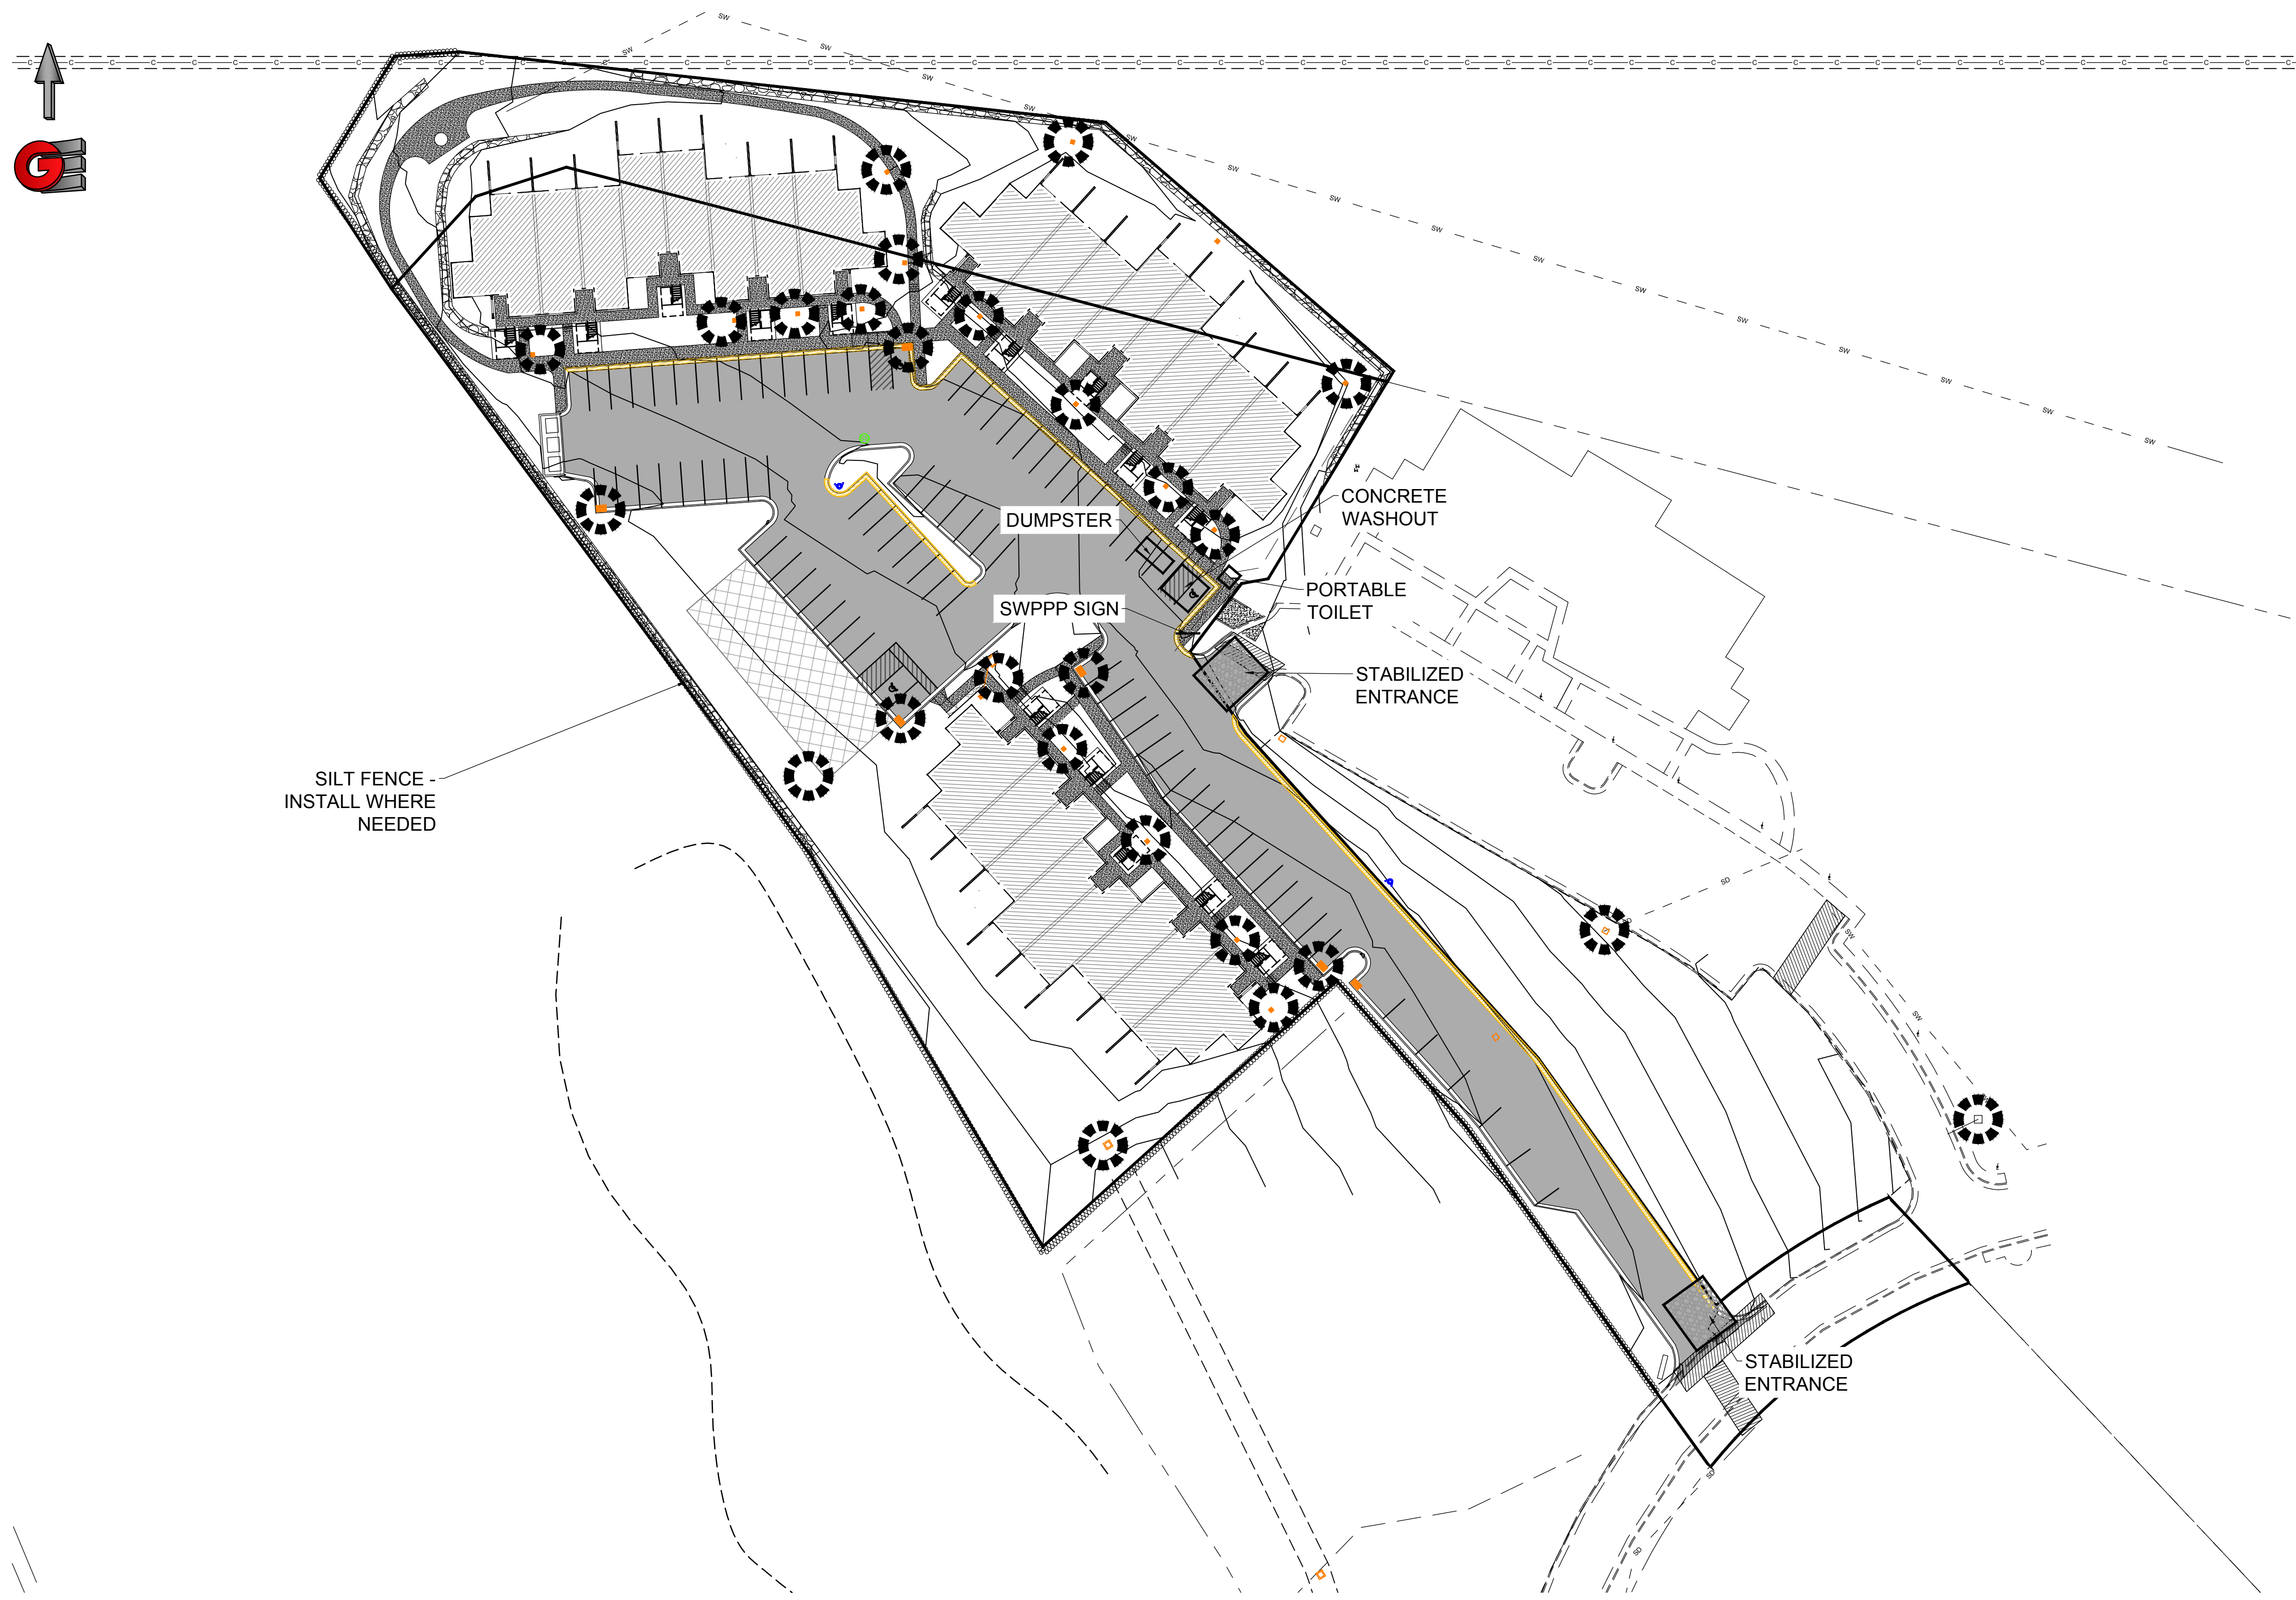


SCALE	1" = 40'
DATE	9-10-21
DESIGN	LZ
DRAWN	LZ
CHECKED	PC
REVISIONS	DESCRIPTION
DATE	REVISED DETENTION/SD
10-9-2021	
DWG: 21-1301 - LWS-ROCKEY-102-THE-POINTE-CONSTRUCTION-SET-REV-11093.DWG	

SWPPP  
 THE POINTE - CONSTRUCTION SET  
 3718 WOLF CREEK DR  
 EDEN, WEBER COUNTY, UTAH

**GARDNER ENGINEERING**  
 CIVIL - LAND PLANNING  
 MUNICIPAL - LAND SURVEYING  
 5150 SOUTH 375 EAST OGDEN, UT  
 OFFICE: 801-476-0202 FAX: 801-476-0066

CE1-04




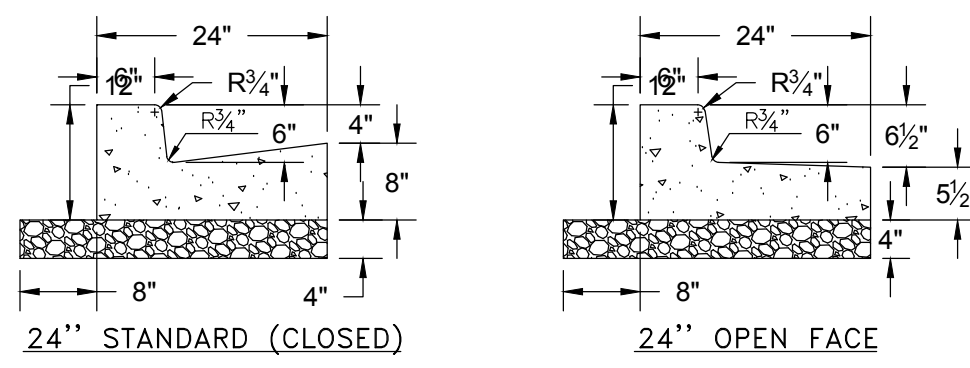


**TYPICAL 24' CURB AND GUTTER**  
NOT TO SCALE

- CURB AND GUTTER CONSTRUCTION NOTES:
- OPEN FACE GUTTER SHALL BE CONSTRUCTED WHERE DRAINAGE IS DIRECTED AWAY FROM CURB.
  - OPEN FACE CURB & GUTTER LOCATIONS ARE INDICATED BY HATCHING AND NOTES ON THE GRADING PLAN.
  - IT IS THE RESPONSIBILITY OF THE SURVEYOR TO ADJUST TOP OF CURB GRADES AT THE TIME OF CONSTRUCTION STAKING.
  - REFER TO THE TYPICAL DETAILS FOR STANDARD (CLOSED) AND OPEN FACE CURB AND GUTTER FOR DIMENSIONS.
  - TRANSITIONS BETWEEN OPEN FACE AND STANDARD (CLOSED) CURB AND GUTTER ARE TO BE SMOOTH. HAND FORM THESE AREAS IF NECESSARY.


**1 TYPICAL 24' CURB AND GUTTER**  
Scale: NTS

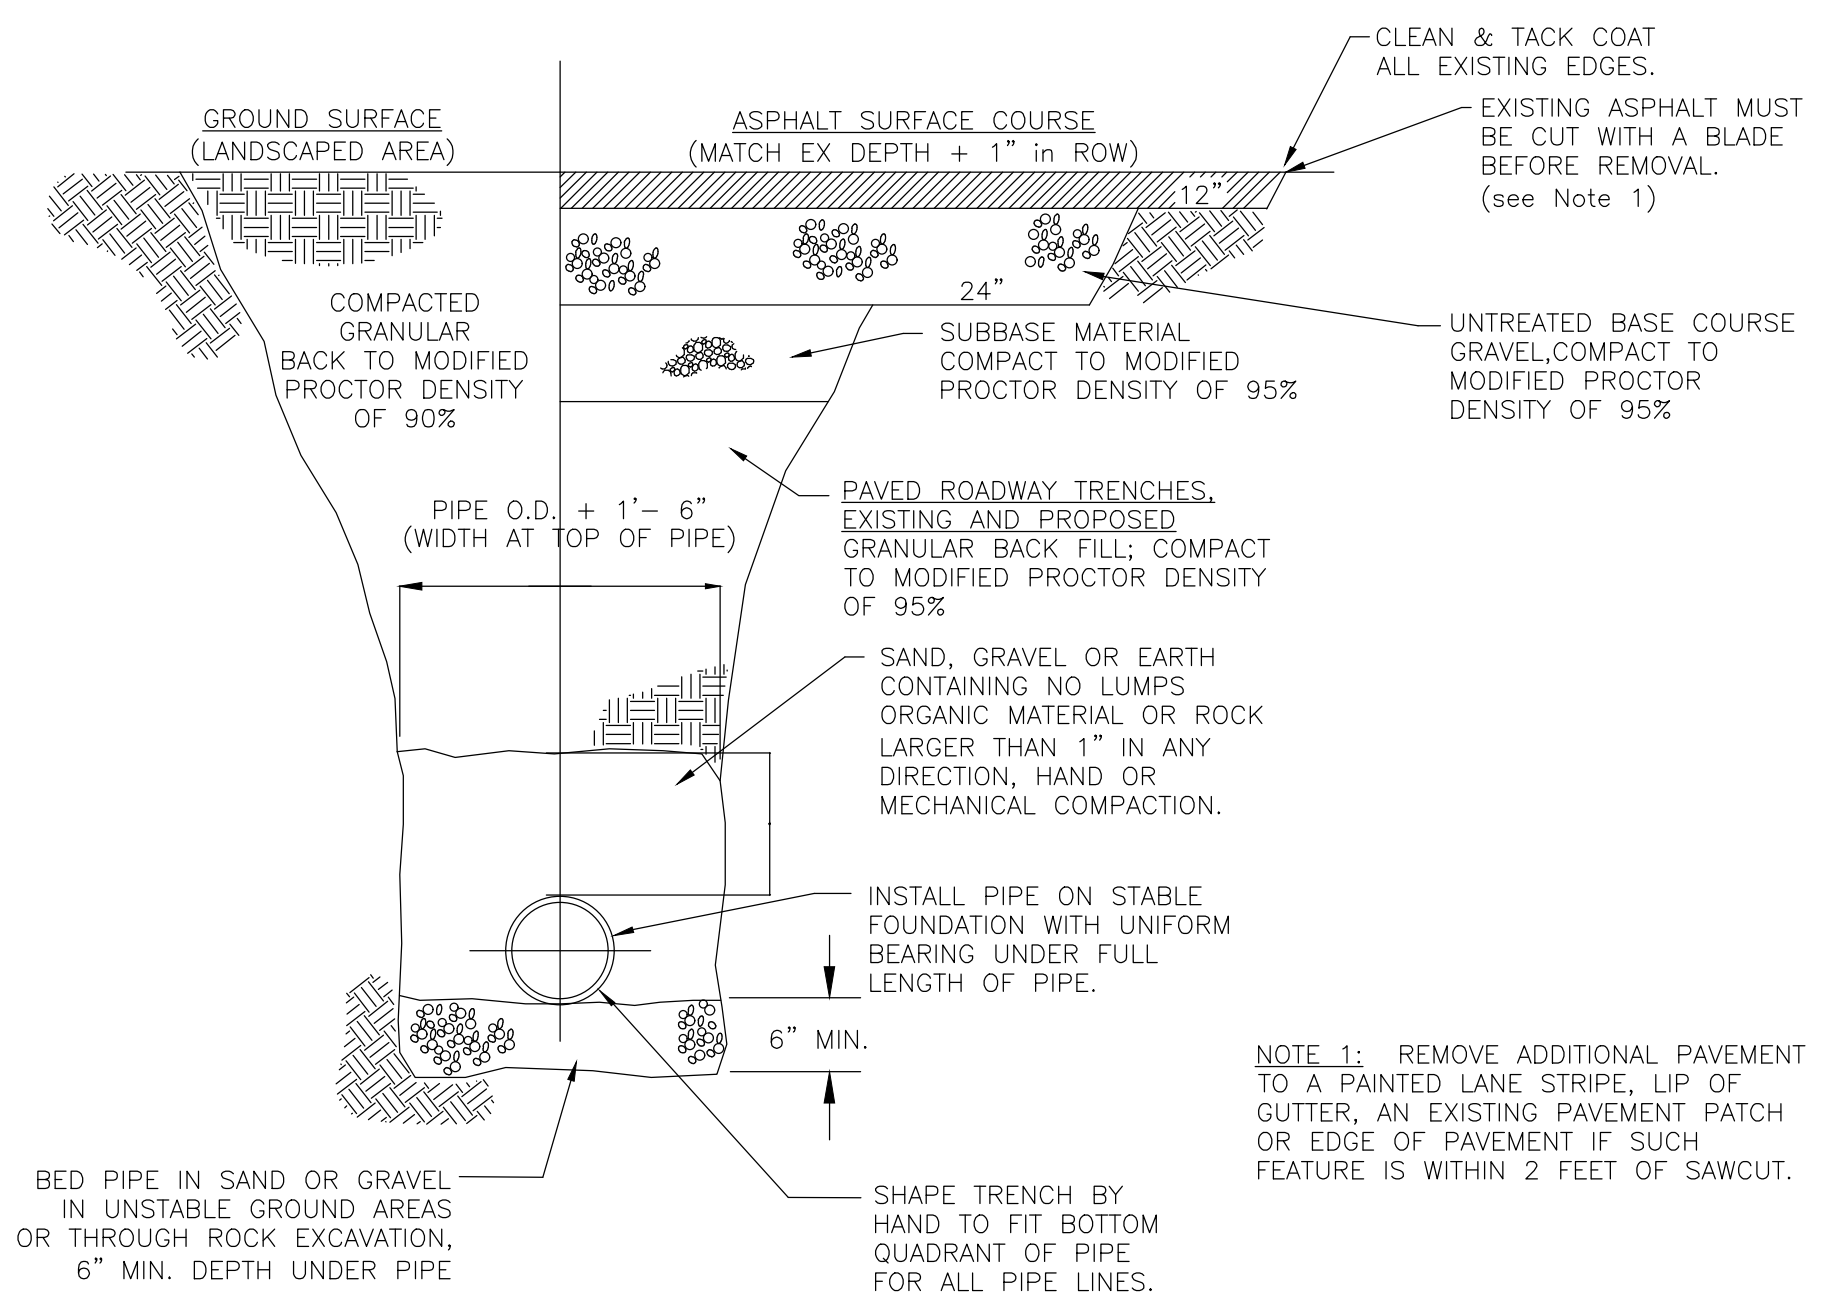

**2 TYPICAL TRENCH SECTION**  
Scale: NTS

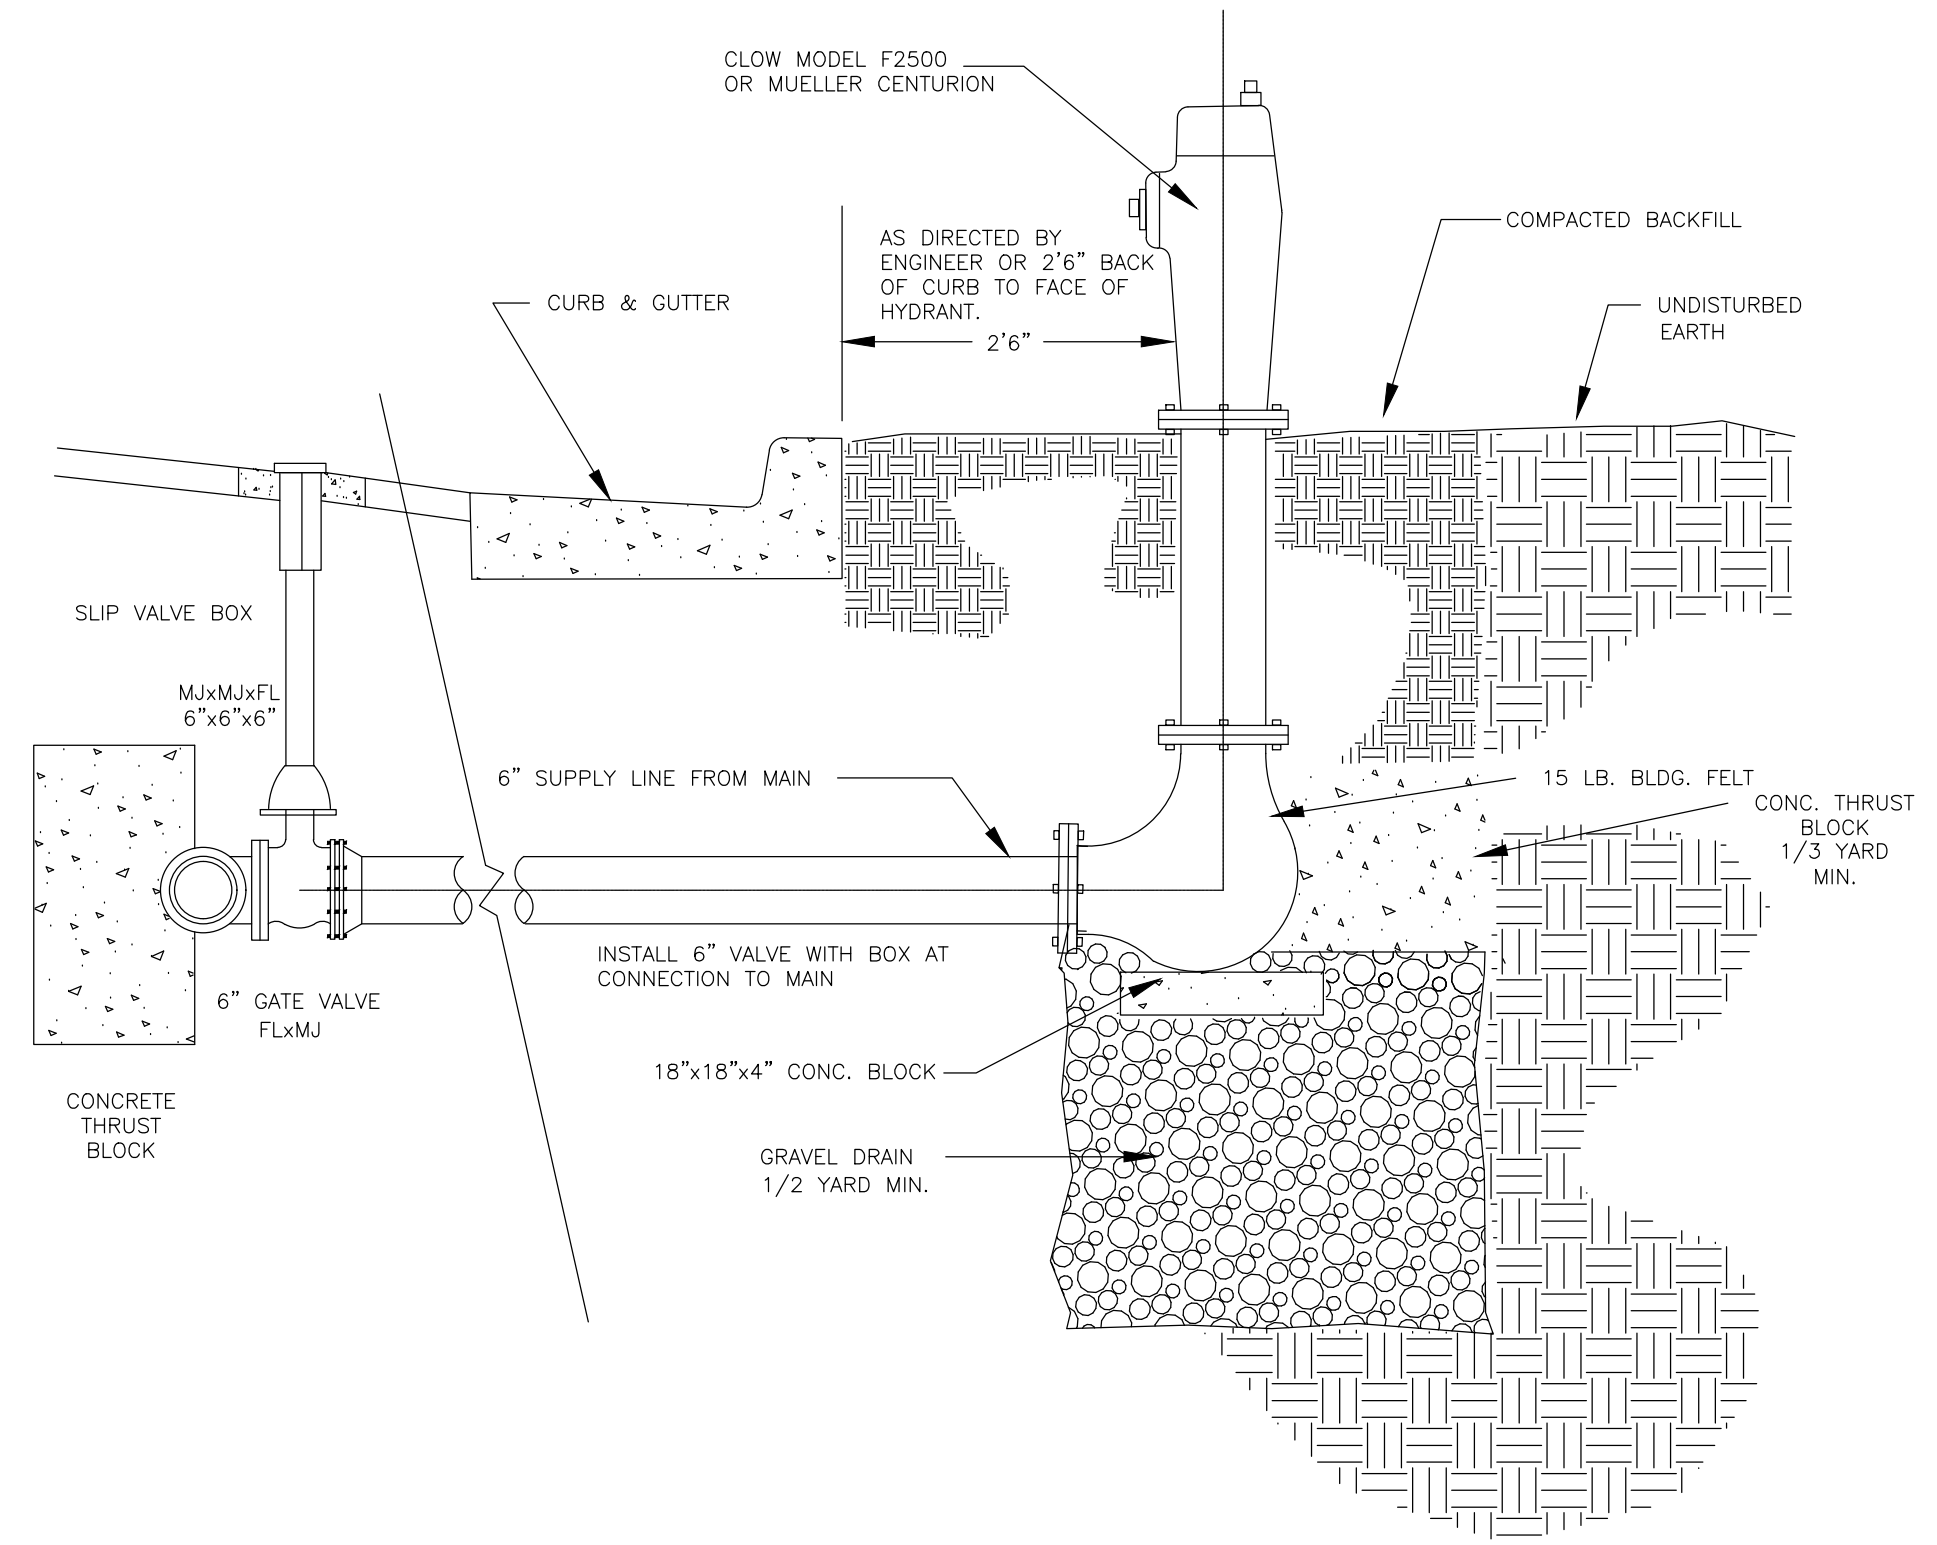

**3 TYPICAL WATER HYDRANT INSTALLATION DETAIL**  
Scale: NTS

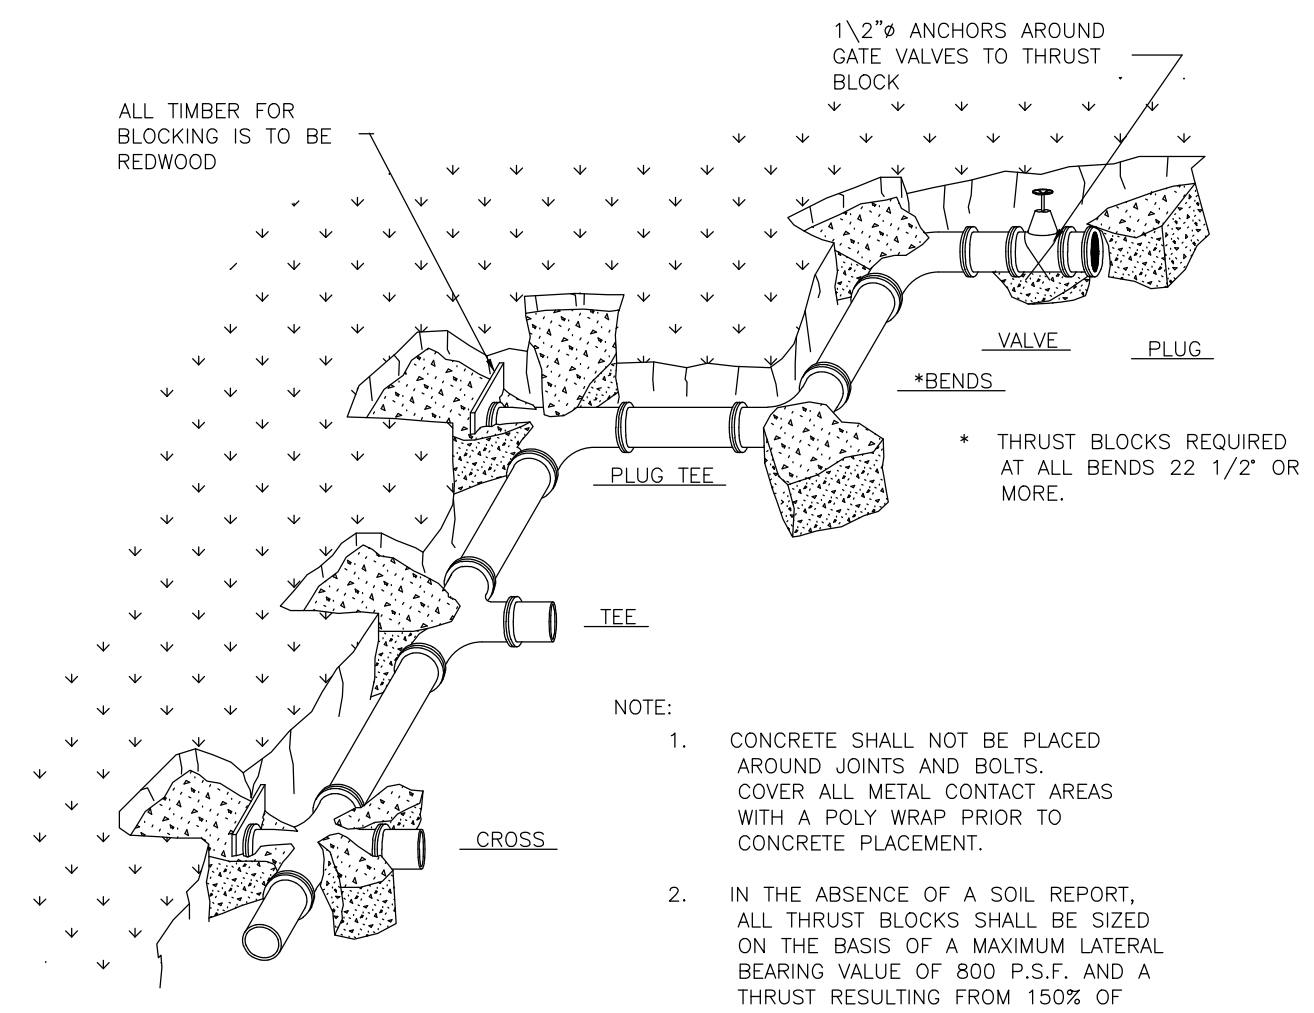

**4 TYPICAL THRUST BLOCK DETAIL**  
APPLIES TO ALL PRESSURE PIPE  
Scale: NTS

TABLE OF BEARING AREAS IN SQ. FT FOR CONCRETE THRUST BLOCKING


SIZE	BENDS				TEES	GATE VALVES	DEAD ENDS	CROSS BRANCH PLUGGED	CROSSW / 2 BRAN. PLUGGED
	90°	45°	22 1/2°	11 1/4°					
3	1.0	0.0	0.3	0	0.7	0.5	0.7	0.7	0.7
4	1.8	1.0	0.5	0	1.3	0.5	1.3	1.3	1.3
6	4.0	2.2	1.1	0	2.8	0.7	2.8	2.8	2.8
8	7.1	3.8	2.0	1.0	5.0	2.4	5.0	5.0	5.0
10	11.1	6.0	3.0	1.5	7.8	4.5	7.8	7.8	7.8
12	16.0	8.6	4.4	2.2	11.3	7.3	11.3	11.3	11.3
14	21.7	11.8	6.0	3.0	15.4	11.0	15.4	15.4	15.4
15	25.0	13.5	7.0	3.5	17.6	12.6	17.6	17.6	17.6
16	28.4	15.3	8.0	4.0	20.0	14.0	20.0	20.0	20.0
18	36.0	19.4	10.0	5.0	25.4	17.6	25.4	25.4	25.4
20	44.2	24.0	12.2	6.1	31.4	21.6	31.4	31.4	31.4
21	49.0	26.5	13.5	6.8	34.6	23.6	34.6	34.6	34.6
22	54.0	29.0	14.8	7.4	38.0	26.0	38.0	38.0	38.0
24	64.0	34.5	17.7	8.8	45.0	31.0	45.0	45.0	45.0
30	100.0	54.0	27.6	13.8	71.0	50.0	71.0	71.0	71.0
36	144.0	78.0	40.0	20.0	102.0	70.0	102.0	102.0	102.0

ALL VALVES, TEES, CROSSES AND BENDS GREATER THAN 22.5" SHALL ALSO BE FITTED WITH MECHANICAL RESTRAINTS, SUCH AS MEGA LUGS OR APPROVED EQUAL.


AREAS GIVEN IN TABLE ARE BASED UPON AN INTERNAL STATIC PRESSURE OF 100 P.S.I AND A SOIL BEARING CAPACITY OF 1000 LBS PER SQ. FT. BEARING AREAS FOR ANY PRESSURE AND SOIL BEARING CAPACITY MAY BE OBTAINED BY MULTIPLYING THE TABULATED VALUES BY A CORRECTION FACTOR "F".

$F = \frac{\text{ACTUAL SPECIFIED TEST PRESSURE IN HUNDREDS OF LBS/SQ. IN.}}{\text{ACTUAL SOIL BEARING CAPACITY IN THOUSANDS OF LBS.}}$


EXAMPLE: TO FIND BEARING AREA FOR 8"-90° BEND WITH A STATIC INTERNAL PRESSURE OF 1500 P.S.I AND WITH A SOIL BEARING CAPACITY OF 3000 LBS. PER SQ. FT.  
 $F = 1.5 / 3 = 0.5$  TABULATED VALUE = 7.1 SQ. FT.  
 $0.5 \times 7.1 = 3.56 \approx 4$  SQ. FT. (~OR 2FT. LONG BY 2FT. HIGH.)

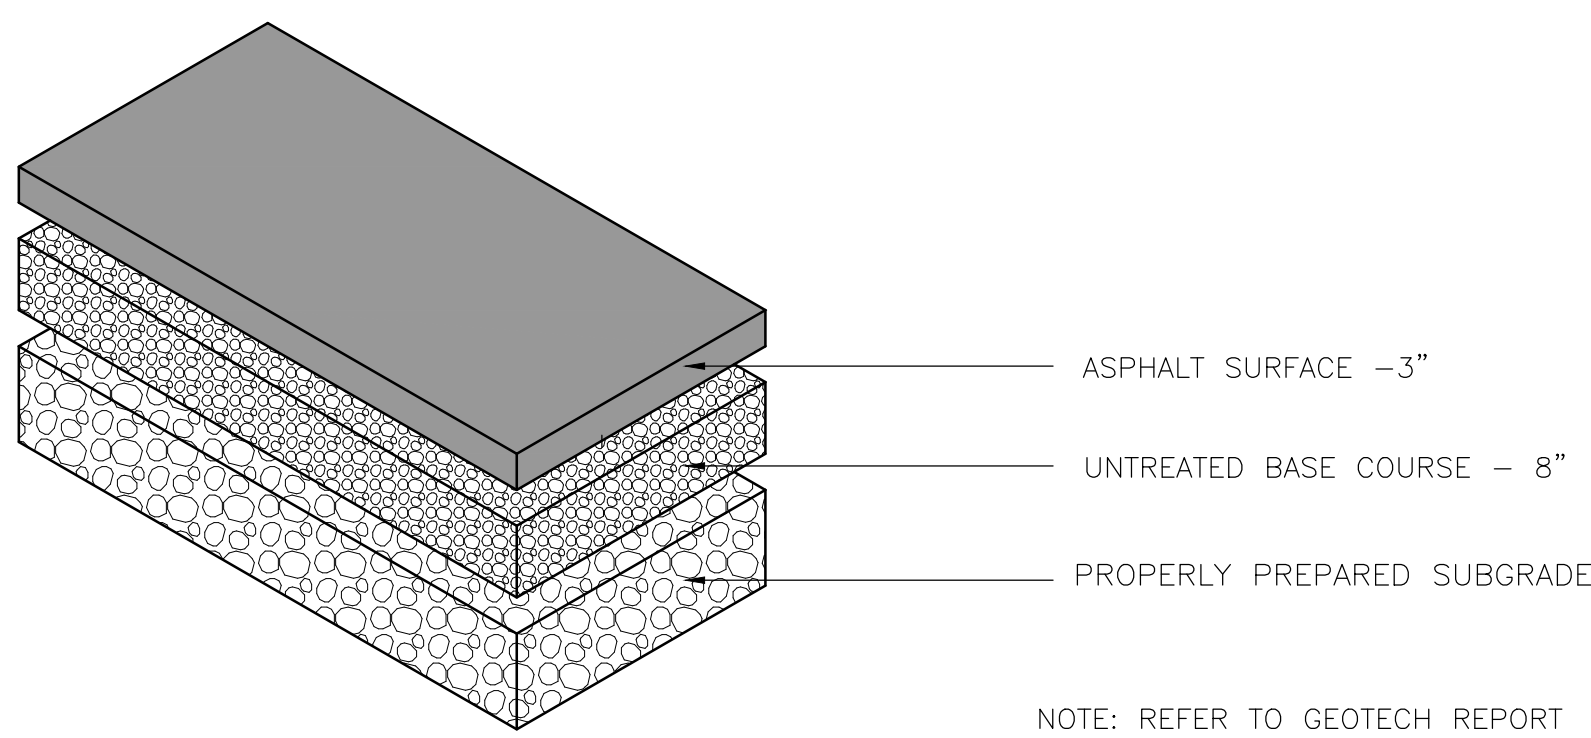


**7 TYPICAL REGULAR ASPHALT PAVING**  
Scale: NTS

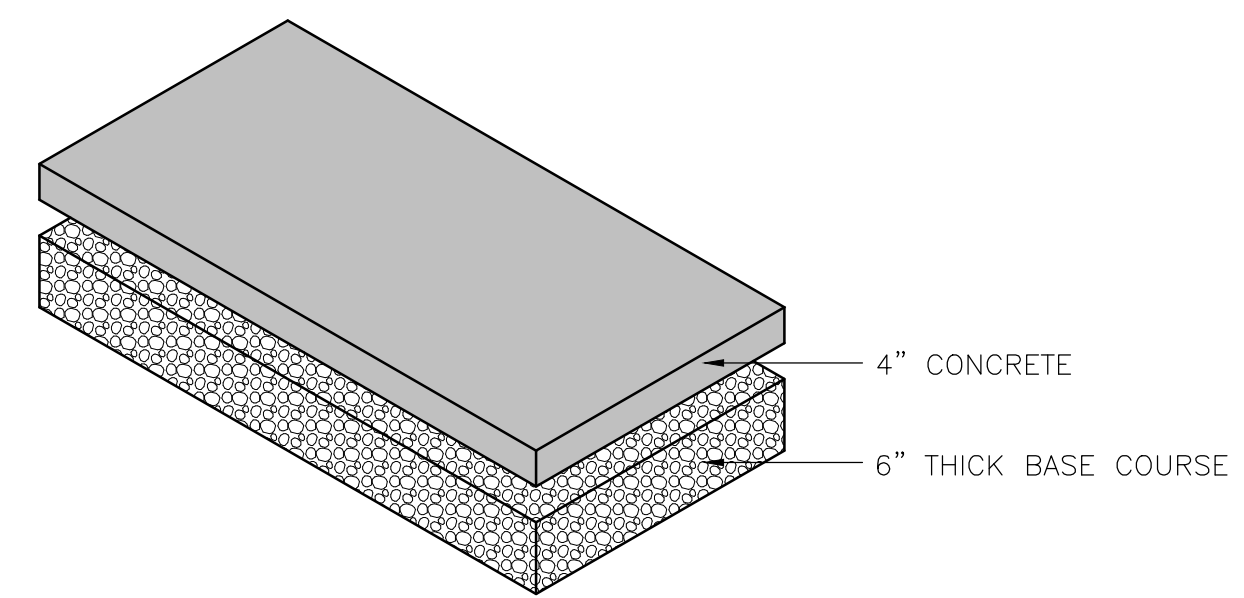

**6 CONCRETE SIDEWALK SECTION**  
Scale: NTS

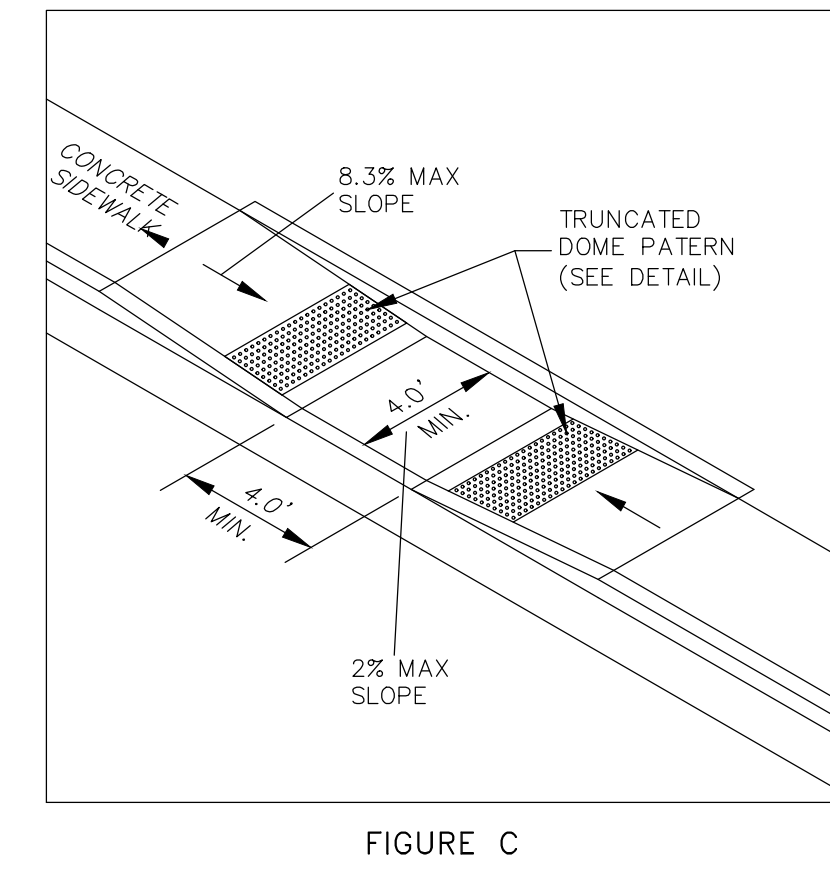

**5 TYPICAL ADA RAMP**  
Scale: NTS

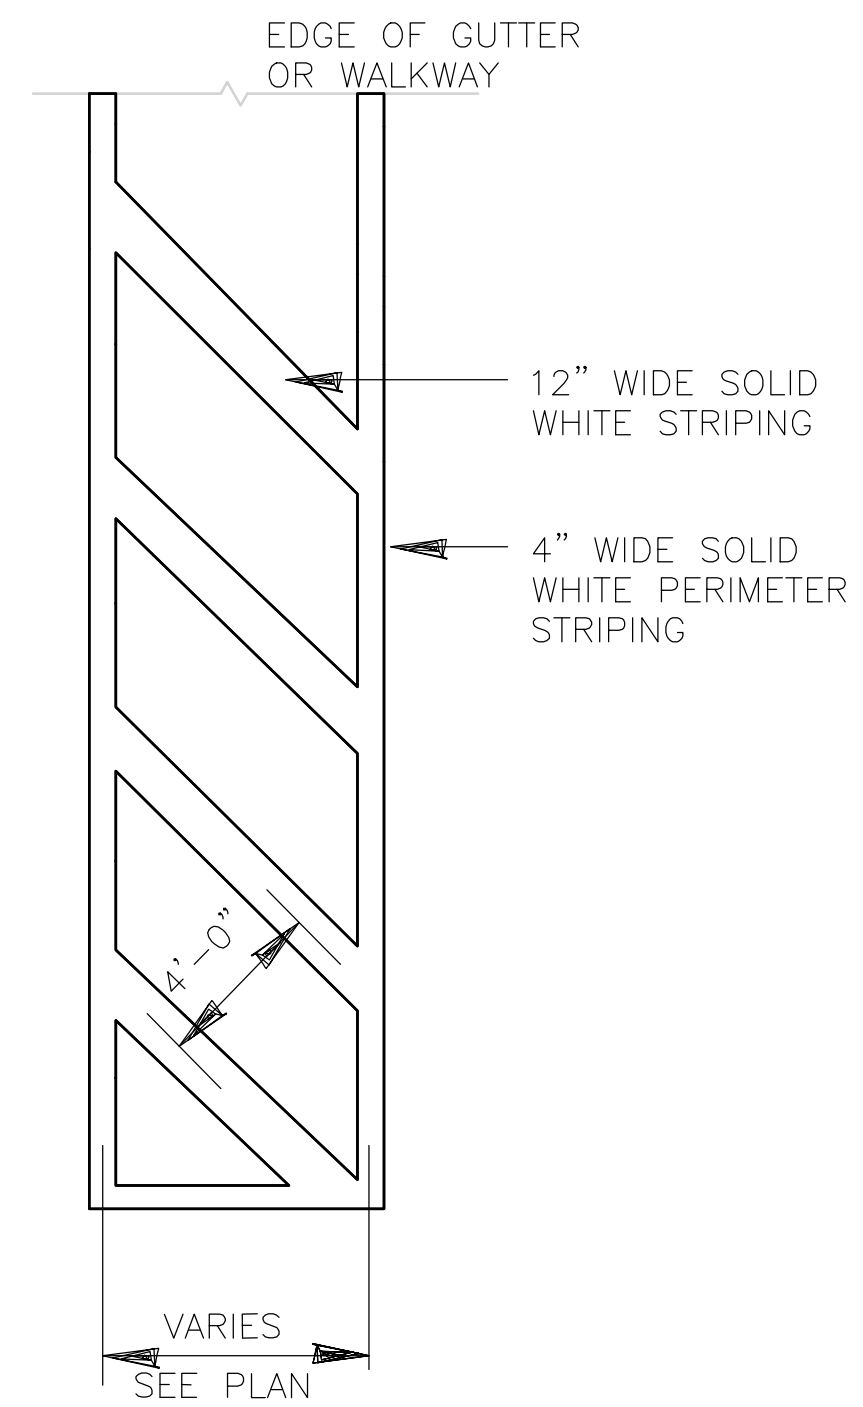

**8 TYPICAL "NO PARING" STRIPING**  
Scale: NTS

SCALE: NTS  
DATE: 9-10-21  
DESIGN: LZ  
DRAWN: LZ  
CHECKED: RC

REVISIONS





DATE	DESCRIPTION
10-9-2021	REVISED DETENTION/S/D

DWG: 181101 - THE POINTE - CONSTRUCTION SET REV 11/09/21.DWG

STANDARD DETAILS  
THE POINTE - CONSTRUCTION SET  
3718 WOLF CREEK DR  
EDEN, WEBER COUNTY, UTAH



**GARDNER ENGINEERING**  
CIVIL - LAND PLANNING  
MUNICIPAL - LAND SURVEYING  
5150 SOUTH 375 EAST OGDEN, UT  
OFFICE: 801-476-0202 FAX: 801-476-0066



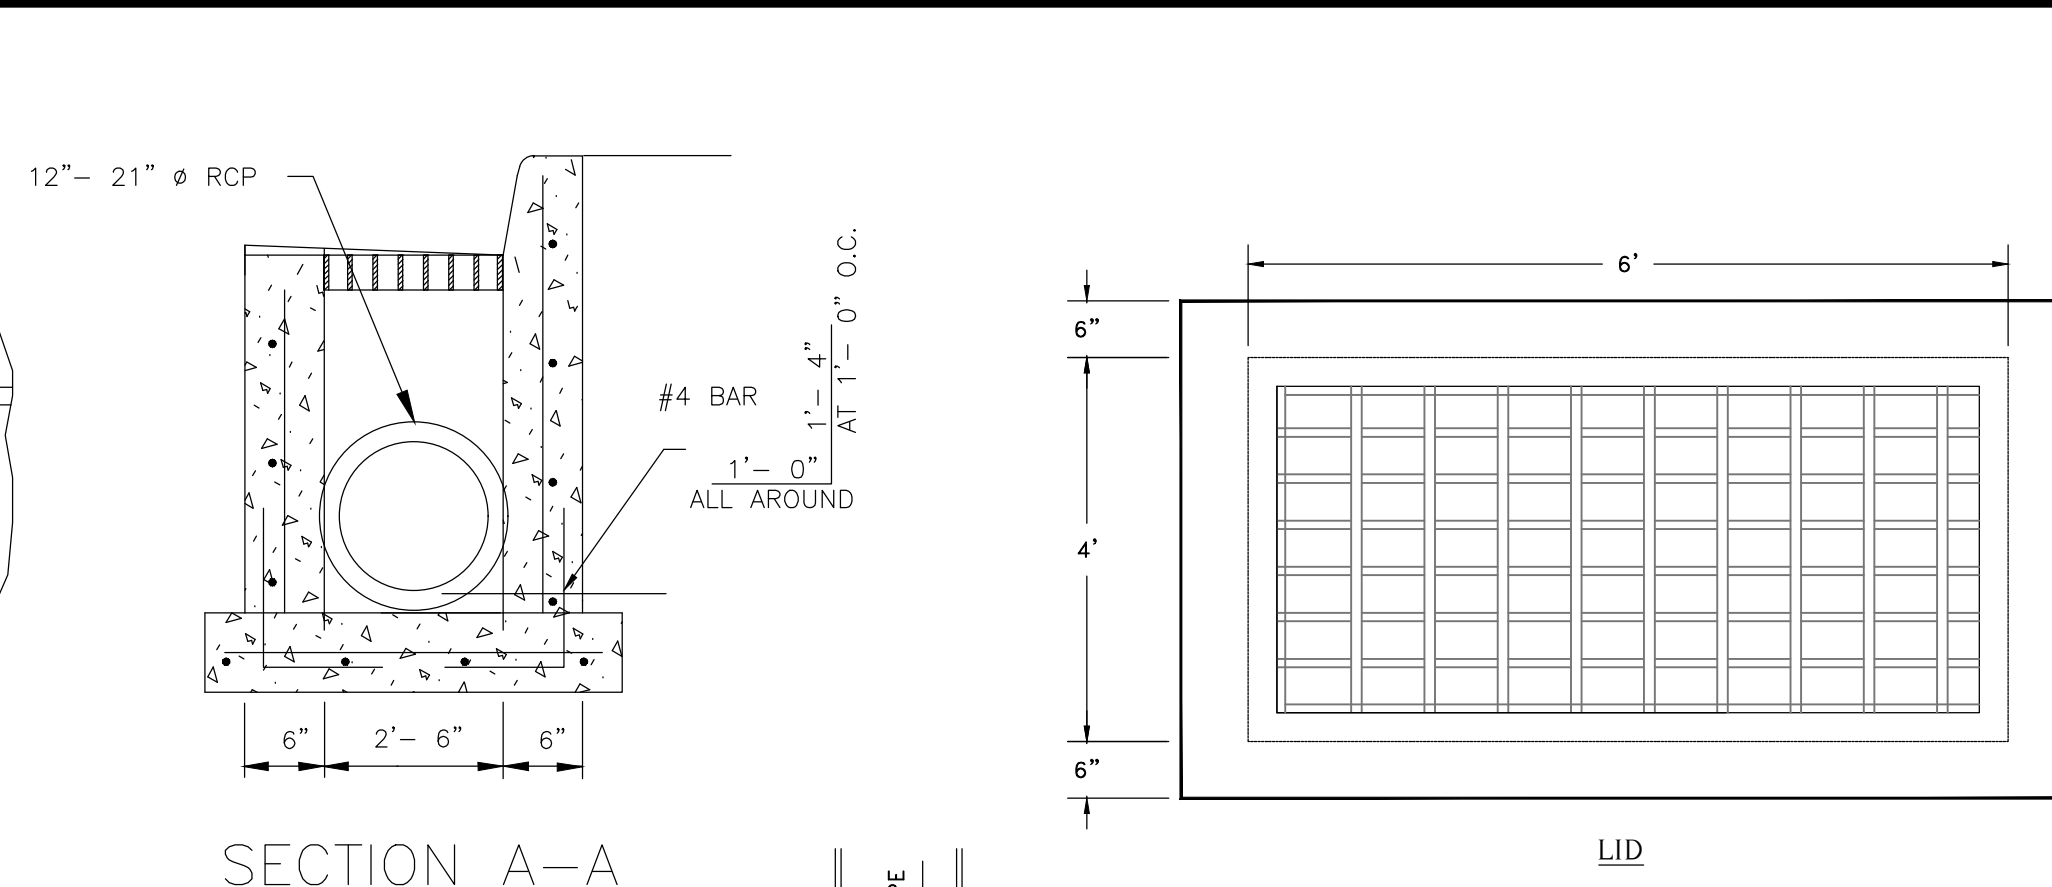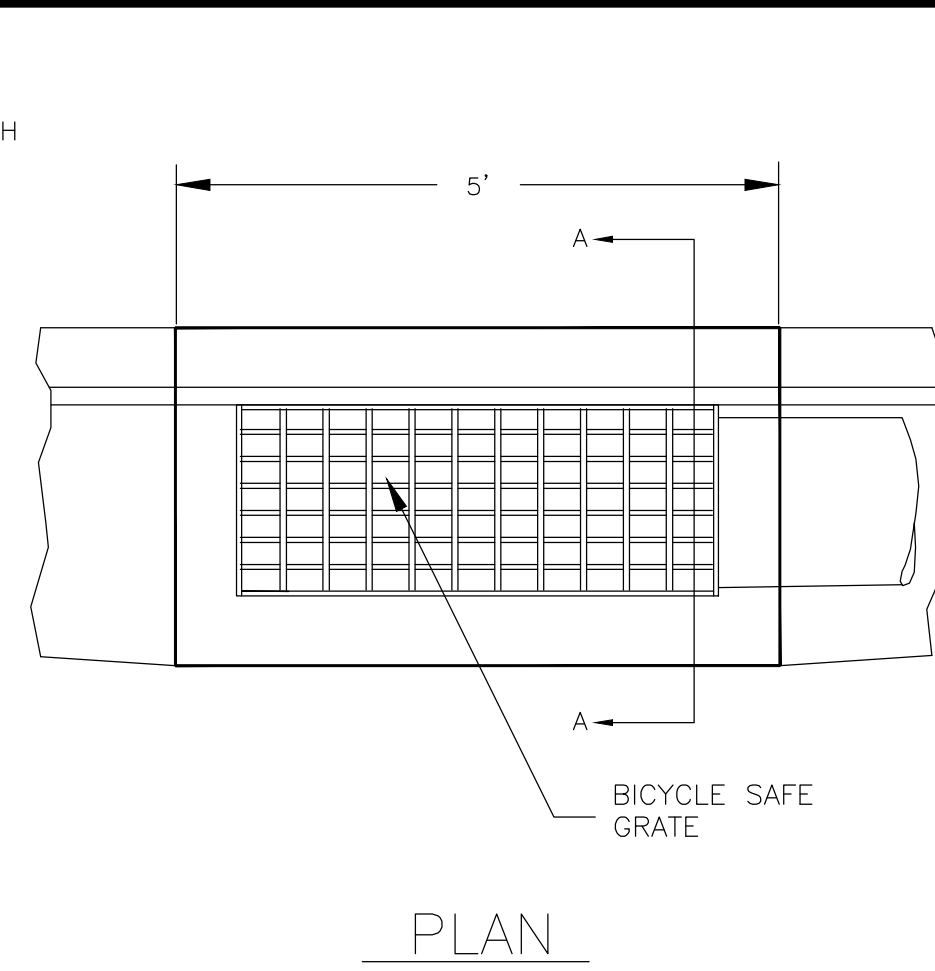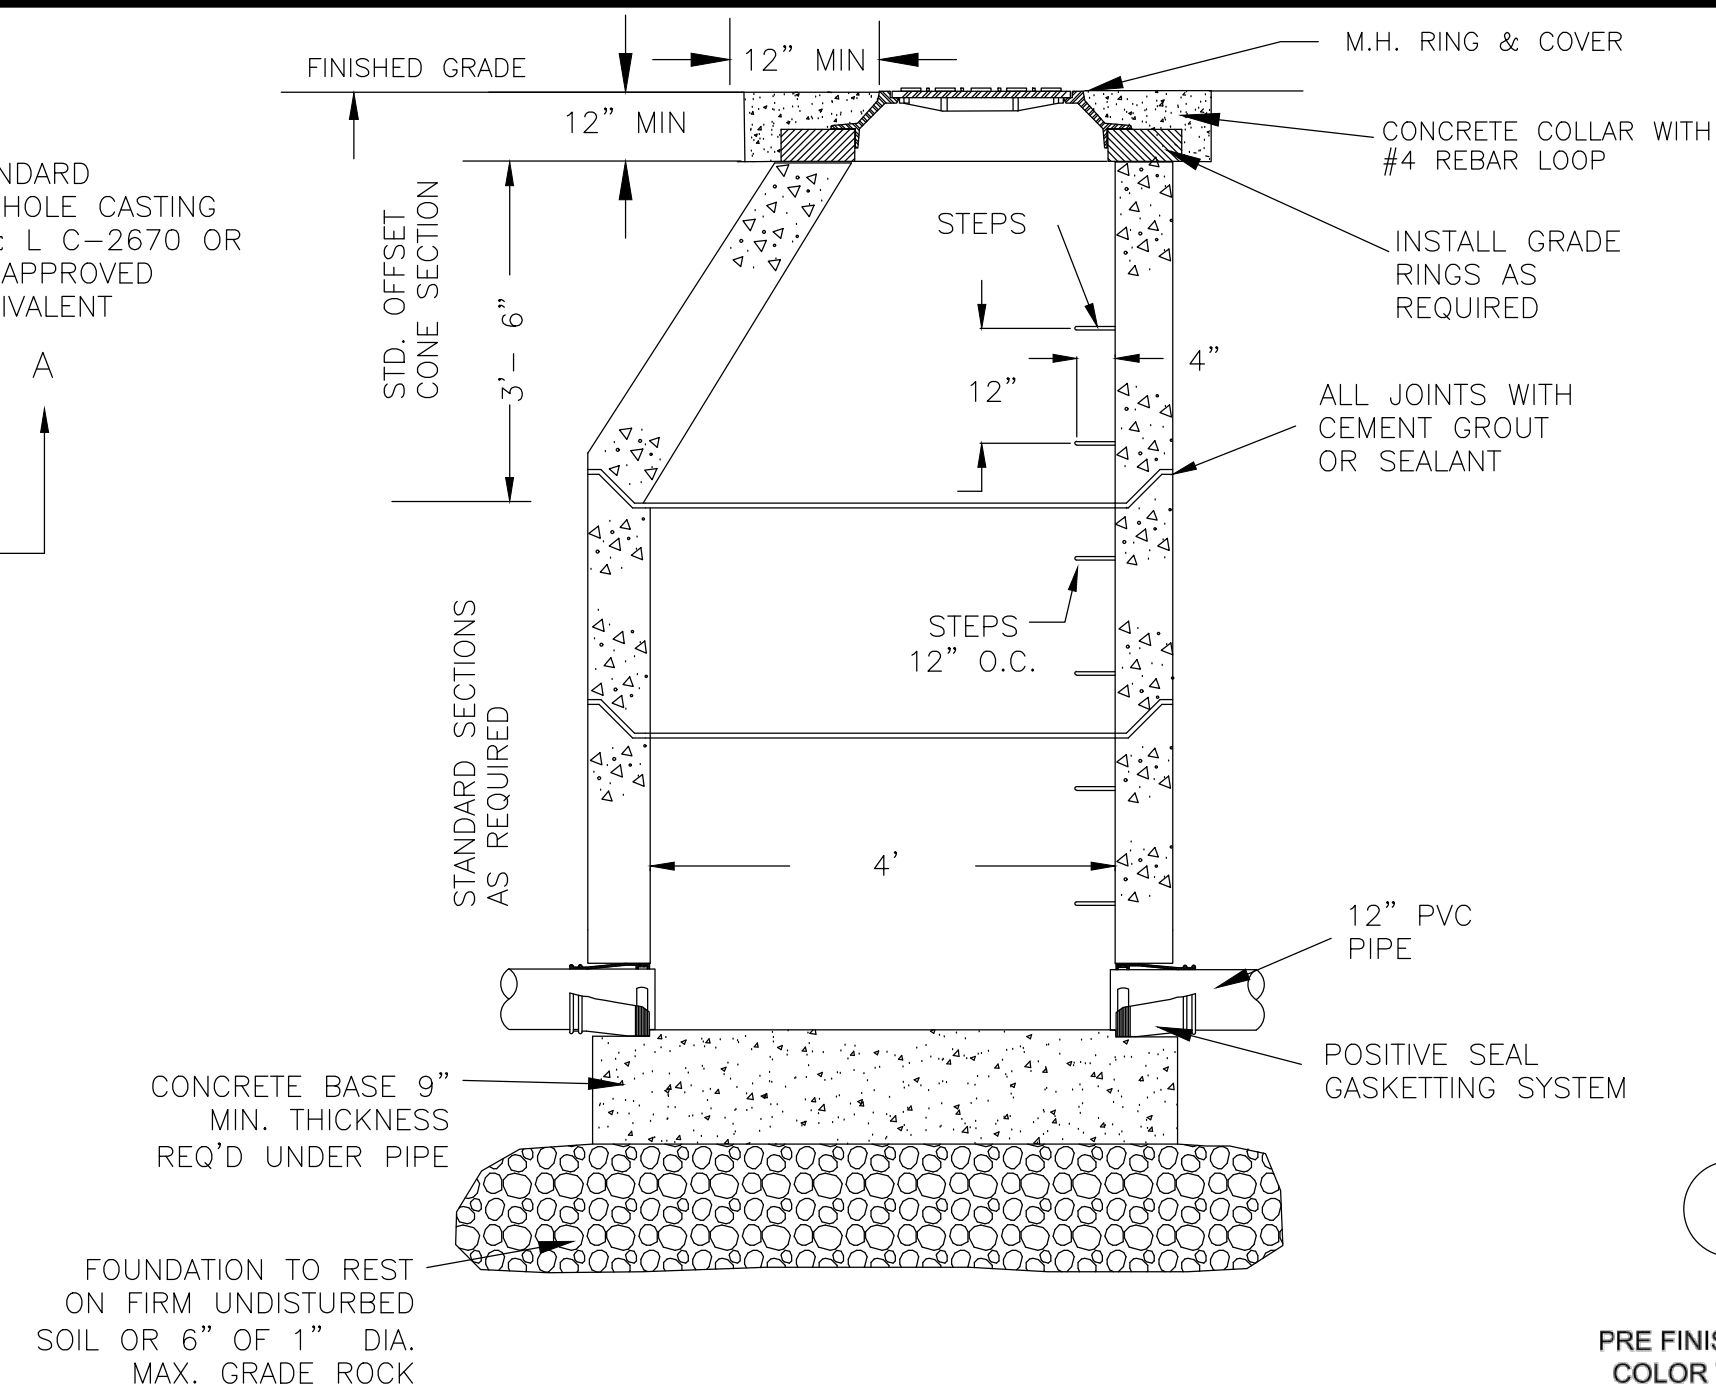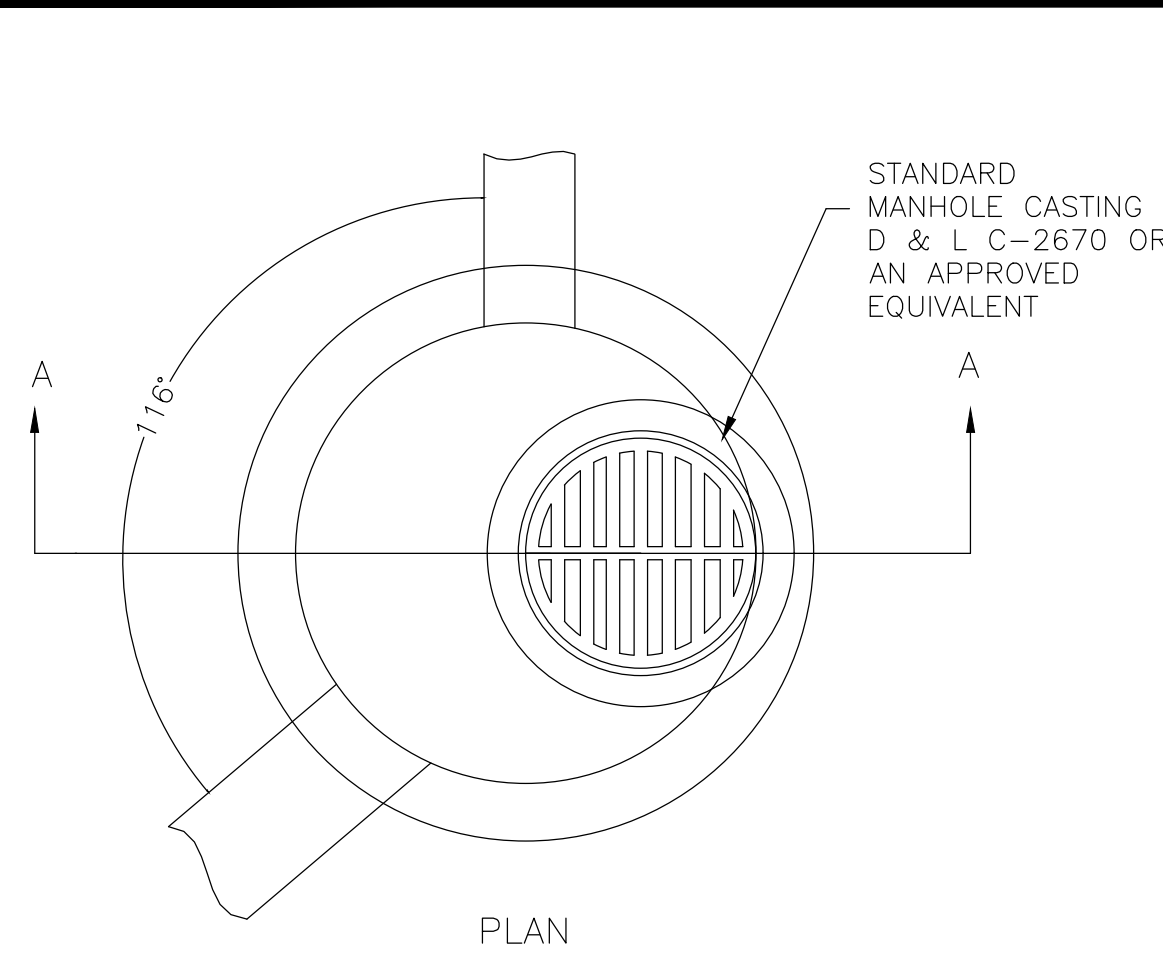

8 TYPICAL MANHOLE DETAIL

Scale: NTS

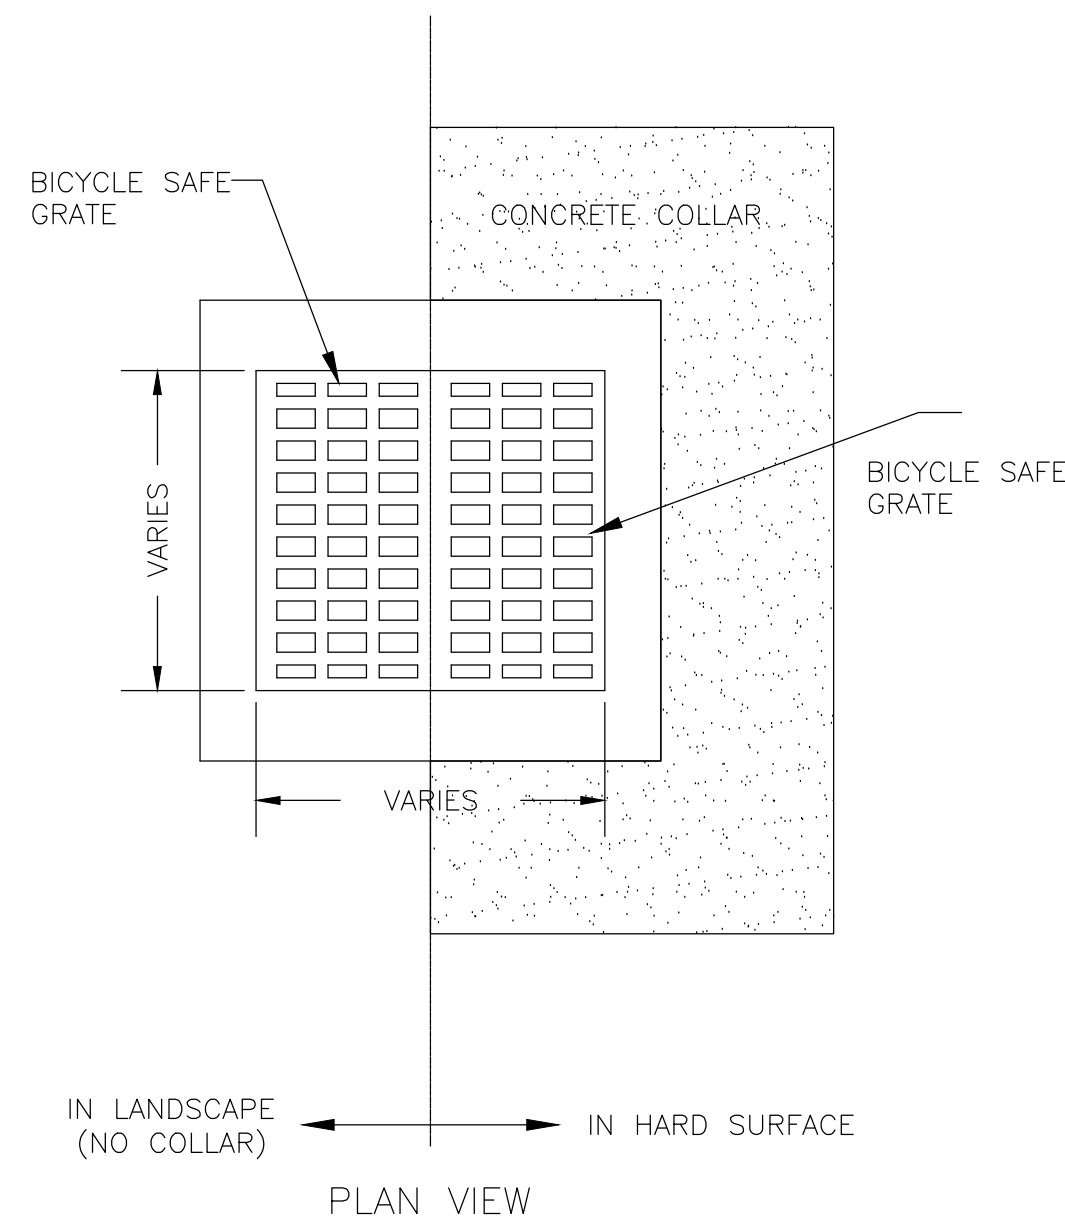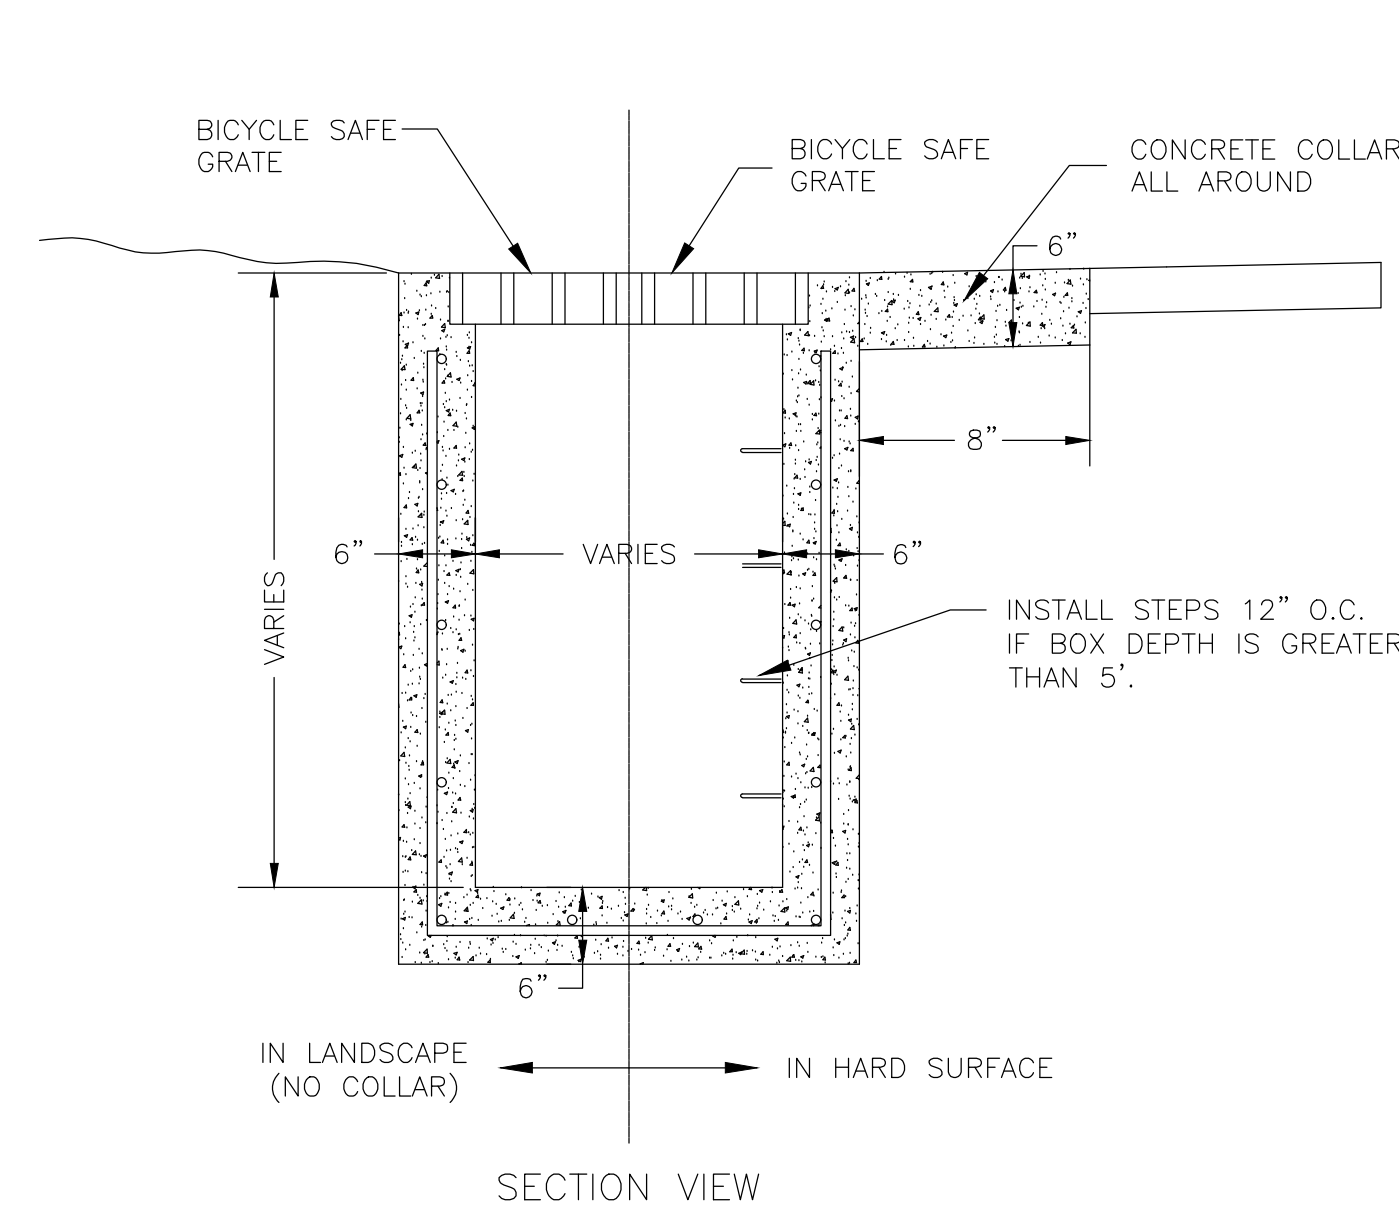

TYPICAL STORM DRAIN BOX


N.T.S.

TYPICAL STORM DRAIN BOX

N.T.S.

10 TYPICAL STORM DRAIN BOX

Scale: NTS

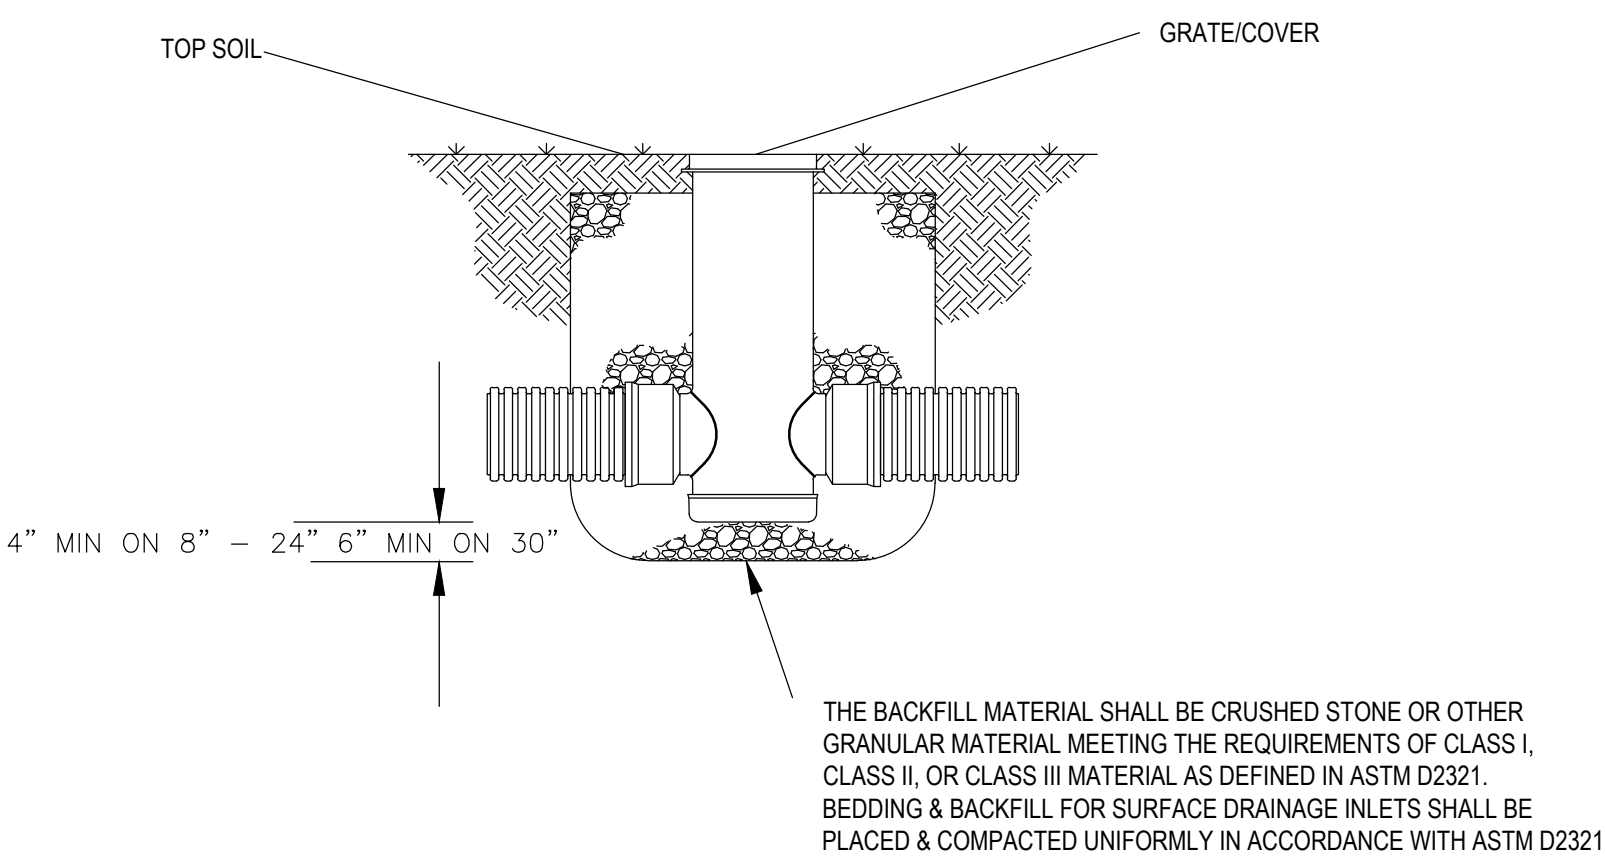


11 NON TRAFFIC INSTALLATION - DRAIN BASIN

Scale: NTS


9 TYPICAL 2'-6" X 4' CATCH BASIN

Scale: NTS

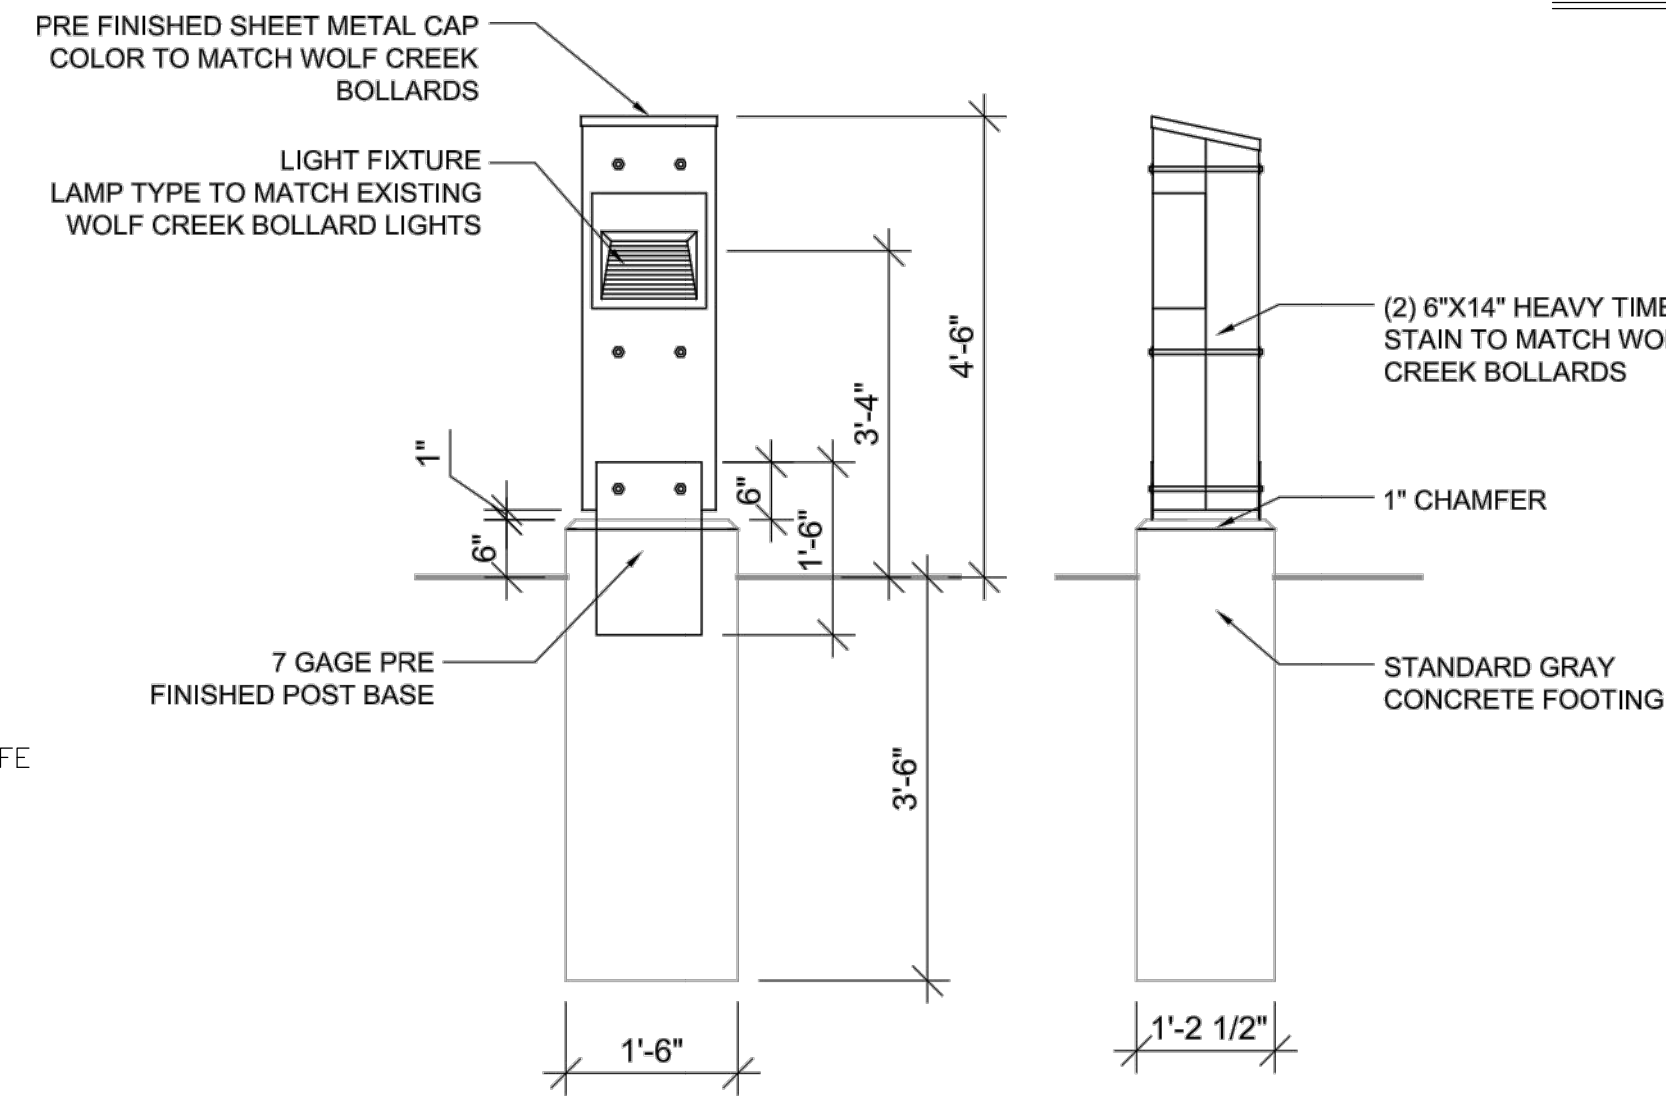

12 BOLLARD LIGHT

Scale: NTS

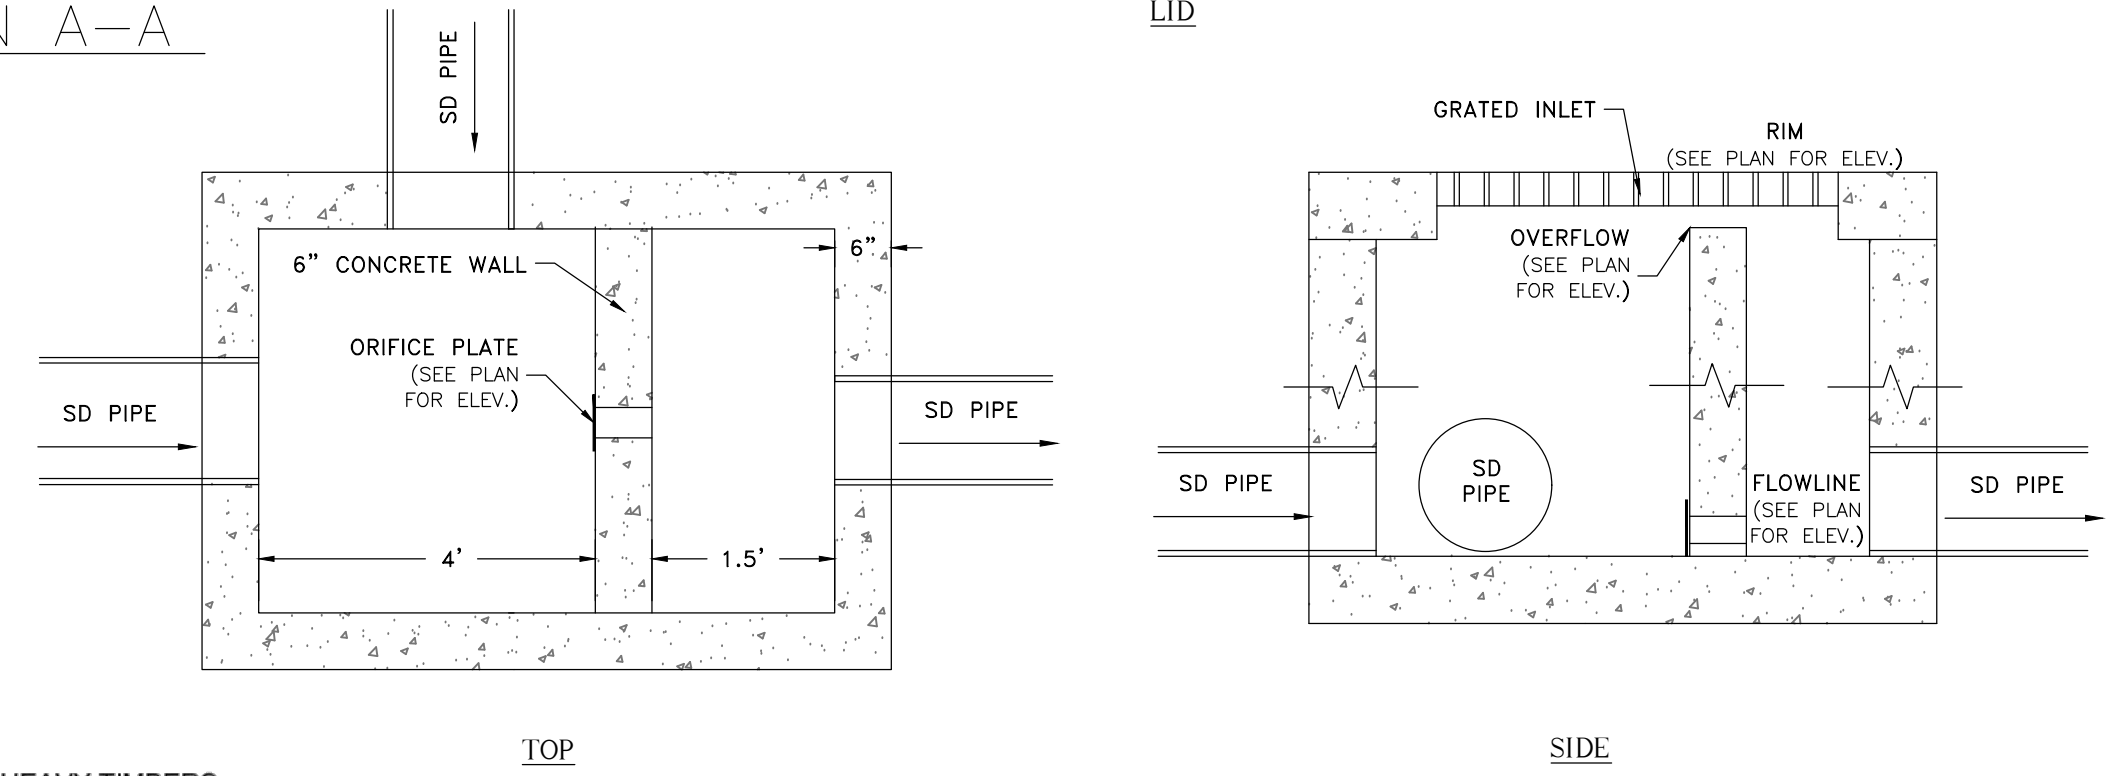


CONTROL STRUCTURE DETAIL

N.T.S.

13 3x6' STORM DRAIN CONTROL BOX


Scale: NTS

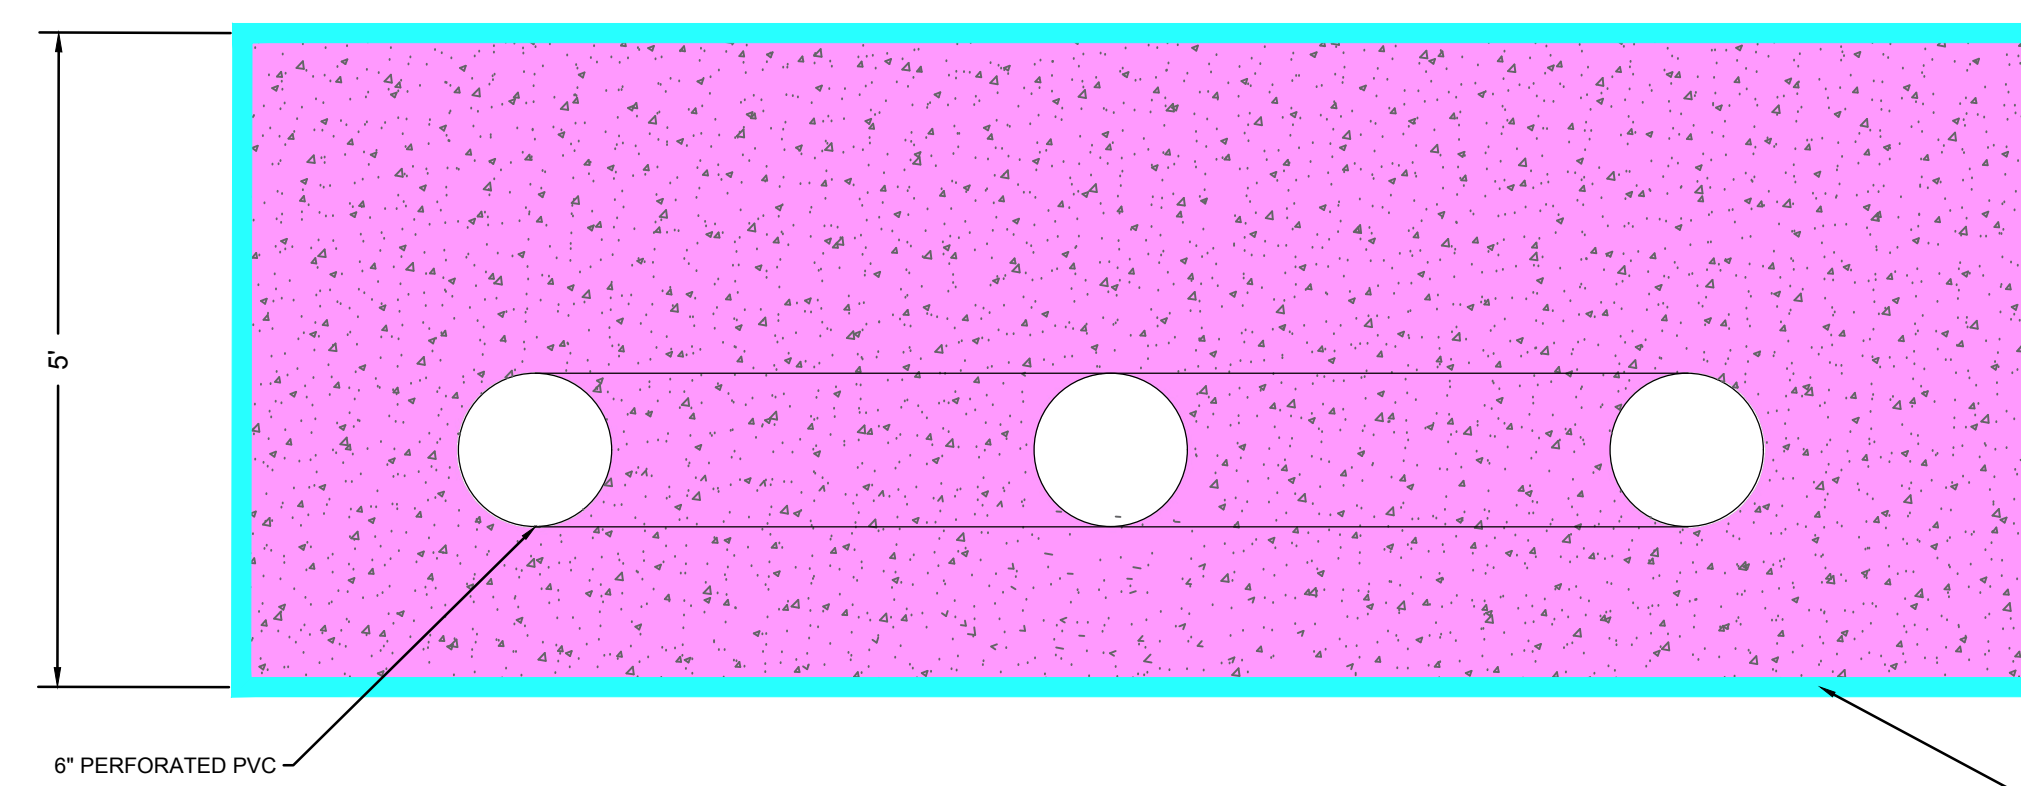

DETENTION AREA 3,150 SQFT  
 DEPTH 5FT  
 3,150 SQFT X 5FT = 15,750 CUFT  
 GRAVEL VOIDS = 40%  
 15,750 CUFT X 0.4 = 6,300 CUFT  
 DETENTION VOLUME 6,300 CUFT

14 DETENTION DETAIL

Scale: NTS

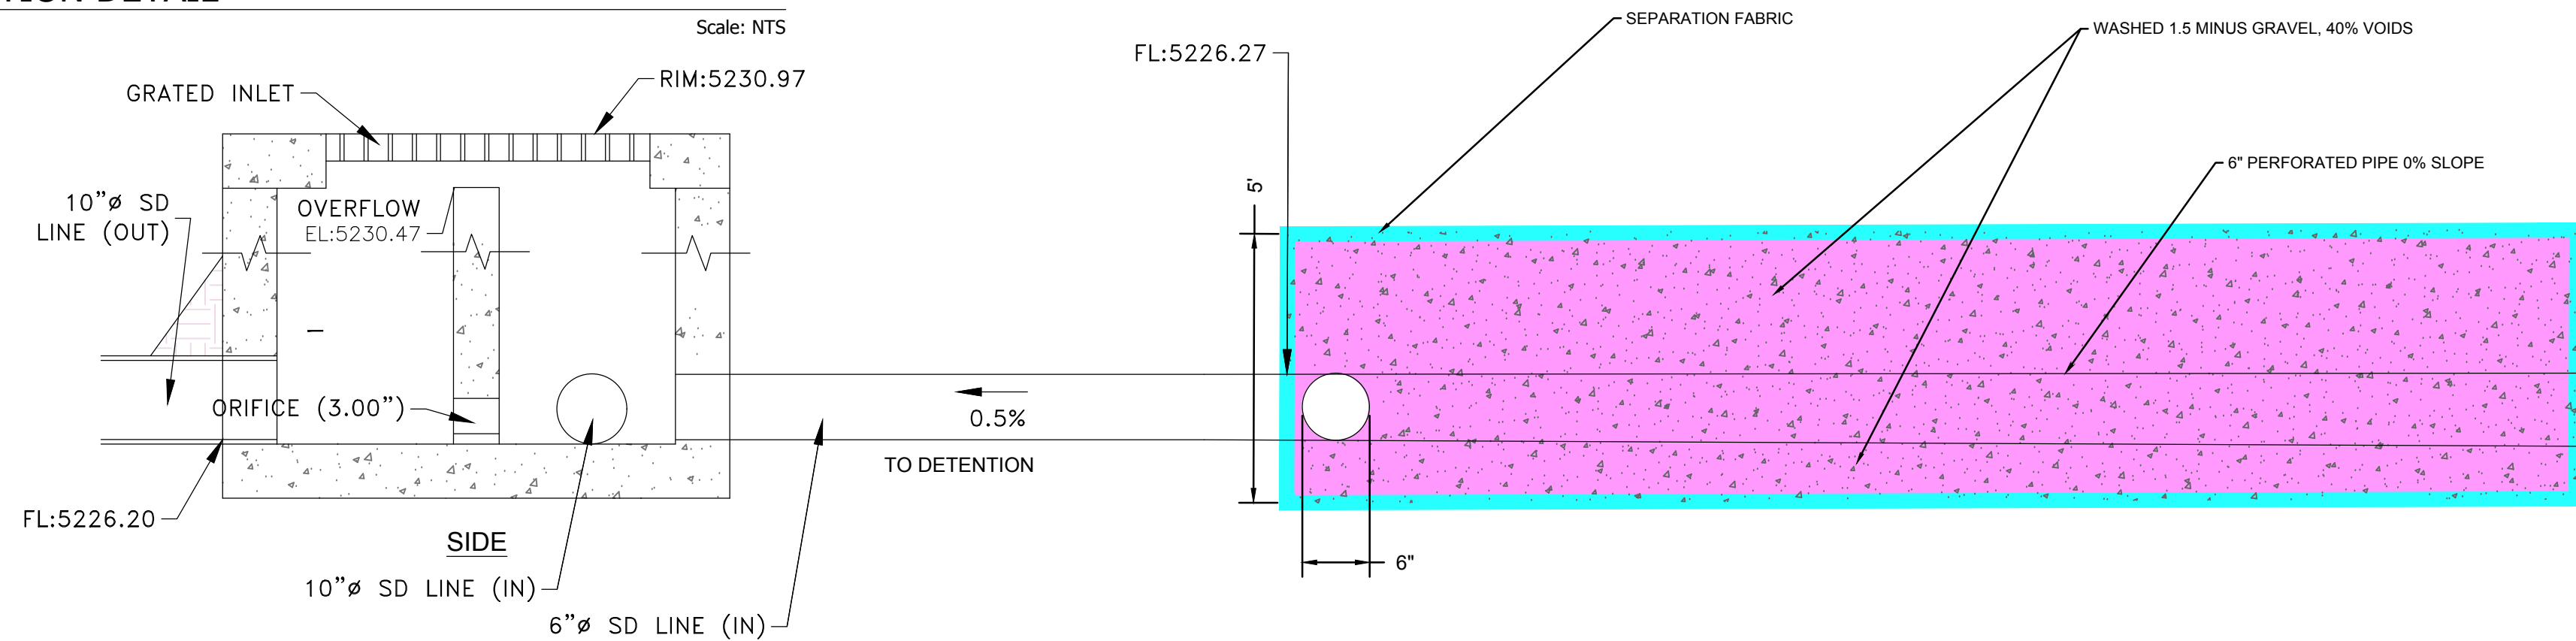

SCALE: NTS	DATE: 9-19-21	DESIGN: LZ	DRAWN: LZ	CHECKED: PC
REVISIONS	DESCRIPTION			
DATE	REVISION DETENTION/SD			
10-9-2021				
DWG: 11/101 - LOWS HOMEVUE/2021-10-09/21 THE POINTE - CONSTRUCTION SET REV 11/09/21.DWG				

STANDARD DETAILS  
 THE POINTE - CONSTRUCTION SET  
 3718 WOLF CREEK DR  
 EDEN, WEBER COUNTY, UTAH

**GARDNER ENGINEERING**  
 CIVIL - LAND PLANNING  
 MUNICIPAL - LAND SURVEYING

5150 SOUTH 375 EAST OGDEN, UT  
 OFFICE: 801.476.0202 FAX: 801.476.0066



CE1-06




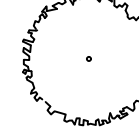


**PLANT SCHEDULE**

 

 
**PROPOSED EVERGREEN TREES:**

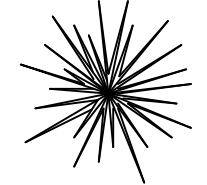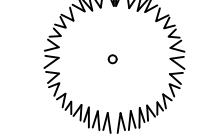-  Picea pungens - Colorado Spruce
-  Pinus ponderosa - Ponderosa Pine






**DECIDUOUS TREES:**

 -  Populus tremuloides - Quaking Aspen
-  Populus deltoides "Siouxland"  
Siouxland Plains Cottonwood

**PROPOSED SHRUBS:**



-  Cornus alba "Argenteo marginata"  
Variegated Dogwood
-  Ribies alpinium - Alpine Currant
-  Potentilla fruticosa "Jackmanii"  
Jackman Potentilla

**PERENNIALS/GRASSES/GROUNDCOVER:**

-  Achillea filipendulina  
Yellow Yarrow
-  Echinacea purpurea  
Purple Coneflower
-  Existing tree
-  LANDSCAPE GROUND COVER (BARK, COBBLE, ETC.)
-  SOD
  - BUILDING AREA 29,919 SF
  - 20% ALLOWABLE SOD: 5,983.80 SF
  - PROPOSED SOD: 5,983.59 SF

**LANDSCAPING NOTES:**

1. ALL SHRUBS, PERENNIALS AND TREES SHALL BE WATERED BY DRIP IRRIGATION LINES WITH CONTROLLING EMITTERS TO ESTABLISH FLOW RATES FOR DIFFERENT PLANT TYPES.
2. ALL TURF GRASS SHALL BE ON SEPARATE IRRIGATION ZONES FORM THE DRIP IRRIGATION SYSTEM. ALL SPRAY IRRIGATION SHALL BE HEAD-TO-HEAD DESIGN, WITH LOW PRESSURE IRRIGATION HEADS, PROPERLY MAINTAINED TO MINIMIZE WATERING OF PAVEMENT AREAS.
3. NO LANDSCAPING WATER FEATURES SUCH AS ARTIFICIAL STREAMS AND WATERFALLS, SHALL BE CONSTRUCTED.
4. EVERY MULTI-FAMILY OR EQUIVALENT STRUCTURE BUILT BY DEVELOPER OR ITS CONTRACTORS/SUBCONTRACTORS SHALL BE EQUIPPED WITH AT LEAST ONE IDENTIFIED SECONDARY WATER HOSE BIB, SUCH THAT ALL LANDSCAPING CAN BE REACHED BY A 100 FT HOSE CONNECTION.
5. THE PROJECT SHALL HAVE COVENANTS, CONDITIONS AND RESTRICTIONS (CCRs), AND AN ESTABLISHED HOA TO ENFORCE THEM. THE CCRs SHALL INCLUDE DEVELOPMENT AND MAINTENANCE OF LANDSCAPE PLANS IN CONFORMANCE WITH THIS PARAGRAPH E.

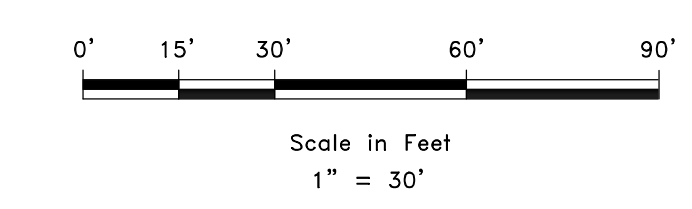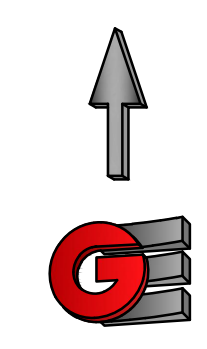

SCALE	1" = 30'
DATE	9-10-21
DESIGN	RC
DRAWN	LZ
CHECKED	RC

REVISIONS	DESCRIPTION
DATE	10-9-2021
	REVISED DETENTION/SD

LANDSCAPE PLAN  
THE POINTE - CONSTRUCTION SET  
3718 WOLF CREEK DR  
EDEN, WEBER COUNTY, UTAH

**GARDNER ENGINEERING**  
CIVIL - LAND PLANNING  
MUNICIPAL - LAND SURVEYING

5150 SOUTH 375 EAST OGDEN, UT  
OFFICE: 801.476.0202 FAX: 801.476.0066

CE1-07

R:\1201 - Lewis Homes\1201 THE POINTE\DESIGN\DWG\The Pointe - Construction Set\REV 110021.dwg, CE1-07 LANDSCAPING PLAN, 11/10/2021 10:45:29 AM ARCHITLAW.DWG (1/10/2021) 11