


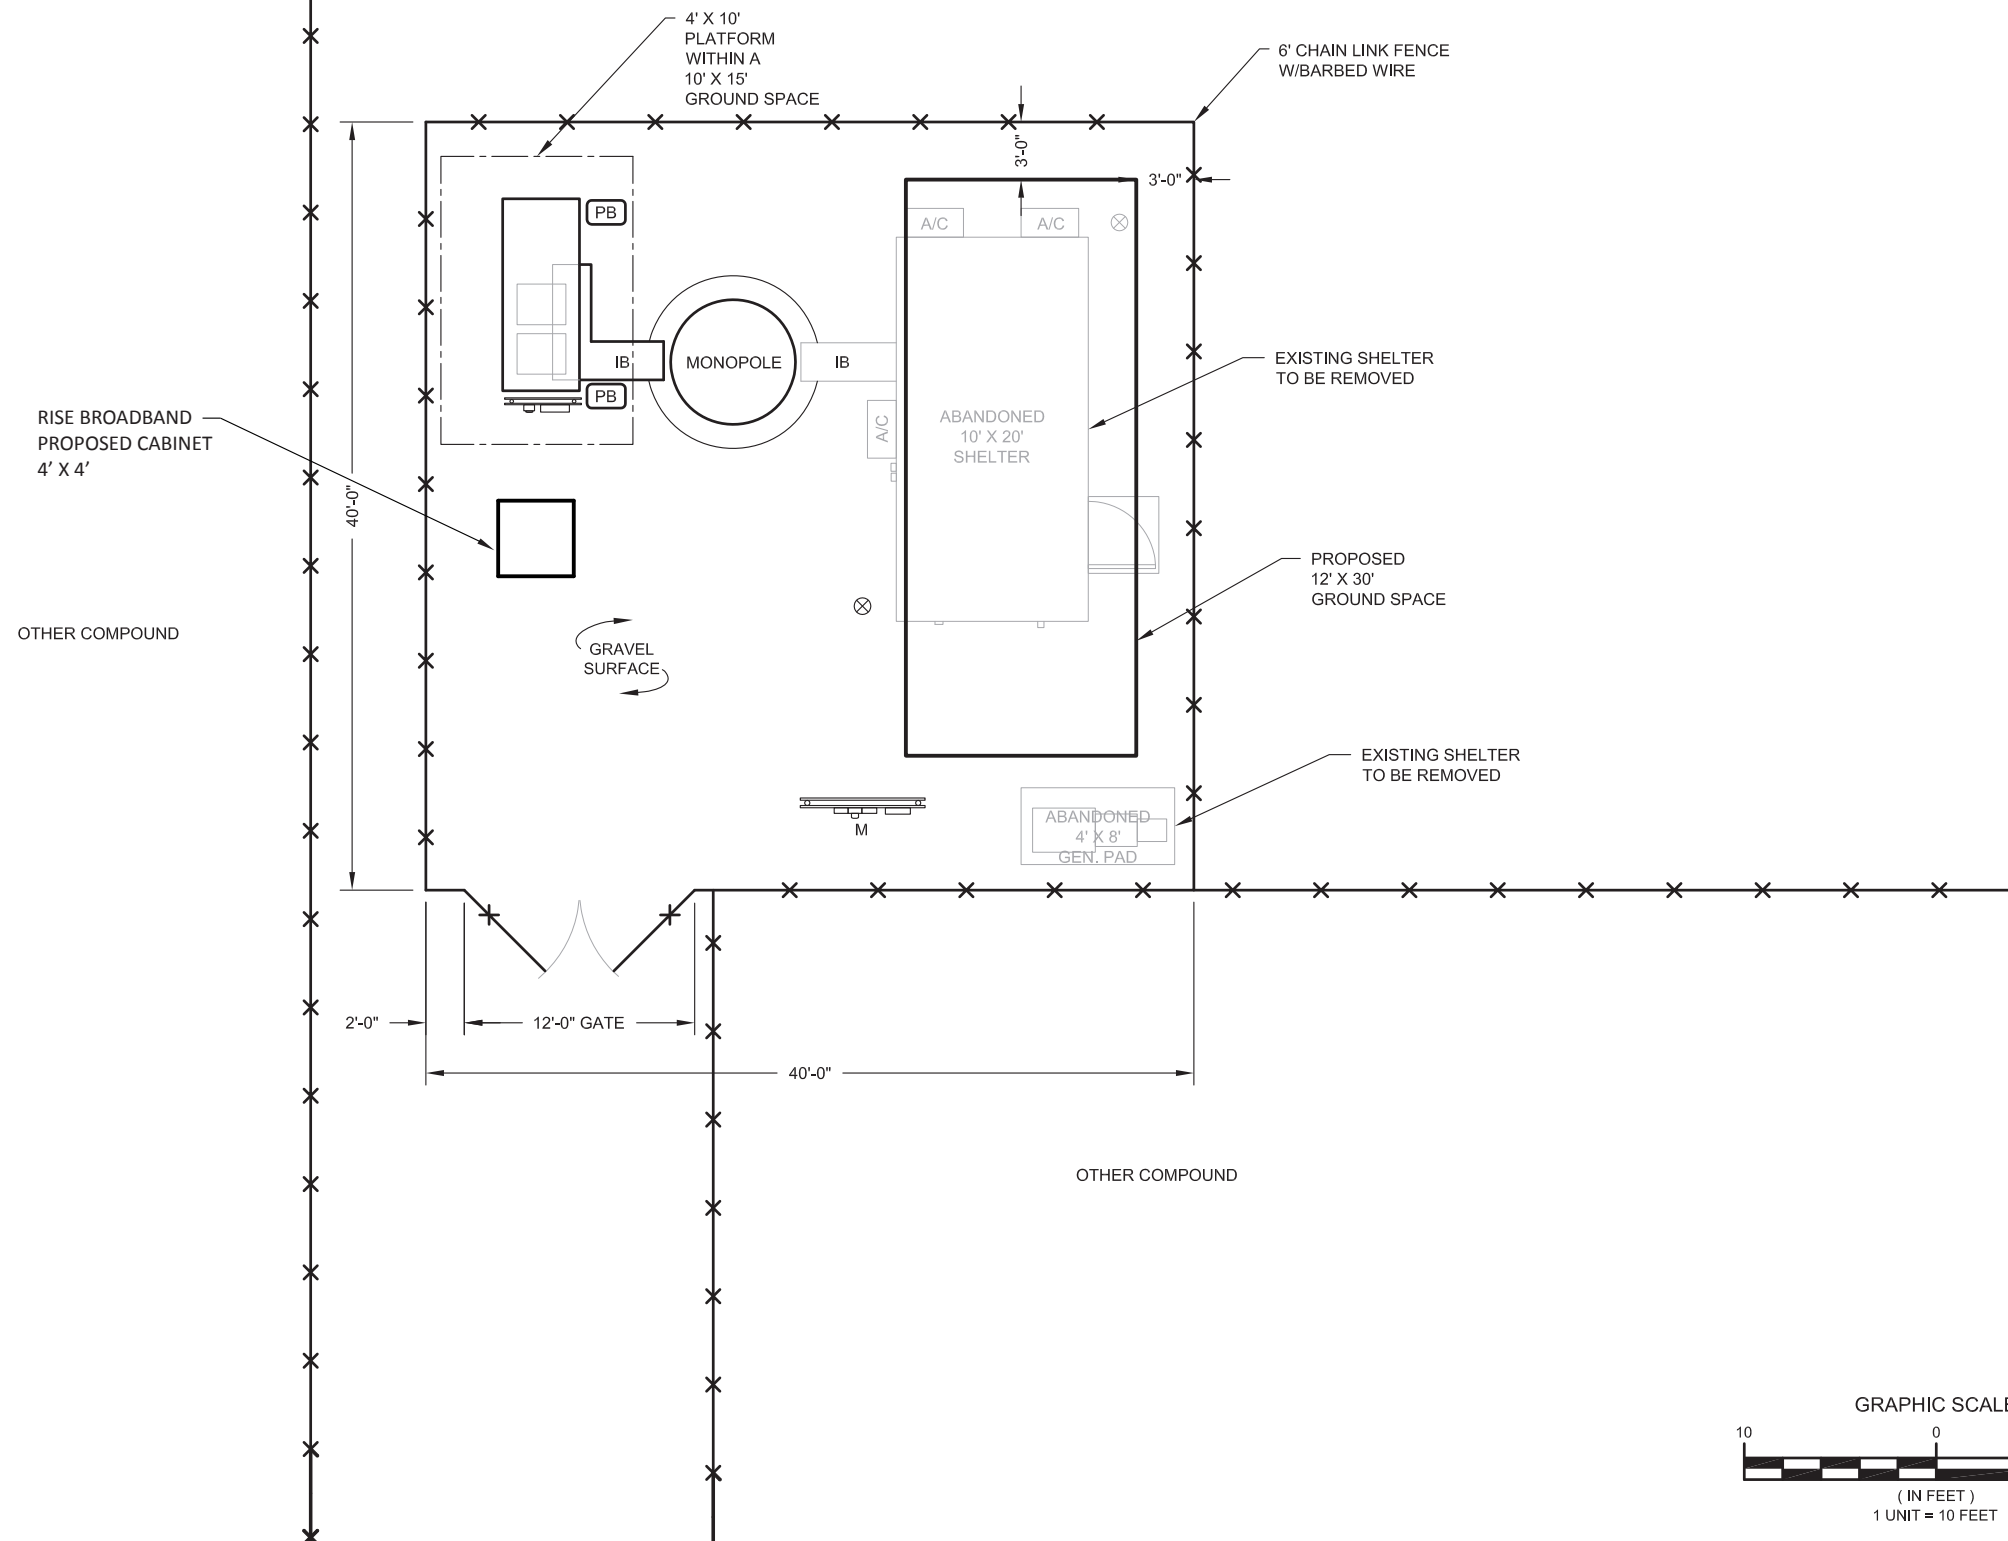

THESE DRAWINGS AND/OR THE ACCOMPANYING SPECIFICATION AS INSTRUMENTS OF SERVICE, ARE THE EXCLUSIVE PROPERTY OF LESSOR/SITE OWNER AND THEIR USE AND PUBLICATION SHALL BE RESTRICTED TO THE ORIGINAL SITE FOR WHICH THEY ARE PREPARED. REUSE, REPRODUCTION OR PUBLICATION BY ANY METHOD, IN WHOLE OR IN PART, IS PROHIBITED EXCEPT BY WRITTEN PERMISSION FROM LESSOR/SITE OWNER. TITLE TO THESE PLANS AND/OR SPECIFICATIONS SHALL REMAIN WITH LESSOR/SITE OWNER WITHOUT PREJUDICE AND VISUAL CONTACT WITH THEM SHALL CONSTITUTE PRIMA FACIE EVIDENCE OF ACCEPTANCE OF THESE RESTRICTIONS.

ALL MEASUREMENTS AND LOCATIONS USED IN THIS SITE DESIGN ARE APPROXIMATE AND LESSOR/SITE OWNER MAKES NO REPRESENTATIONS OR WARRANTIES AS TO UNDERGROUND FEATURES, INCLUDING BUT NOT LIMITED TO UTILITIES, ROCK FORMATIONS, ETC. THIS SITE DESIGN SHALL NOT BE USED FOR CONSTRUCTION PURPOSES AND LESSEE SHOULD CONTACT AND UTILIZE A UTILITY LOCATOR SERVICE PRIOR TO COMMENCING CONSTRUCTION TO AVOID SERVICE DISRUPTION TO OTHER USERS AND INJURY OR DEATH



| DESCRIPTION | |
|---------------------|-----------------|
| PROPOSAL | |
| <u>SITE NUMBER</u> | |
| 310320 | |
| <u>SITE NAME</u> | |
| NORTH OGDEN UTAH | |
| DRAWN BY: | E. L. SCHROEDER |
| DATE DRAWN: | 4/21/2014 |
| CUSTOMER: | |
| COLLOCATION NO. | |

| LEGEND | |
|---------|---------------------------|
| ⊗ | GROUNDING TEST WELL |
| A/C | AIR CONDITIONING UNIT |
| AV | AIR VENT |
| B | BOLLARD |
| C | CABINET |
| CS | COAX SHROUD |
| CFC | FIBER OPTIC CABINET |
| E | ELECTRICAL |
| F | FIBER |
| HH | HAND HOLE |
| GEN | GENERATOR |
| G | GENERATOR RECEPTACLE |
| IB | ICE BRIDGE |
| LC | LIGHTING CONTROL |
| LPG | LIQUID PROPANE GAS |
| M | METER |
| OHW | OVERHEAD WIRE |
| P | POWER |
| PB | PULL BOX |
| PP | POWER POLE |
| T | TELCO |
| TRN | TRANSFORMER |
| W | WATER VALVE |
| ---- | BUFFER |
| - - - - | GROUND SPACE (LEASE AREA) |
| - - - - | EASEMENT |

| | |
|---|------------------------|
| DIMENSIONS NOT VERIFIED BY LICENSED SURVEYOR | |
| SHEET TITLE: SITE PLAN LAYOUT | |
| SHEET NUMBER: SP-1 | SITE AUDITED BY: ON |

