


OWNERSHIP OF DOCUMENTS: This document, and the ideas and designs incorporated herein, are the property of PAUL STOOPS ASSOCIATES, and is not to be duplicated, reproduced, or otherwise used in whole or in part without the written authorization of PAUL STOOPS ASSOCIATES.



**PARKING LOT LIGHTING PLAN**

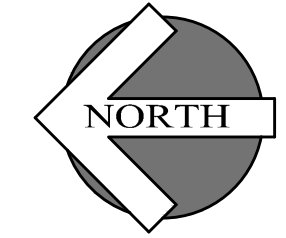


SCALE: 1" = 50'

**snowbasin**  
PROPOSED SITE LIGHTING

**snowbasin**  
A SUN VALLEY RESORT

PRELIMINARY NOT FOR CONSTRUCTION  
DATE: 03.05.2010

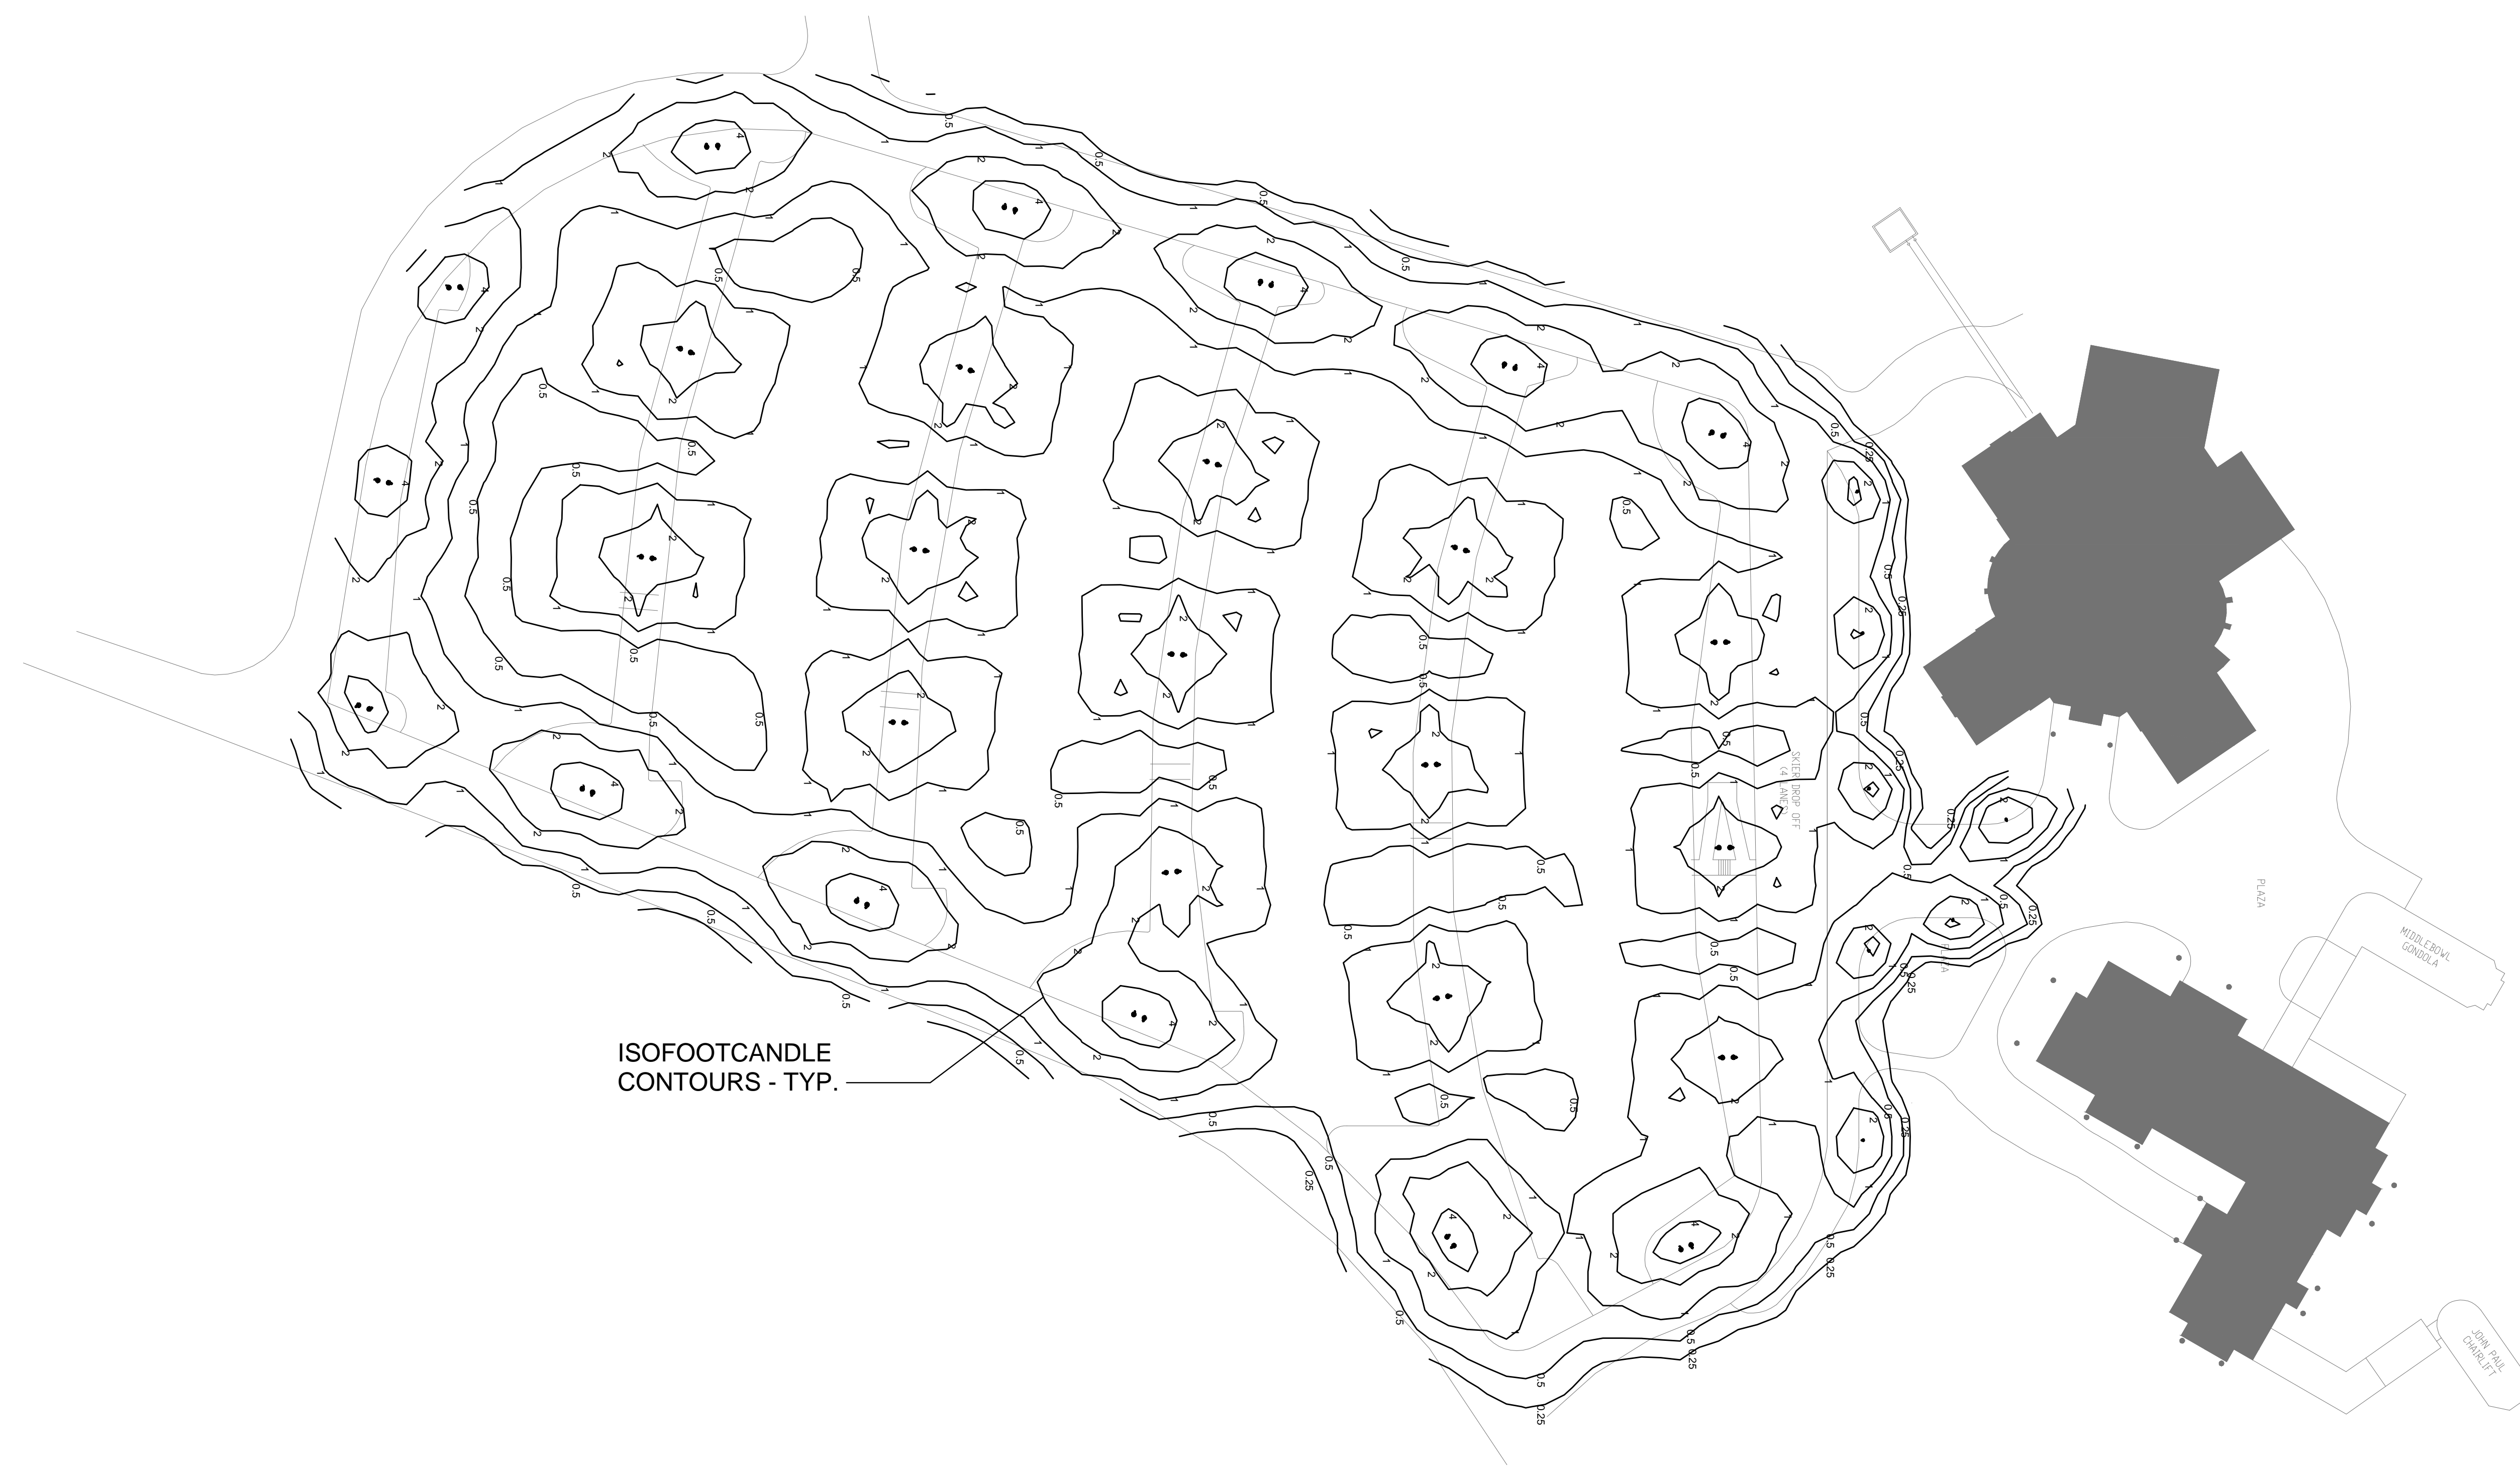

ISOFOOTCANDLE CONTOURS - TYP.



SCALE: 1" = 50'

**Paul Stoops Associates**  
ARCHITECTURAL LIGHTING DESIGN & ELECTRICAL ENGINEERING  
10000 BIRCHMOUNT RD. SUITE 100  
DALLAS, TX 75244  
TEL: 214.750.8888 FAX: 214.750.7024

MAIN PARKING LOT LIGHTING PLAN & PHOTOMETRICS

JOB: 2009-21  
DRAWN: LGS, PDS  
SCALE: AS SHOWN  
DATE: 03.05.2010

REVISIONS	DATE

L1