

MATERIALS LEGEND:


| | |
|--------------------|--|
| GYPSUM BOARD | |
| CMU WALL | |
| CONCRETE | |
| STEEL | |
| RIGID INSULATION | |
| BATT INSULATION | |
| SOIL | |
| GRAVEL | |
| PLYWOOD | |
| WOOD BLOCKING | |
| HARD WOOD | |
| ROOF INSULATION | |
| FACE BRICK | |
| ACOUSTICAL CEILING | |
| EXISTING WALL | |
| STUD WALL | |
| PROTECTION BOARD | |
| FABRIC | |

DRAWING SYMBOLS:

| | |
|-----------------------|--|
| BUILDING SECTION MARK | |
| WALL SECTION MARK | |
| ELEVATION MARK | |
| DETAIL REFERENCE MARK | |
| PLAN REFERENCE MARK | |
| DOOR MARK | |
| WINDOW MARK | |
| ROOM TITLE | |
| MATCH LINE | |
| PLAN NOTE | |
| DEMOLITION NOTE | |
| ELEVATION DATUM | |
| WALL PARTITION TYPE | |
| REVISION MARK & CLOUD | |
| NORTH ARROW | |
| CEILING TAG | |


ABBREVIATIONS:

| | | | | | |
|----------|------------------------------|------------|----------------------|--------|---------------------------|
| A.C. | ARCHITECTURAL CONCRETE | H.M. | HOLLOW METAL | T.B. | TRACK BOARD |
| A.F.F. | ABOVE FINISH FLOOR | I.D. | INSIDE DIAMETER | T.O. | TOP OF |
| ALT. | ALTERNATE | JT. | JOINT | TYP. | TYPICAL |
| BLKG. | BLOCKING | LAV. | LAVATORY | U.L. | UNDERWRITERS LABORATORIES |
| BM. | BEAM | M.B. | MARKER BOARD | U.N.O. | UNLESS NOTED OTHERWISE |
| BD. | BOARD | MFGD. | MANUFACTURED | WC. | WATER CLOSET |
| B.O. | BOTTOM OF | MFR. | MANUFACTURER | W.P. | WORKING POINT |
| C.C. | CENTER OF CENTER | MTD. | MOUNTED | W/ | WITH |
| CMU. | CONCRETE MASONRY UNIT | MTL. | METAL | | |
| CONC. | CONCRETE | N.I.C. | NOT IN CONTRACT | | |
| | | N.T.S. | NOT TO SCALE | | |
| | | O.C. | ON CENTER | | |
| D.F. | DRINKING FOUNTAIN | O.D. | OUTSIDE DIAMETER | | |
| DIM. | DIMENSION | OFD. | OVERFLOW DRAIN | | |
| D.S. | DOWNSPOUT | OPG. | OPENING | | |
| ELEV. | ELEVATION | OPP. | OPPOSITE | | |
| EQ. | EQUAL | PLAS. LAM. | PLASTIC LAMINATE | | |
| EXIST. | EXISTING | PLYWD. | PLYWOOD | | |
| F.D. | FLOOR DRAIN | PT. | PAPER TOWEL | | |
| F.E. | FIRE EXTINGUISHER | Q.T. | QUARRY TILE | | |
| F.E.C. | FIRE EXTINGUISHER CABINET | | | | |
| FIN. | FINISH | | | | |
| FLOUR. | FLUORESCENT FLOOR | REV. | REVERSE | | |
| FLR. | FLOOR | RD. | ROOF DRAIN | | |
| FNDN. | FOUNDATION | R.I. | ROUGH IN | | |
| F.O.W. | FACE OF WALL | R.I.C. | ROUGH IN AND CONNECT | | |
| F.S. | FLOOR SINK | SHT. | SHEET | | |
| F.V. | FIELD VERIFY | SIM. | SIMILAR | | |
| GA. | GAUGE | SPEC. | SPECIFICATIONS | | |
| GALV. | GALVANIZED | STL. | STEEL | | |
| GR. | GROMMET | STRUCT. | STRUCTURAL | | |
| GYP. BD. | GYPSUM BOARD | SUSP. | SUSPENDED | | |
| HCF. | HANDICAP ACCESSIBLE FOUNTAIN | | | | |
| HT. | HEIGHT | | | | |

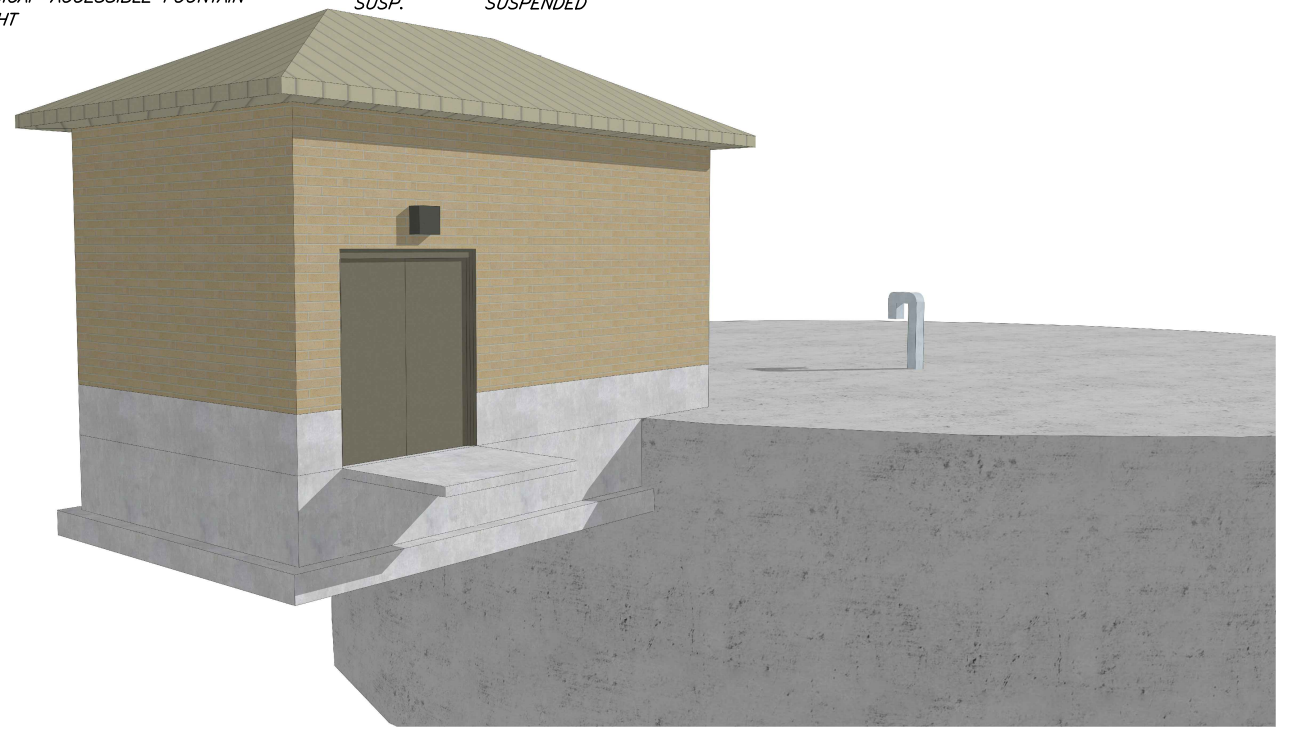

UTAH HIGHLANDS WATER & SEWER IMPROVEMENT DISTRICT
 RESERVOIR #4 PUMP STATION
GENERAL INFORMATION

| | |
|-------------|------------|
| DESCRIPTION | |
| DATE | |
| SCALE: | |
| SHEET: | A-1 |
| OF 1 SHEETS | |

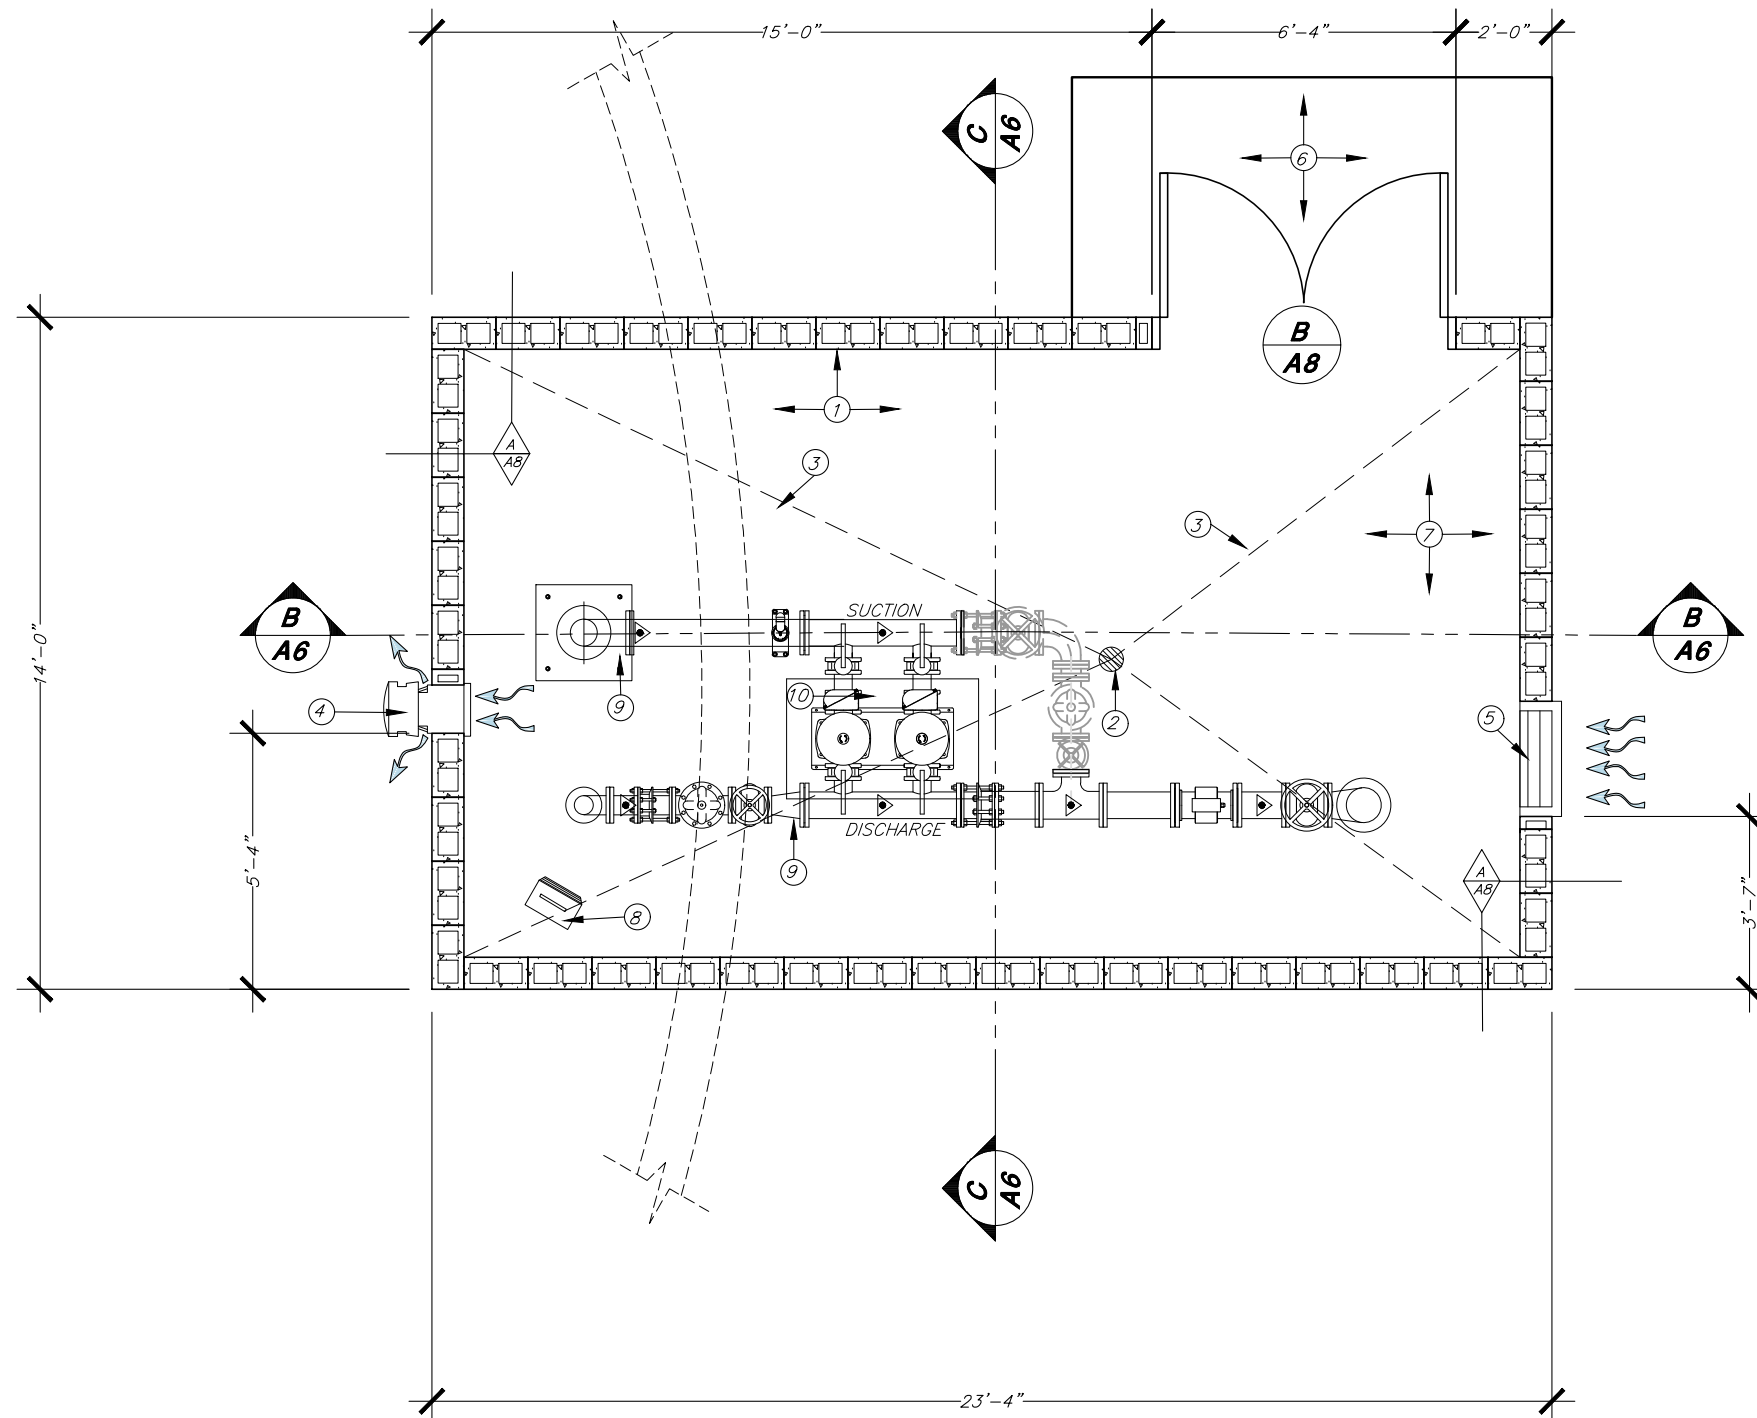

KEY NOTES:

- 1.-ELECTRICAL AND SCADA PANEL AREA - (BY OTHERS)
- 2.-FLOOR DRAIN
- 3.-SLOPE FLOOR 1%
- 4.-1200 CFM EXHAUST FAN SYSTEM (BY OTHERS)
- 5.-MOTORIZED LOUVER TYPE (BY OTHERS)
- 6.-6" THICK CONCRETE LANDING (SEE SHEET A3)
- 7.-FLOOR TO BE EPOXY COATED (TYP.)
- 8.-HEATING UNIT (SEE SHEET M1) (BY OTHERS)
- 9.-MECHANICAL PIPING LAYOUT (SEE SHEETS M1) (BY OTHERS)
- 10.-PUMPS (SEE SHEETS M1) (BY OTHERS)

FLOOR PLAN
SCALE: 1"=4'

| DATE | REVISION |
|------|----------|
| | |
| | |
| | |
| | |

| | | |
|--------------|-----------|---------|
| SLS DESIGNED | SLS DRAWN | CHECKED |
|--------------|-----------|---------|



SCALE:
24"x36" NONE
11"x17" AS-SHOWN

SHEET:
A-2
OF 1 SHEETS


| DATE | REVISION |
|------|----------|
| | |
| | |
| | |
| | |
| | |

| | | |
|--|--|--|
| | | |
|--|--|--|

| | | | |
|---------------------|--------------|-----------|---------|
| SCALE: | SLS DESIGNED | SLS DRAWN | CHECKED |
| 24"x36" AS-SHOWN | | | |
| 11"x17" AS-SHOWN | | | |

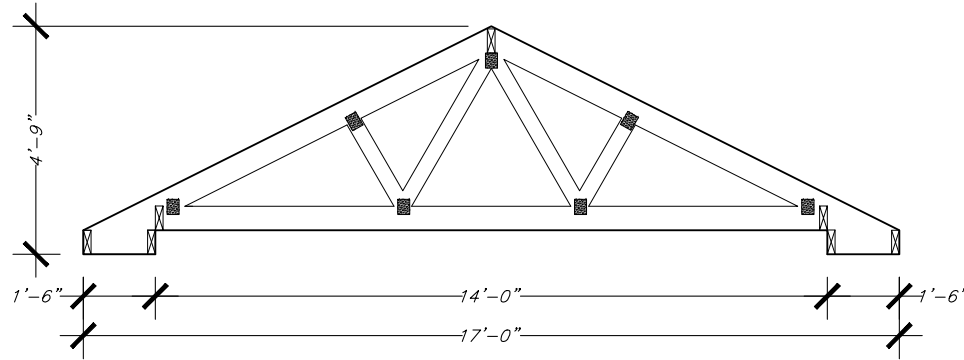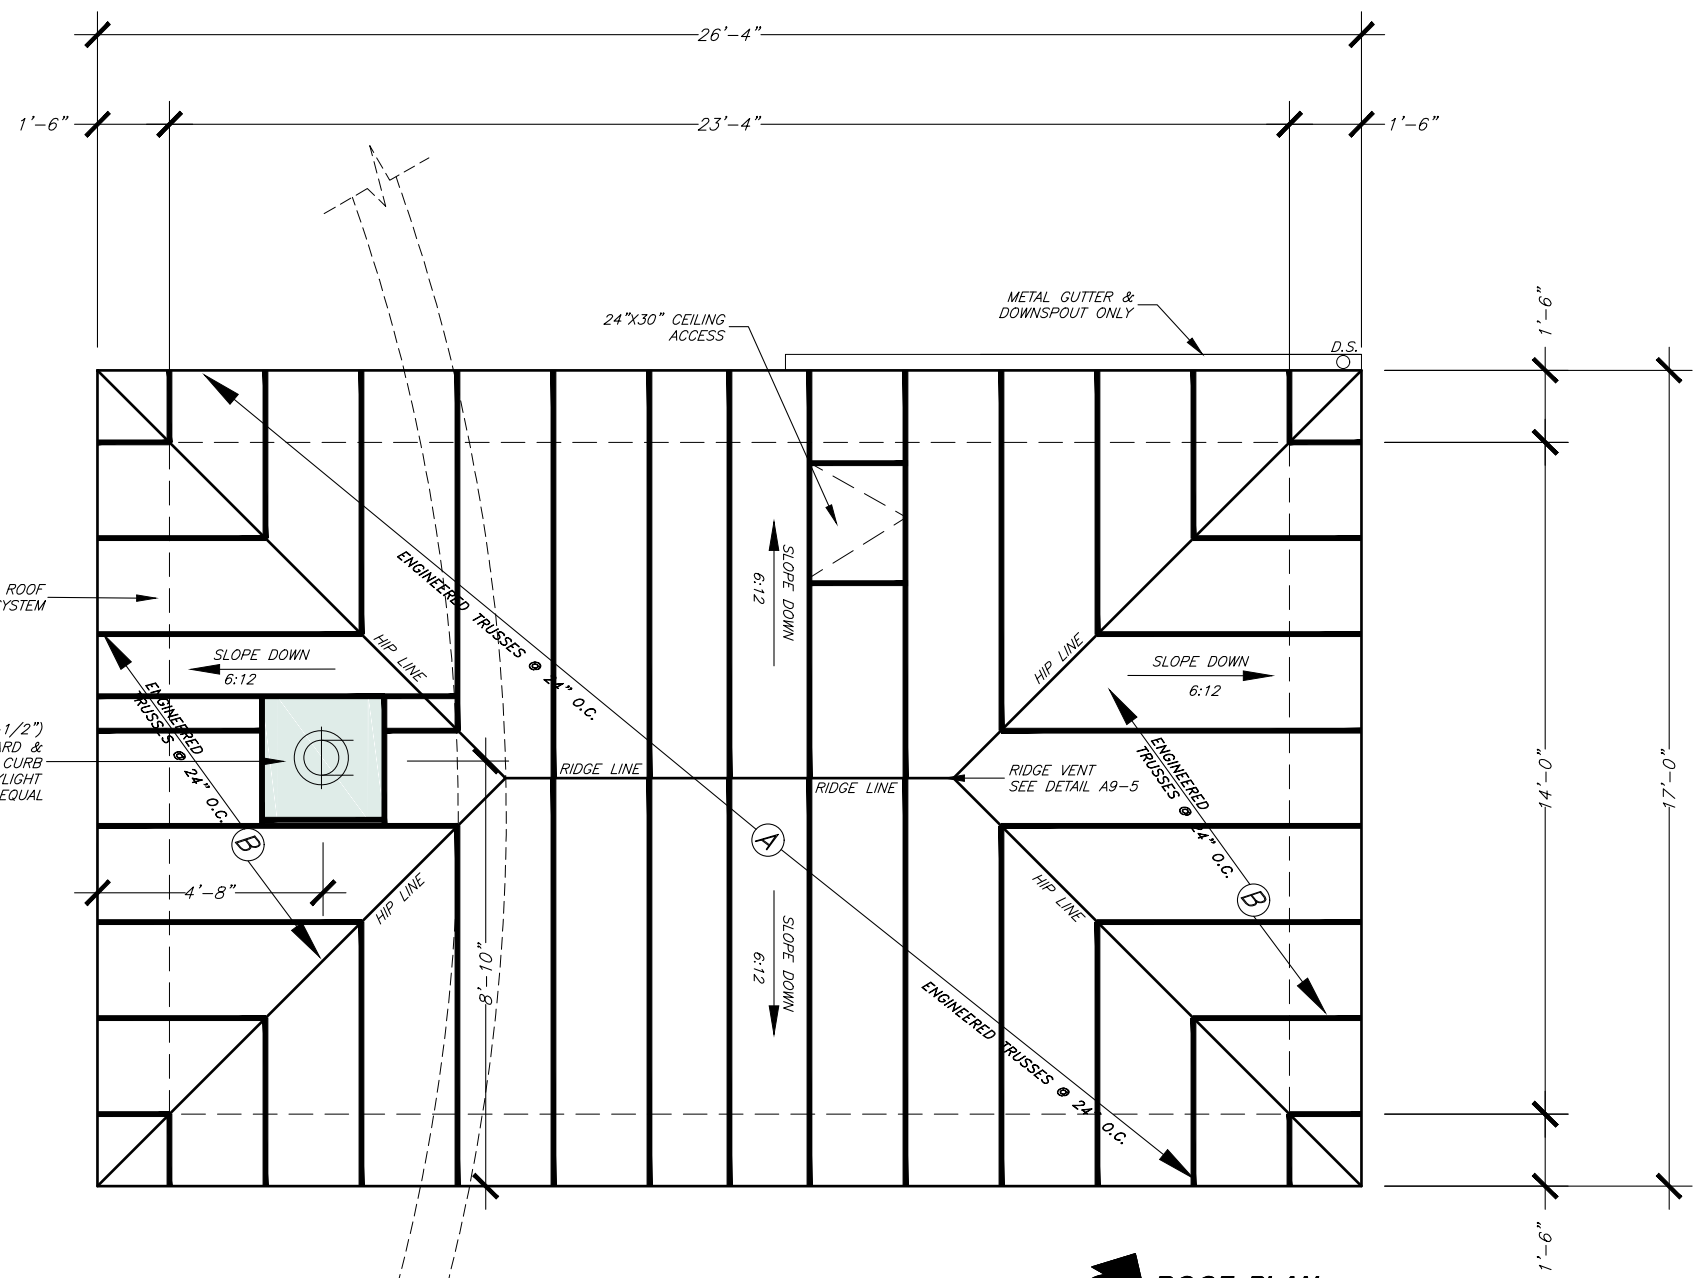

FRAME TYPE A

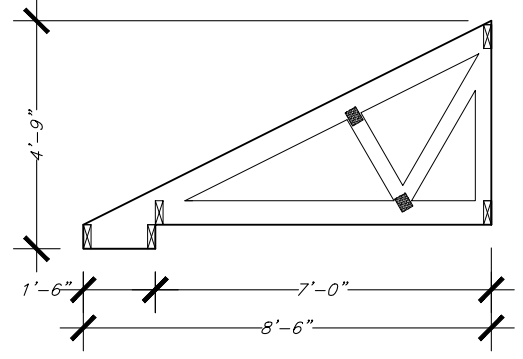


FRAME TYPE B

- NOTES:
1. METAL ROOF SYSTEM (ROOF PANEL, GUTTER, DOWNSPOUTS, ETC.) SHALL BE 26 GAUGE.
 2. ROOF PANELS SHALL BE CLASSIC RIB TYPE.
 3. COLORS AND FINISHES TO BE SUBMITTED TO OWNER FOR SELECTION.


JA ROOF PLAN
 SCALE: 1"=4'

ALL STRUCTURAL CONSTRUCTION SHALL COMPLY W/CURRENT IBC & LOCAL BUILDING CODES & SHALL BE CONSISTENT WITH COMMON CONSTRUCTION PRACTICES OF THE TRADES.


"ATLAS" BRICK COLOR TO BE SELECTED BY DISTRICT.

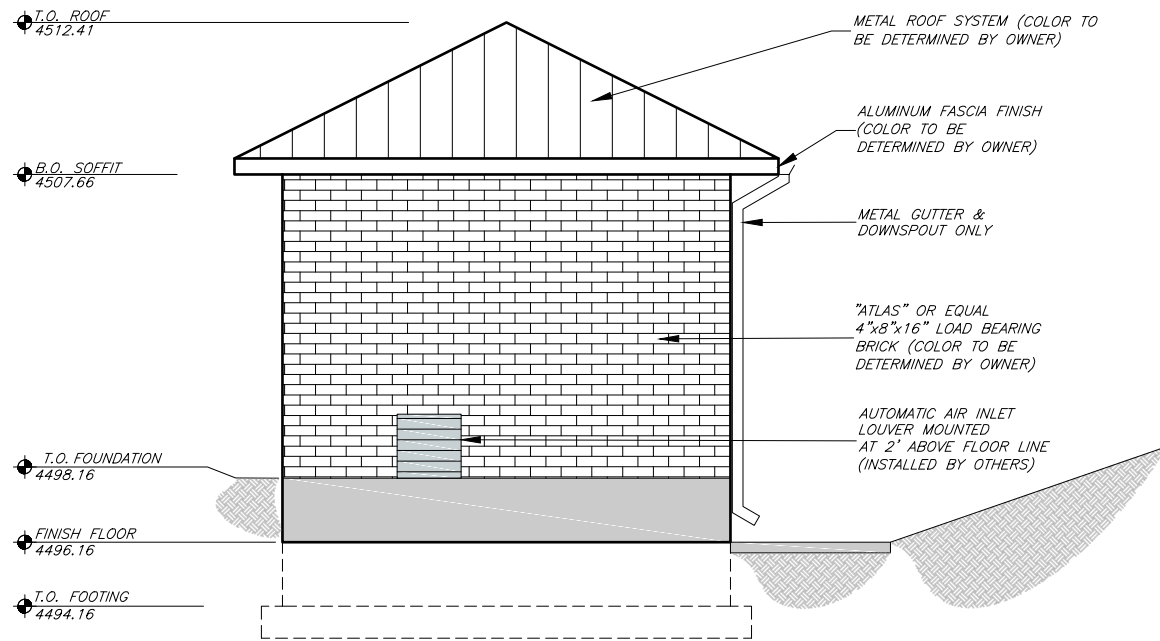


EXTERIOR ELEVATION D
SCALE: 1"=6'

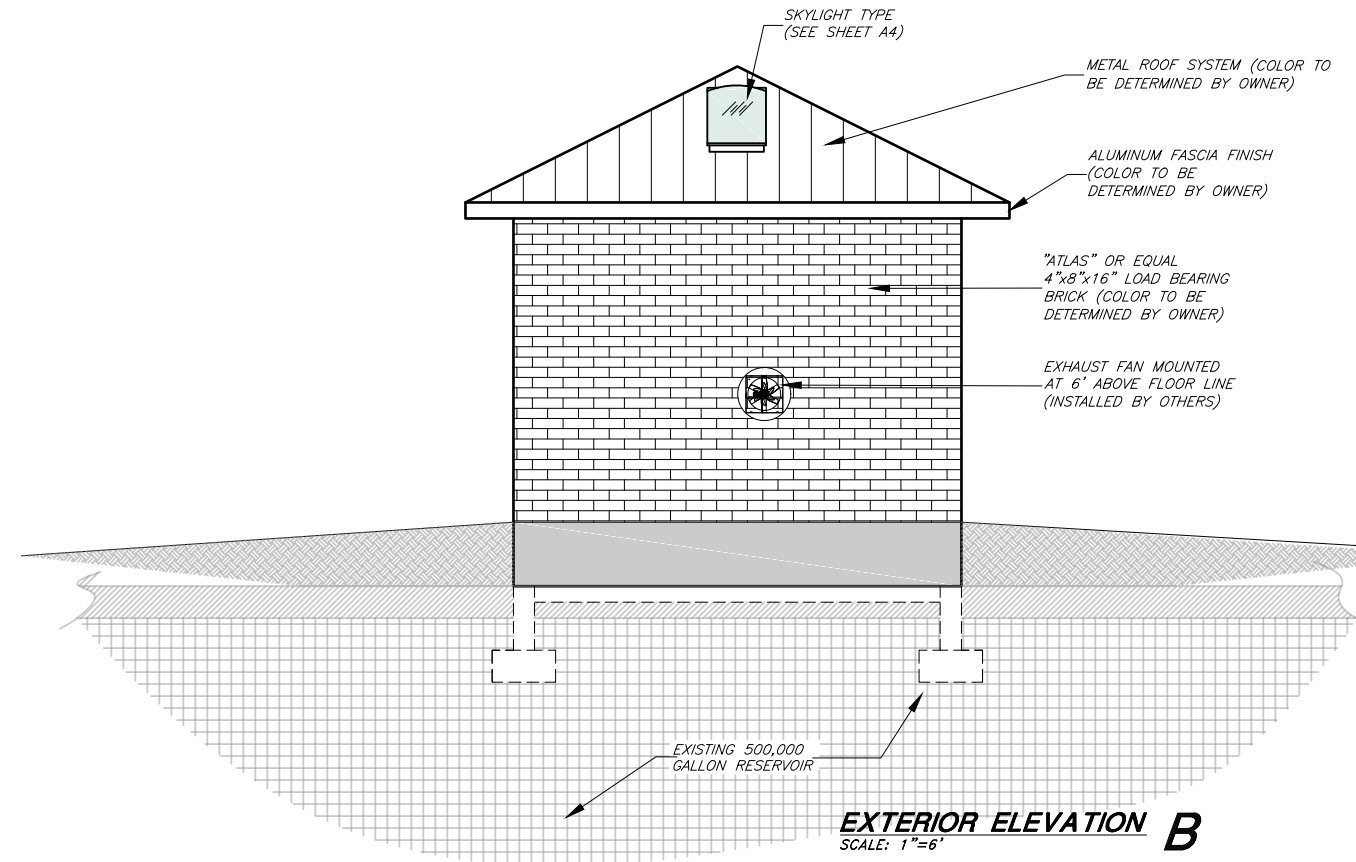

EXTERIOR ELEVATION B
SCALE: 1"=6'

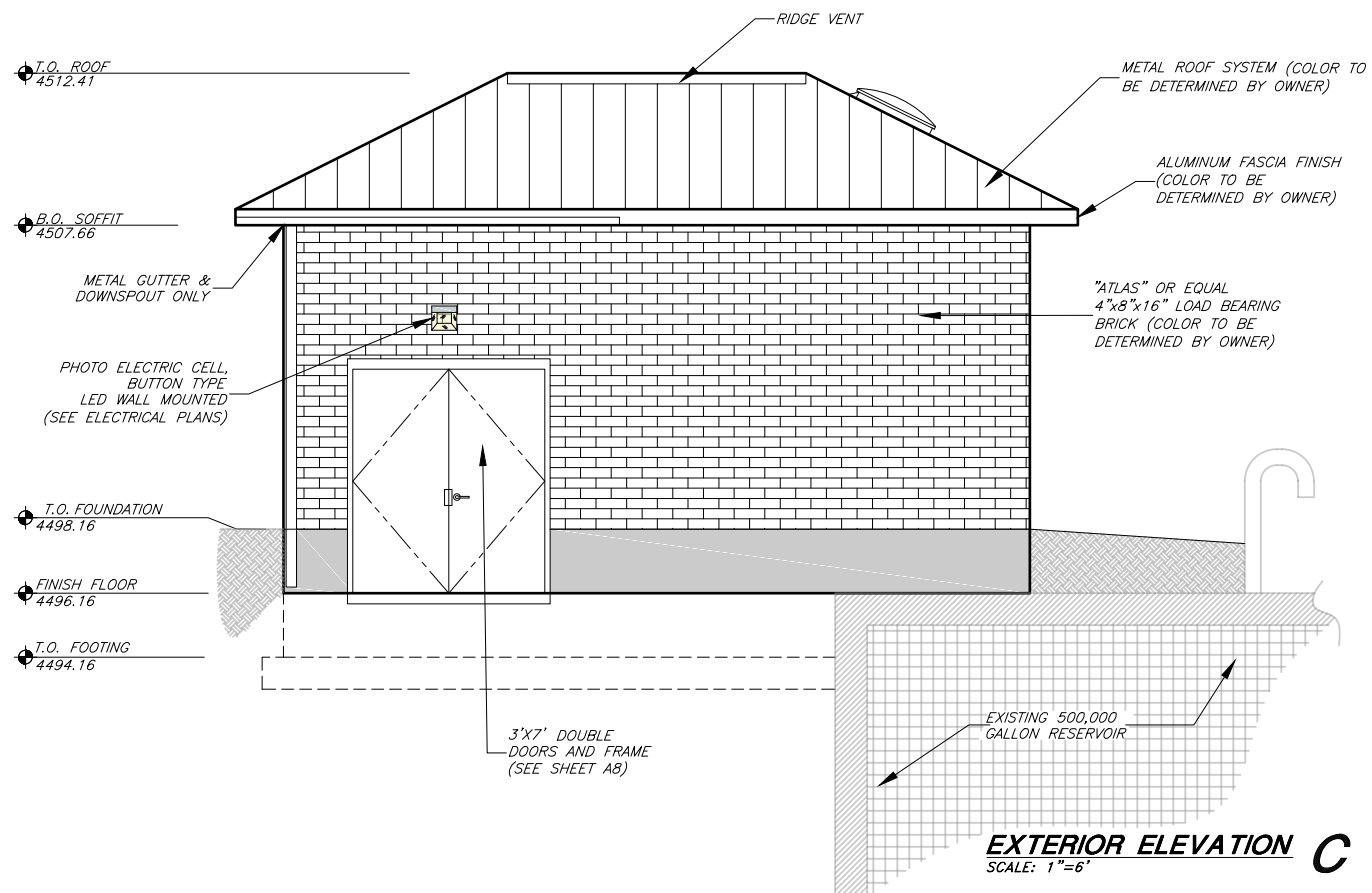

EXTERIOR ELEVATION C
SCALE: 1"=6'

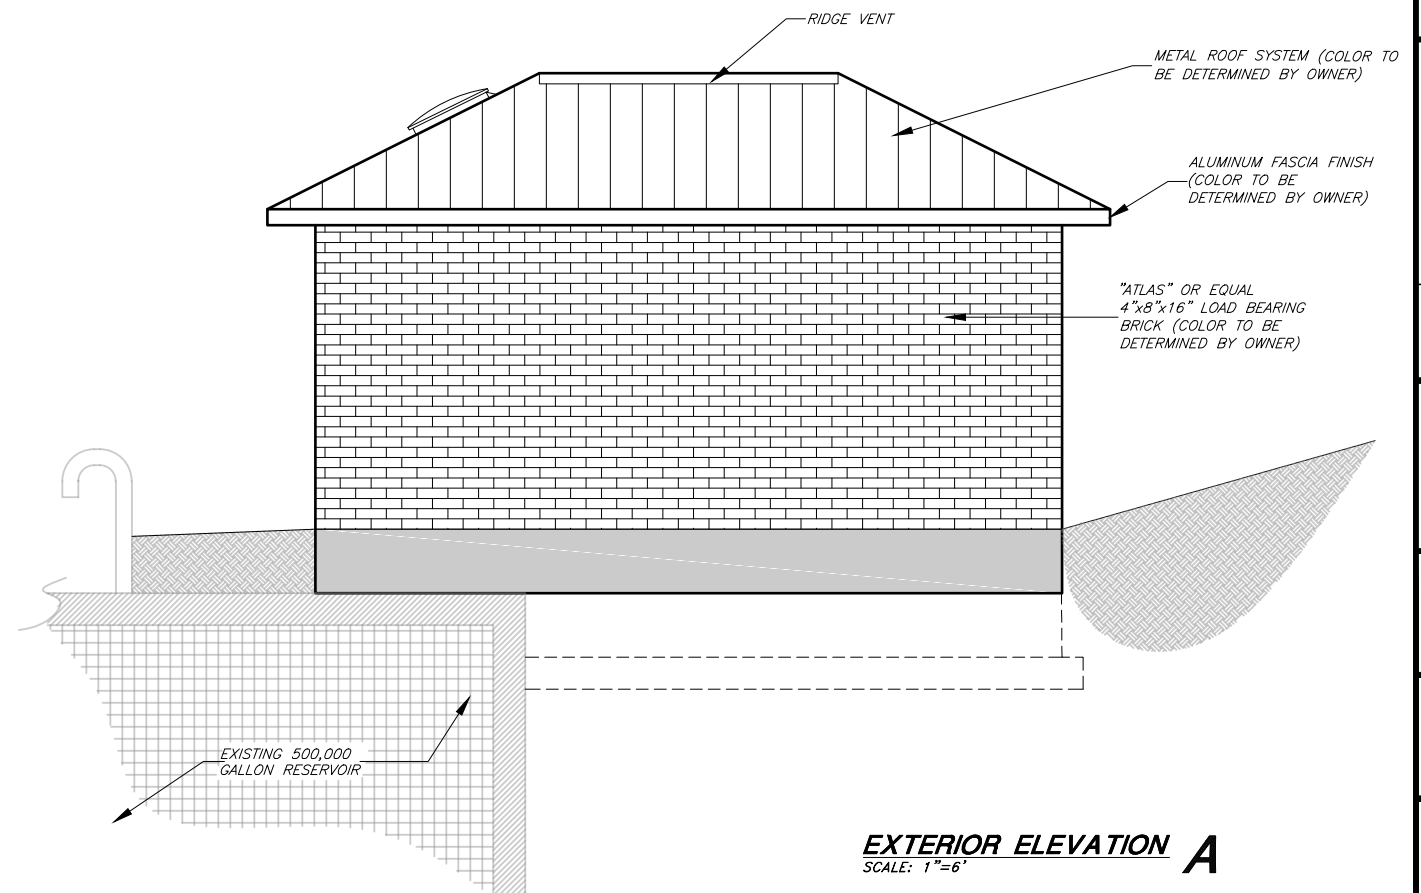


EXTERIOR ELEVATION A
SCALE: 1"=6'

| REVISION | DATE |
|----------|------|
| | |
| | |
| | |
| | |

| | |
|--|--|
| | |
|--|--|

| | | |
|--------------|-----------|-------------|
| SLS DESIGNED | SLS DRAWN | DOS CHECKED |
|--------------|-----------|-------------|

| | |
|-------------------------|-------------------------|
| SCALE: 24"x36" AS-SHOWN | SCALE: 11"x17" AS-SHOWN |
|-------------------------|-------------------------|

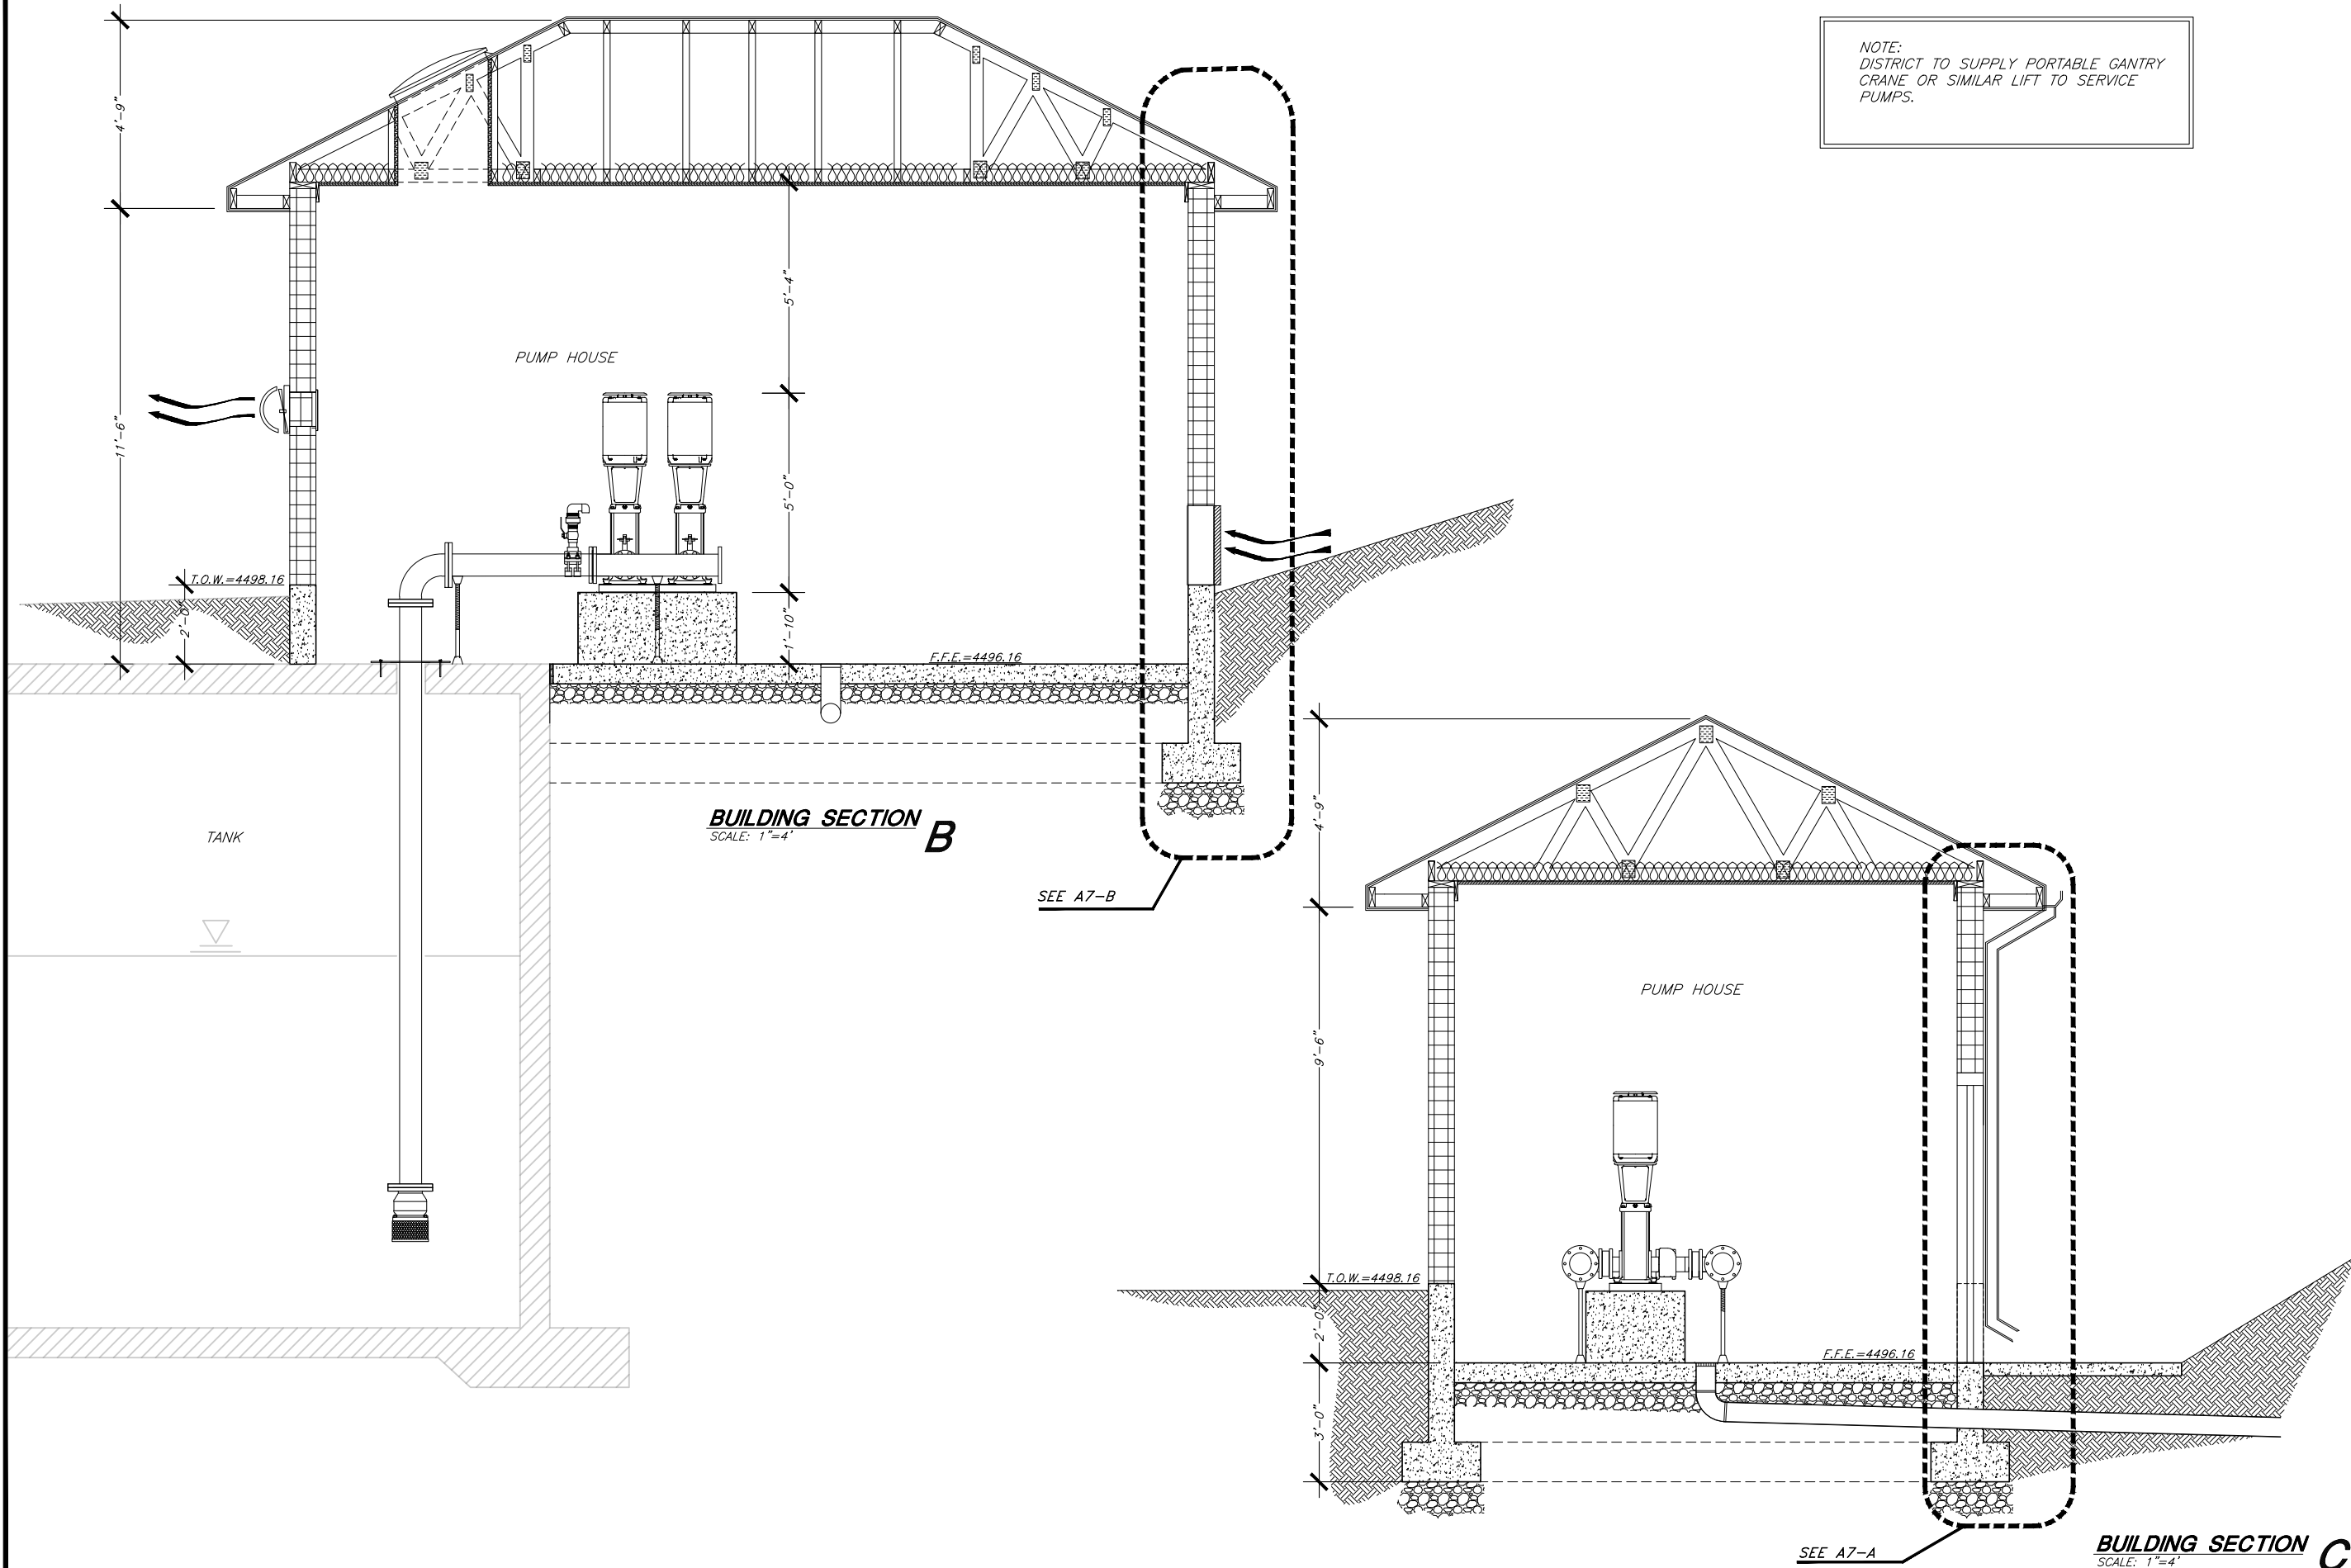


NOTE:
DISTRICT TO SUPPLY PORTABLE GANTRY
CRANE OR SIMILAR LIFT TO SERVICE
PUMPS.


| DATE | REVISION |
|------|----------|
| | |
| | |
| | |
| | |

| | | |
|--------------|-----------|-------------|
| SLS DESIGNED | SLS DRAWN | MLR CHECKED |
| | | |


| | | | | |
|--------|-----------|------|-----------|----------|
| SCALE: | 24" x 36" | NONE | 11" x 17" | AS-SHOWN |
| | | | | |

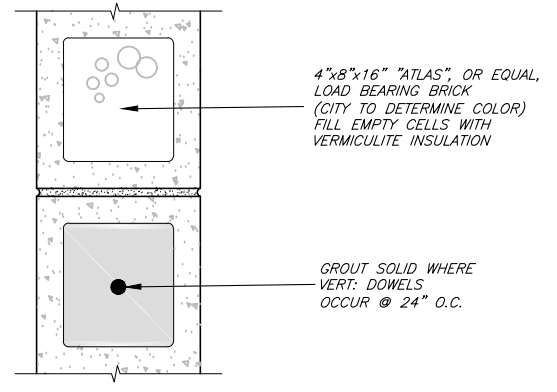

WALL TYPE **A**
 SCALE: NONE

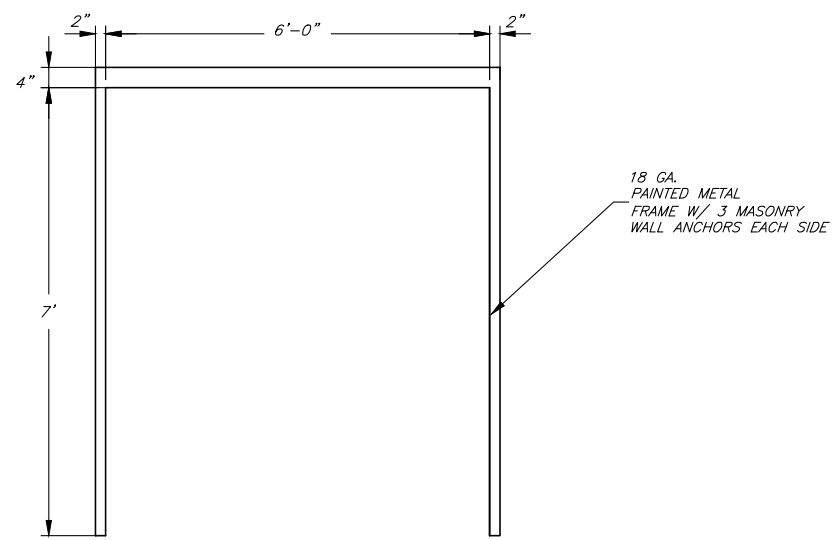

FRAME TYPE **B**
 SCALE: NONE

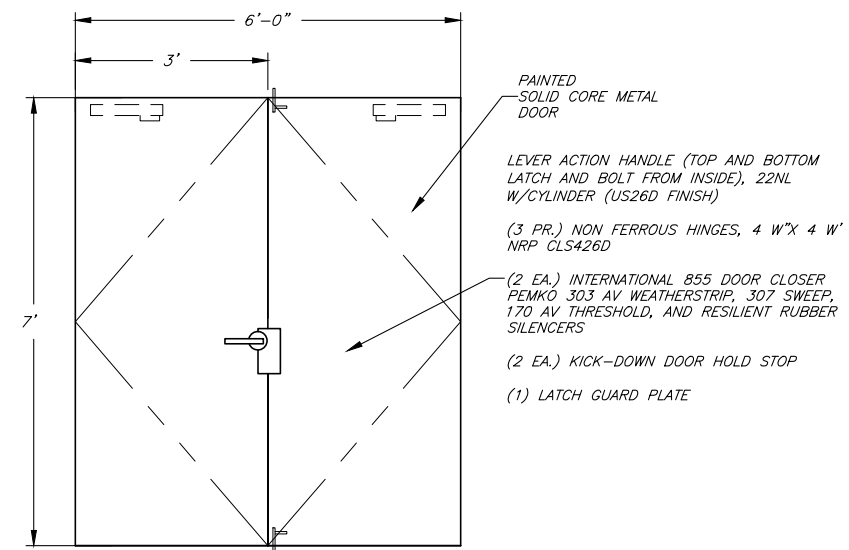


DOOR TYPE **B**
 SCALE: NONE


| REVISION | DATE |
|----------|------|
| | |
| | |
| | | |
|-----------------|--------------|---------|
| SLS DESIGNED | SLS DRAWN | CHECKED |
|-----------------|--------------|---------|


| | |
|-------------------------------|---------------------|
| SCALE: 24"x36" AS-SHOWN | 11"x17" AS-SHOWN |
|-------------------------------|---------------------|

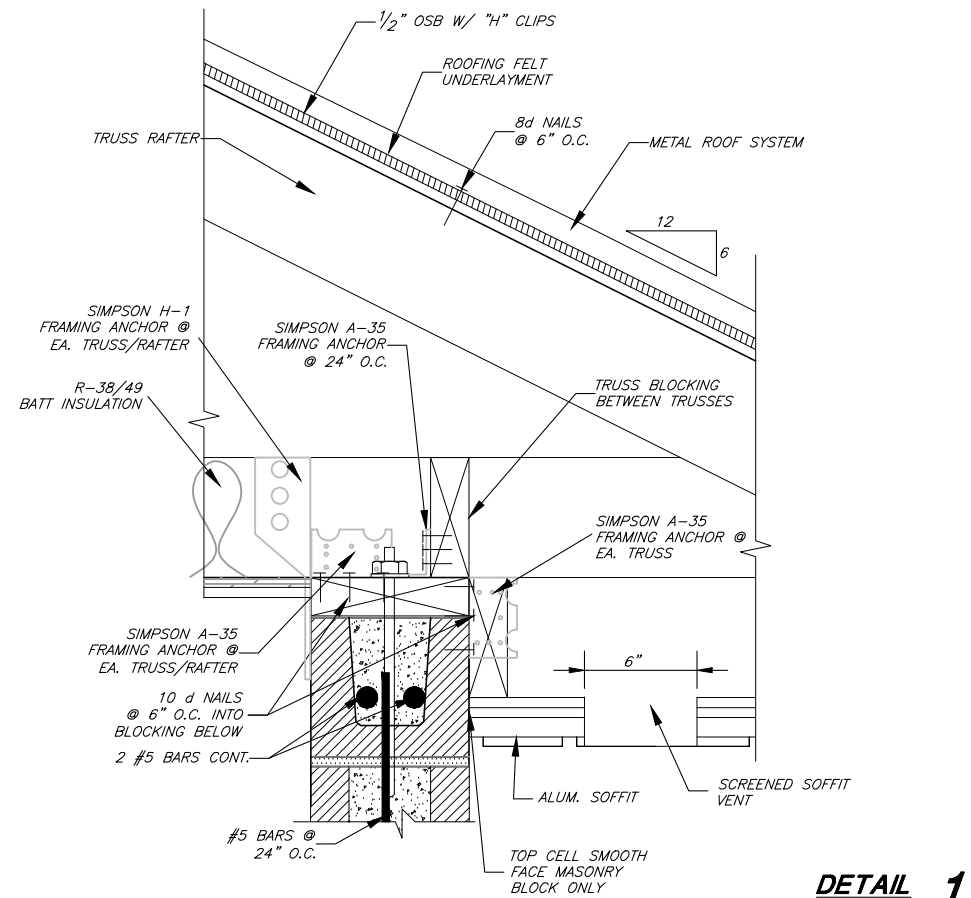


DETAIL 1
SCALE: NONE

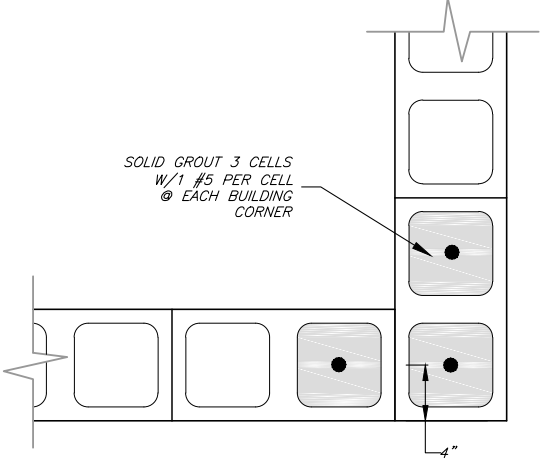


CORNER BLOCK DETAIL 3
SCALE: NONE

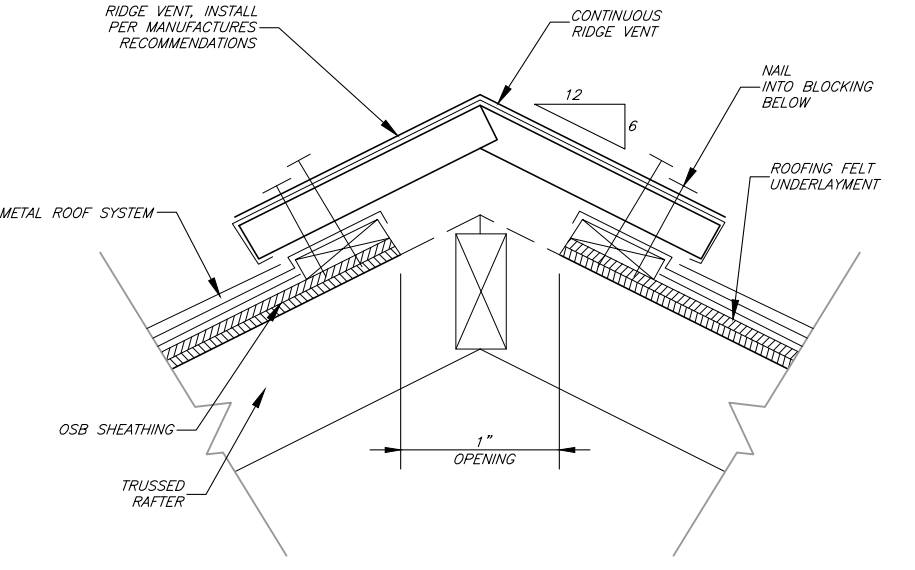


RIDGE VENT DETAIL 5
SCALE: NONE

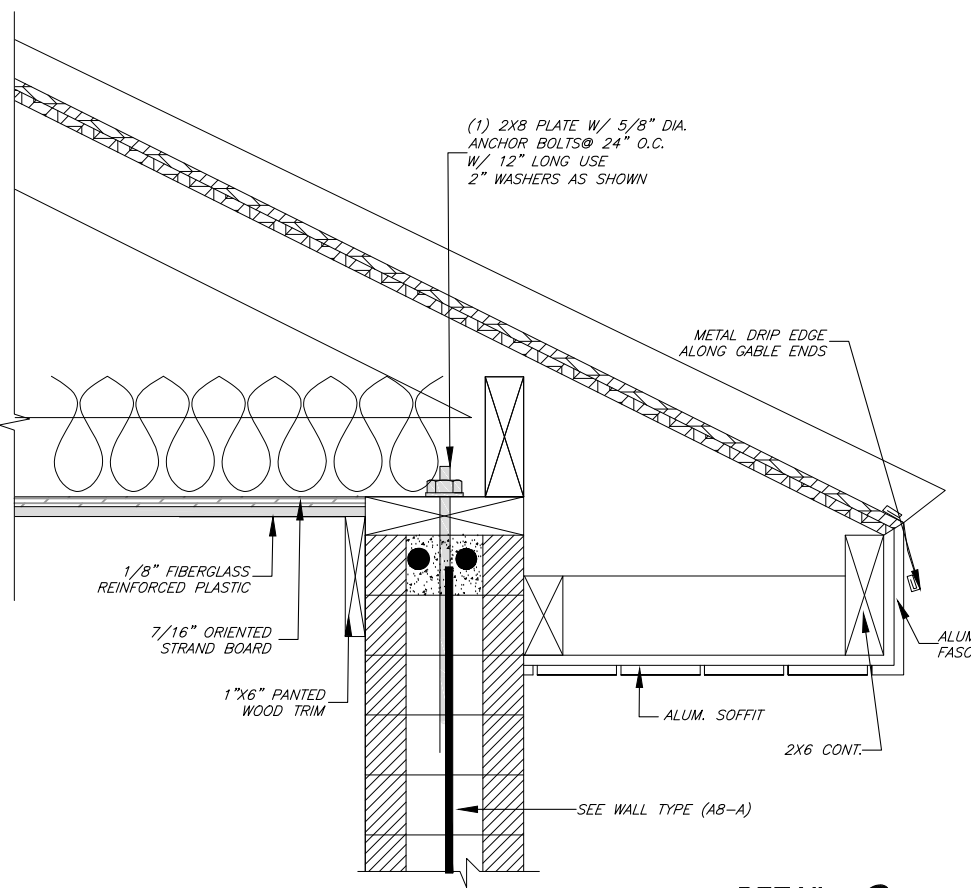

DETAIL 2
SCALE: NONE

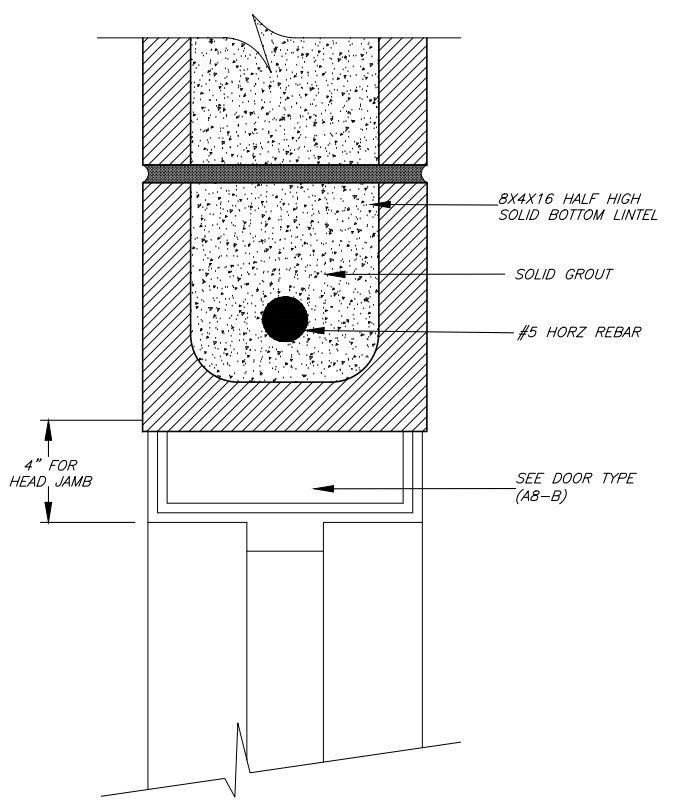

LINTEL DETAIL 4
SCALE: NONE

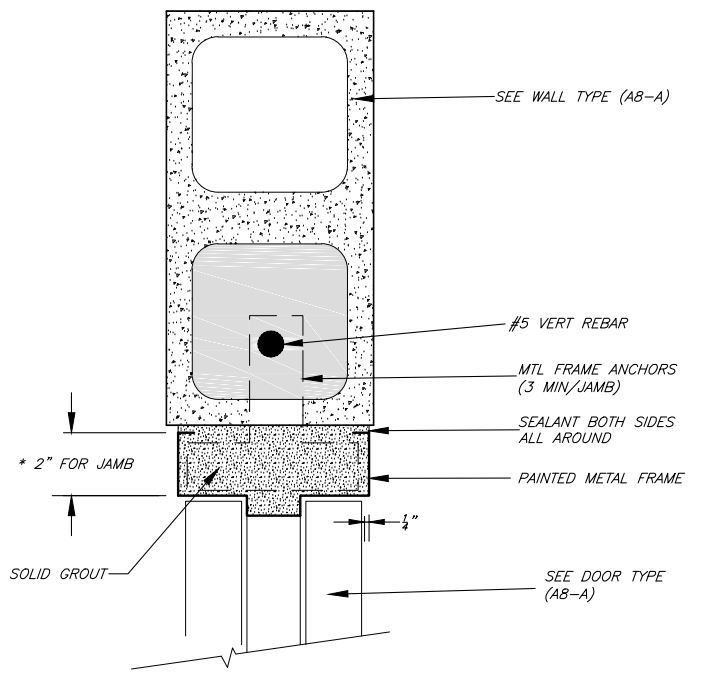

DOOR JAMB DETAIL 6
SCALE: NONE

| REVISION | DATE |
|----------|------|
| | |
| | |
| | | |
|--------------|-----------|---------|
| SLS DESIGNED | SLS DRAWN | CHECKED |
| | | |

SCALE: 24"x36" AS-SHOWN
11"x17" AS-SHOWN

