
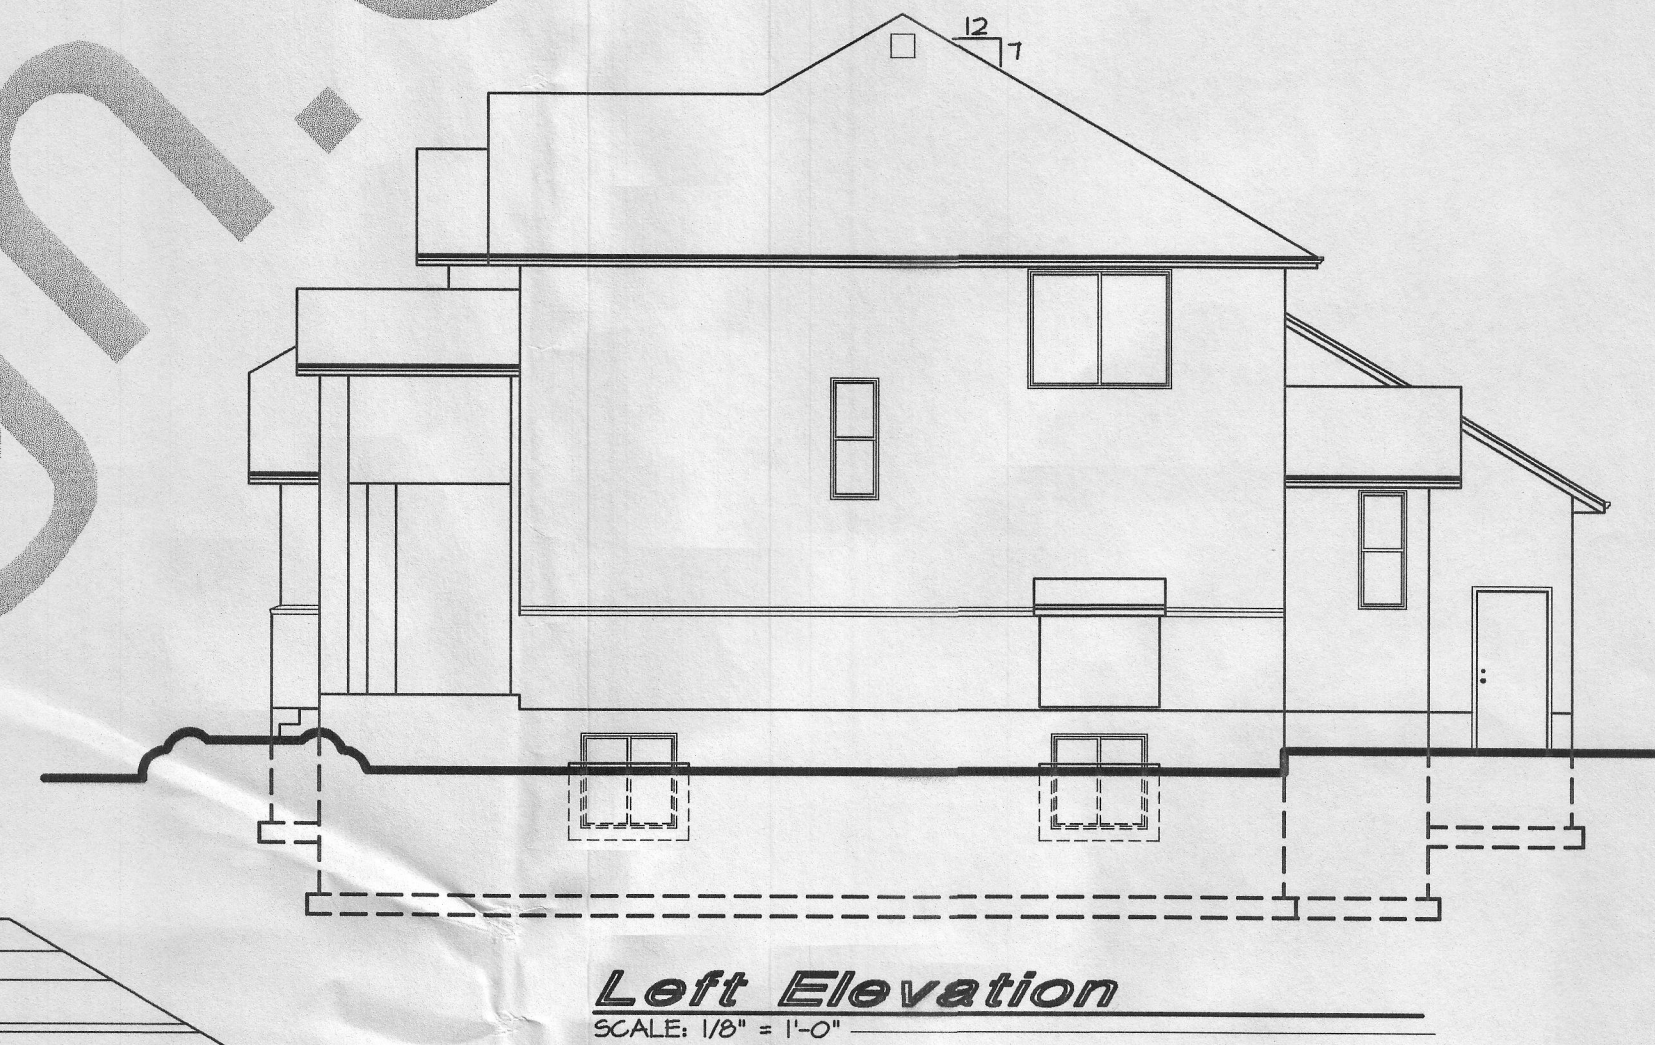


THE WORK ON THESE SHEETS WAS COMPLETED BY K&H DESIGN AND IS © COPYRIGHTED BY K&H DESIGN. K&H DESIGN GRANTS THE RIGHTS OF THIS WORK AND SHEETS TO BE USED BY THE CLIENT FOR WHOM K&H DESIGN COMPLETED THIS WORK TO BUILD THEIR ONE HOME. SINCE COPYRIGHTS ARE DIFFICULT TO ENFORCE, COPYRIGHTS ARE IN PLACE FOR MORAL AND ETHICAL ISSUES. YOUR OWN MORALS AND HOW YOU FEEL ABOUT YOUR OWN WORK WILL DETERMINE HOW YOU INTERPRET THE COPYRIGHT—BE IT LEGAL AND ETHICAL OR NOT.

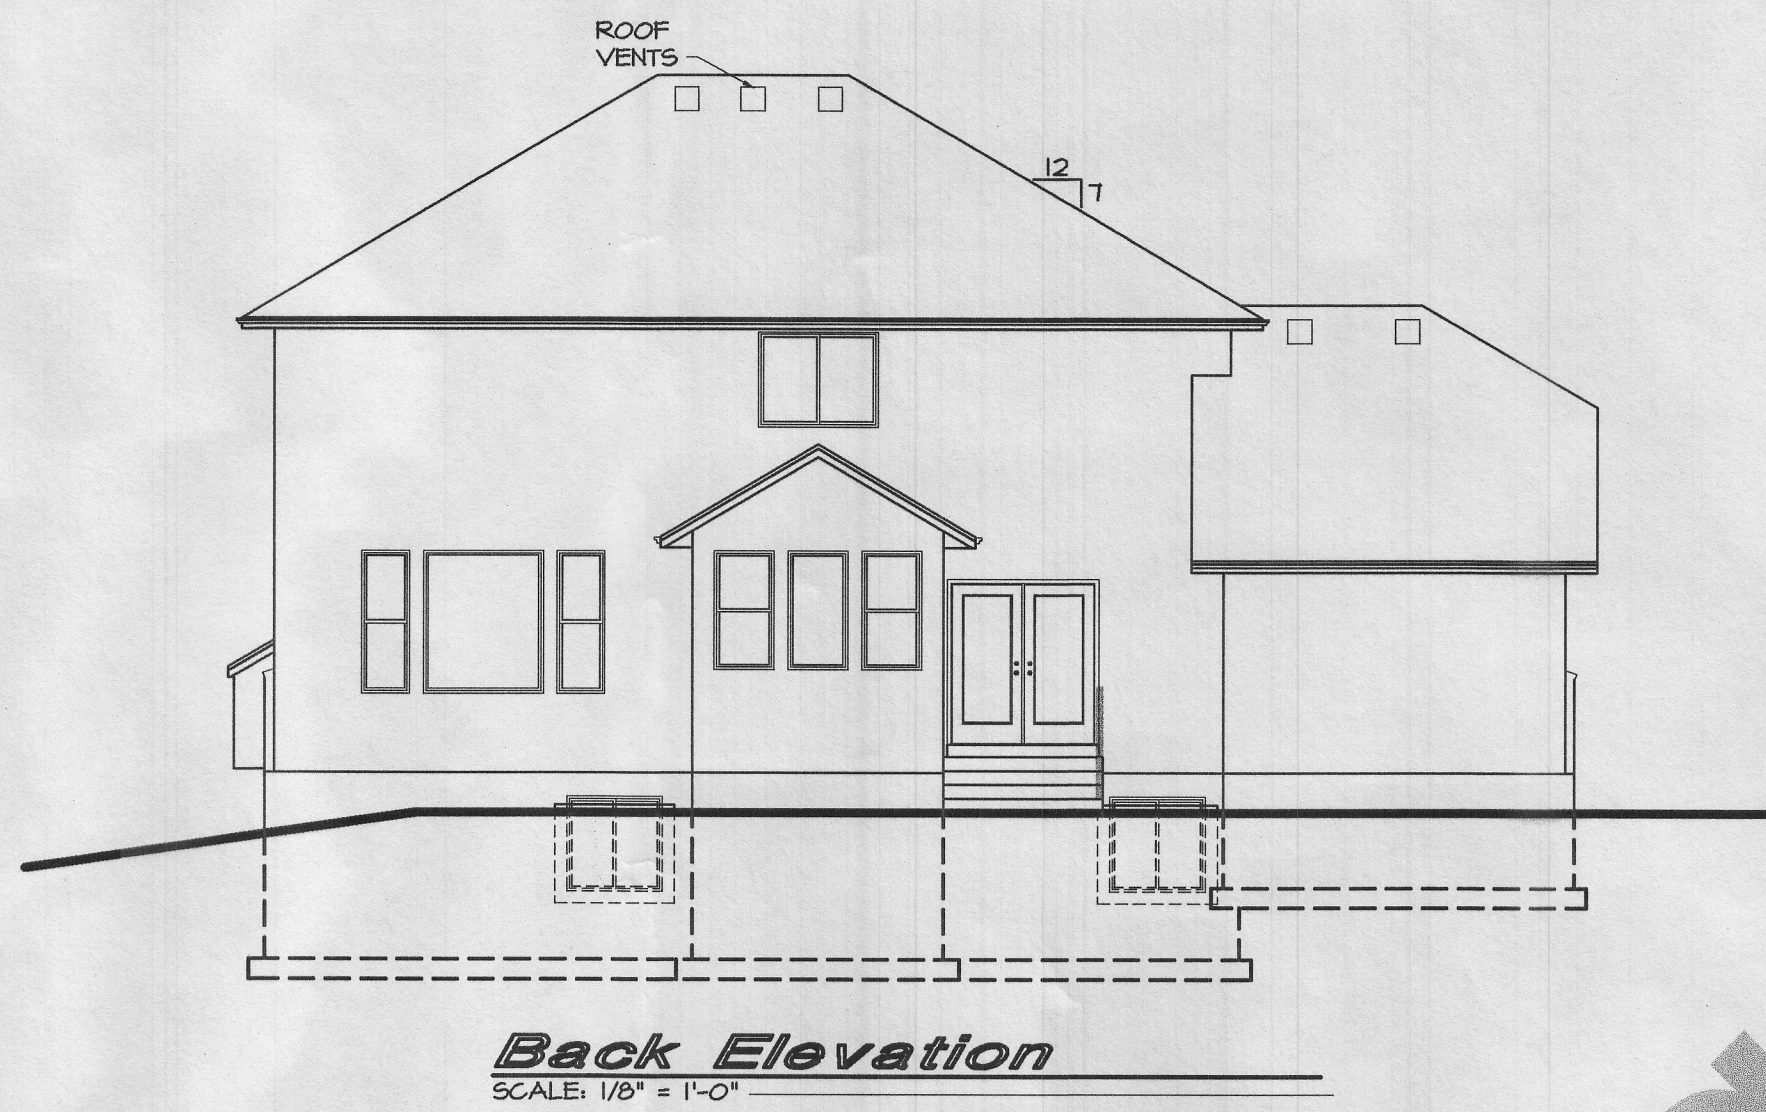

**Do Not Duplicate
Multiple Use Not Permitted**
This is in RED ink, any other color than RED indicates that this is an unauthorized copy.

Sheet Index

Sheet No.	Description	Sheet No.	Description	Sheet No.	Description
A4.1	Wall Sections	A2.2	Upper Level Floor Plan	A0	Plot Plan
D1.1	Typical Details	A3.1	Floor Joist Layout	A1.1	Elevations and Sheet Index
D1.2	Specifications	A3.2	Floor Joist Layout	A2.0	Foundation / Basement Plan
E2.1	Electrical Plans	A3.3	Roof Truss Layout	A2.1	Main Level Floor Plan

