

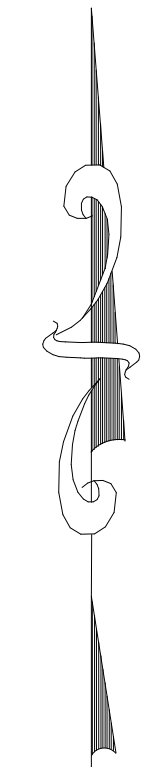
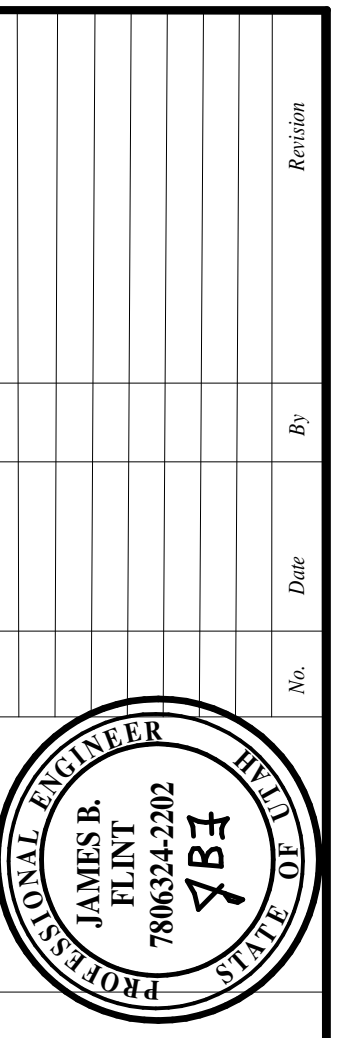
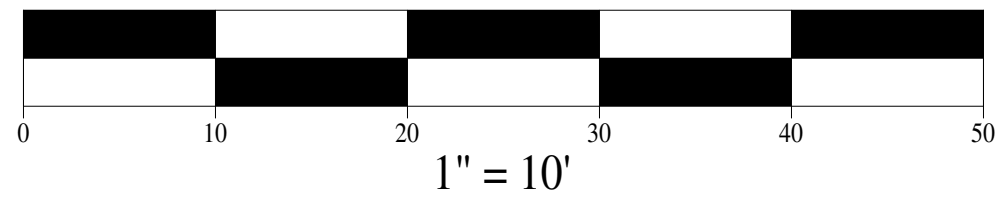


JORDAN HOLLOW SUBDIVISION

FRONTAGE PIPING PLAN

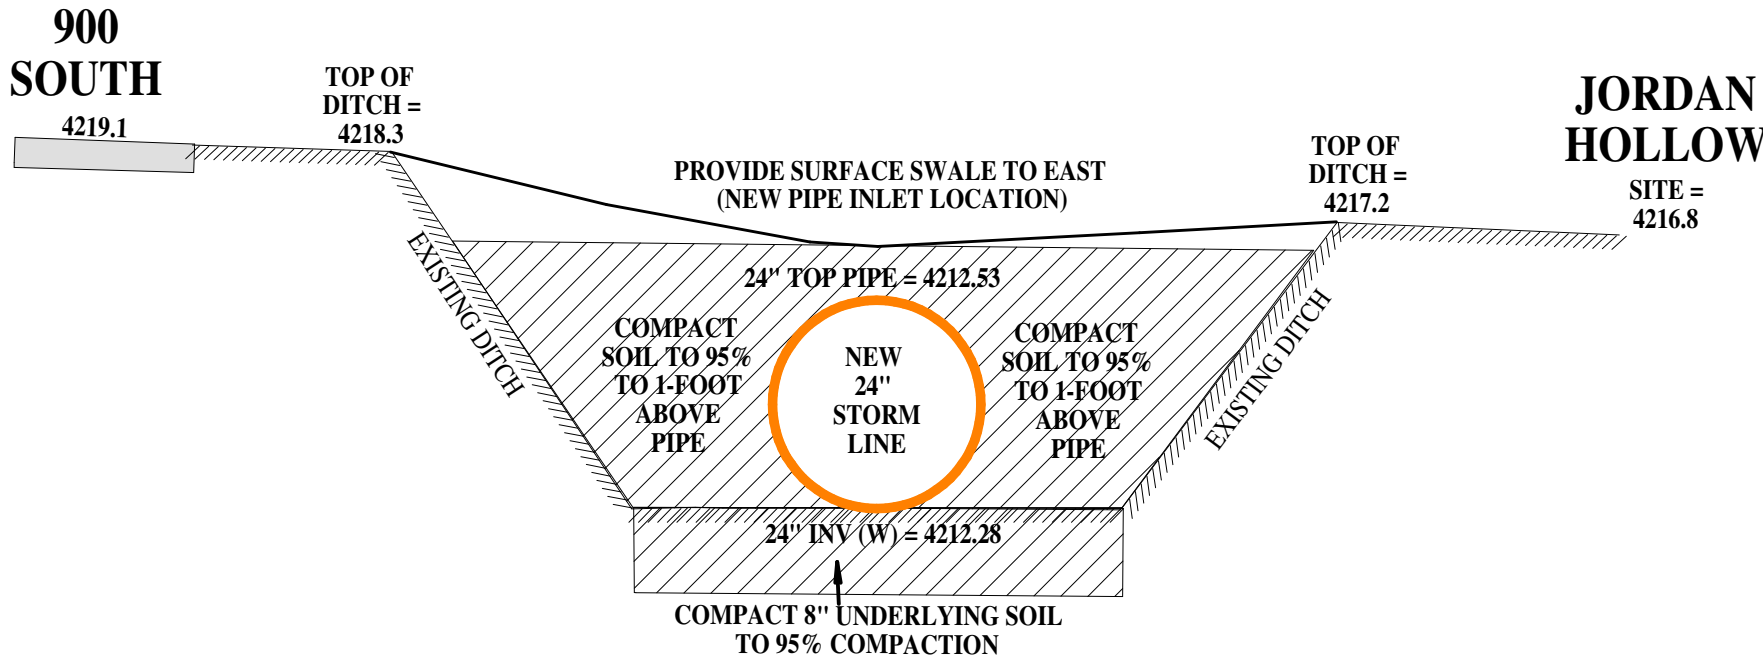

1" = 10'

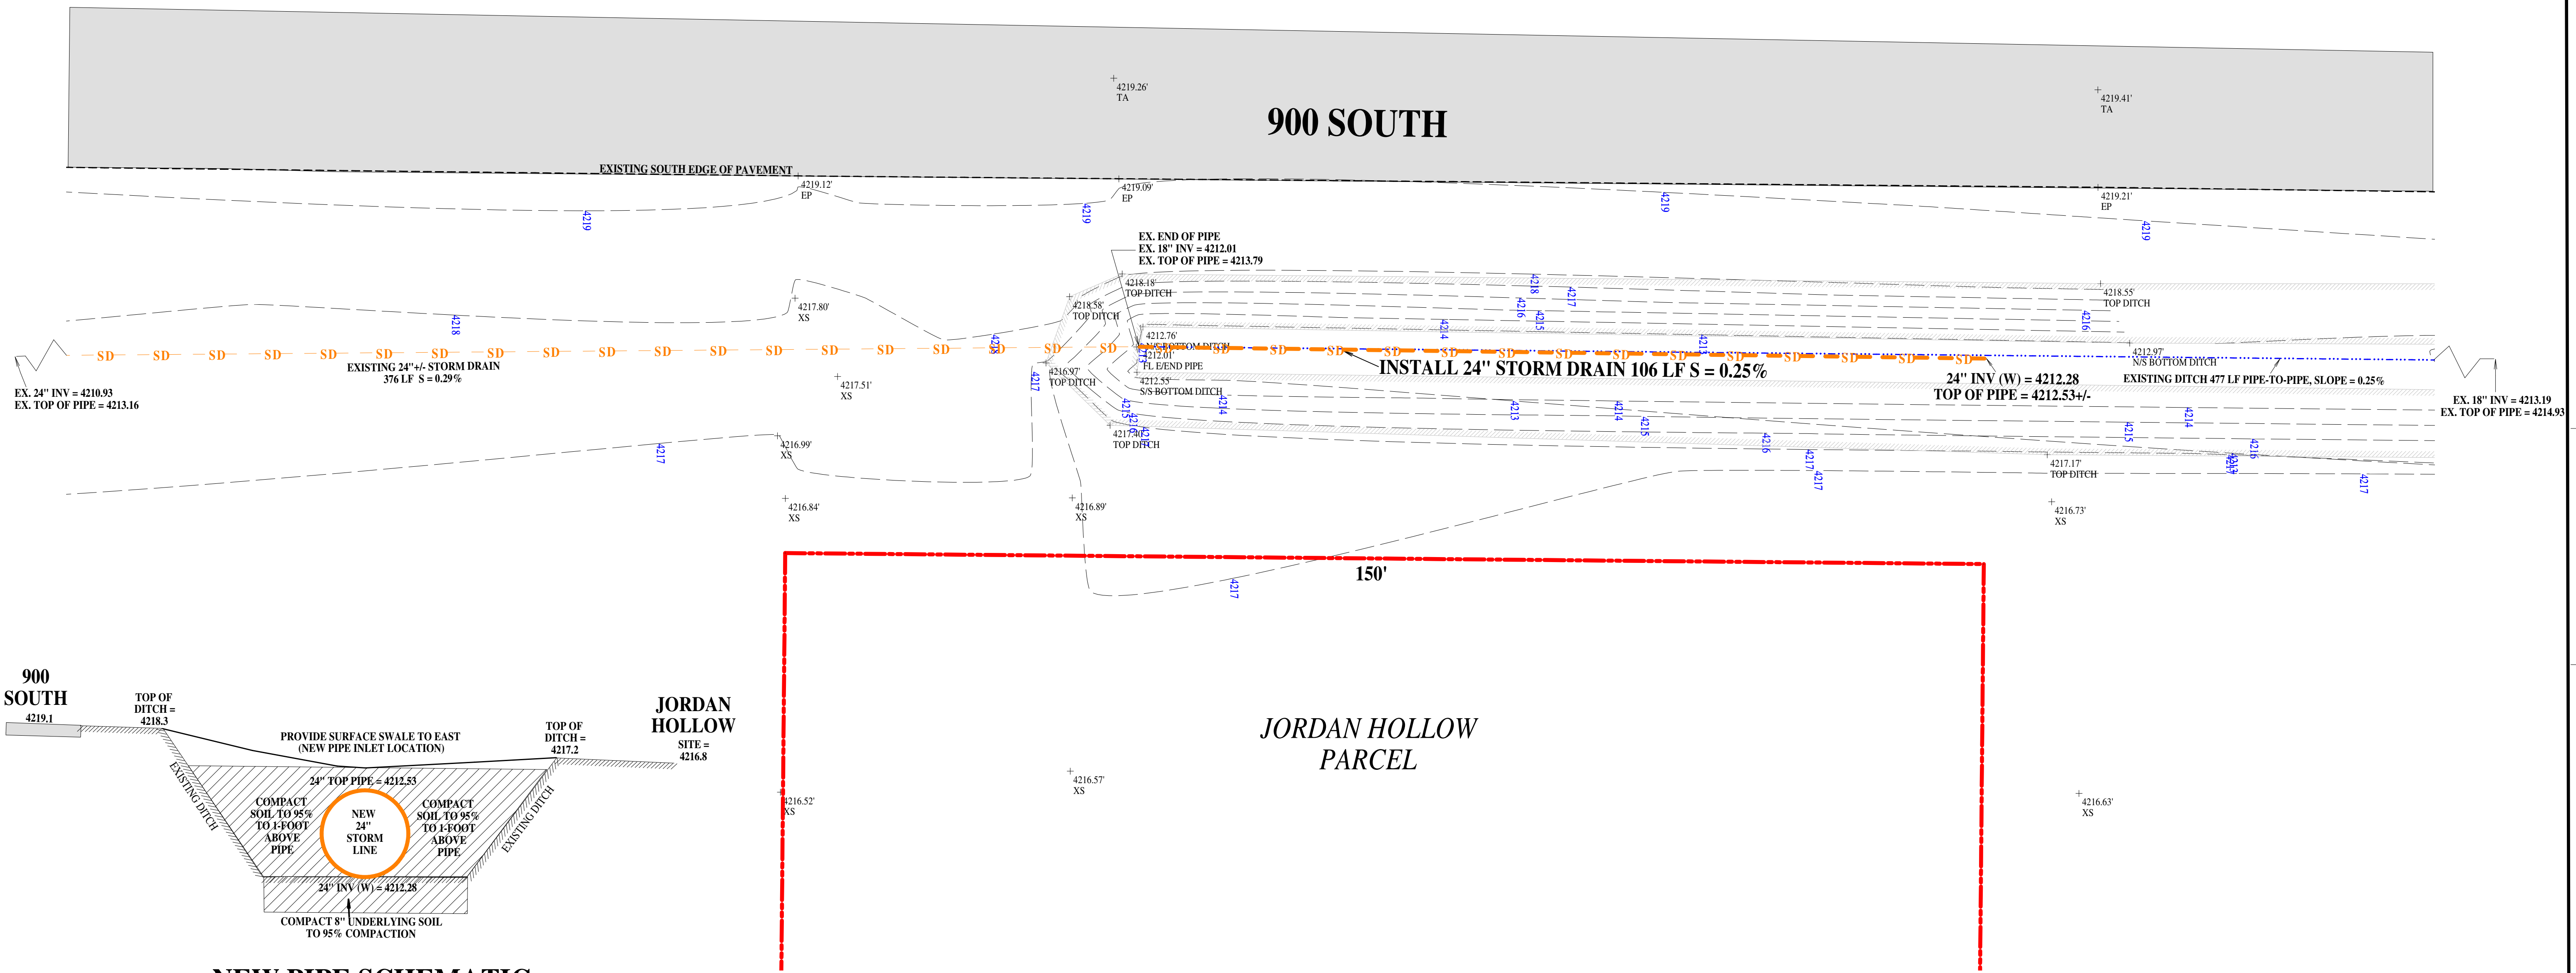

HANSEN & ASSOCIATES, INC.
 Consulting Engineers and Land Surveyors
 5-38 North Main Street, Brigham, Utah 84302
 (435) 723-3491 www.hates.net



Drawn By: MDE/WEBER
 Designed By: JLF
 Approved By: JLF
 Scale: 1" = 10'
 Drawing File: C:\COND\JORDAN\PCS
 JOB NUMBER: 13-5-52

JORDAN HOLLOW SUBDIVISION FRONTAGE PIPING PLAN
 WEBER COUNTY - APPROX. 8000 WEST 900 SOUTH

Sheet 1 of 1
 SLEETS
 FRONTAGE PIPING PLAN