



Plot Date: 4/25/2023 4:56 PM Printed By: Daniel Johnson
 Date Created: 4/25/2023 JUB:COM/CENTRAL/CLIENTS/UT/BONAVISTA/HOTSPRINGS/TANKS/STANSTING/DESIGN/CAD/SHEET/55-20-139 C-103X.DWG

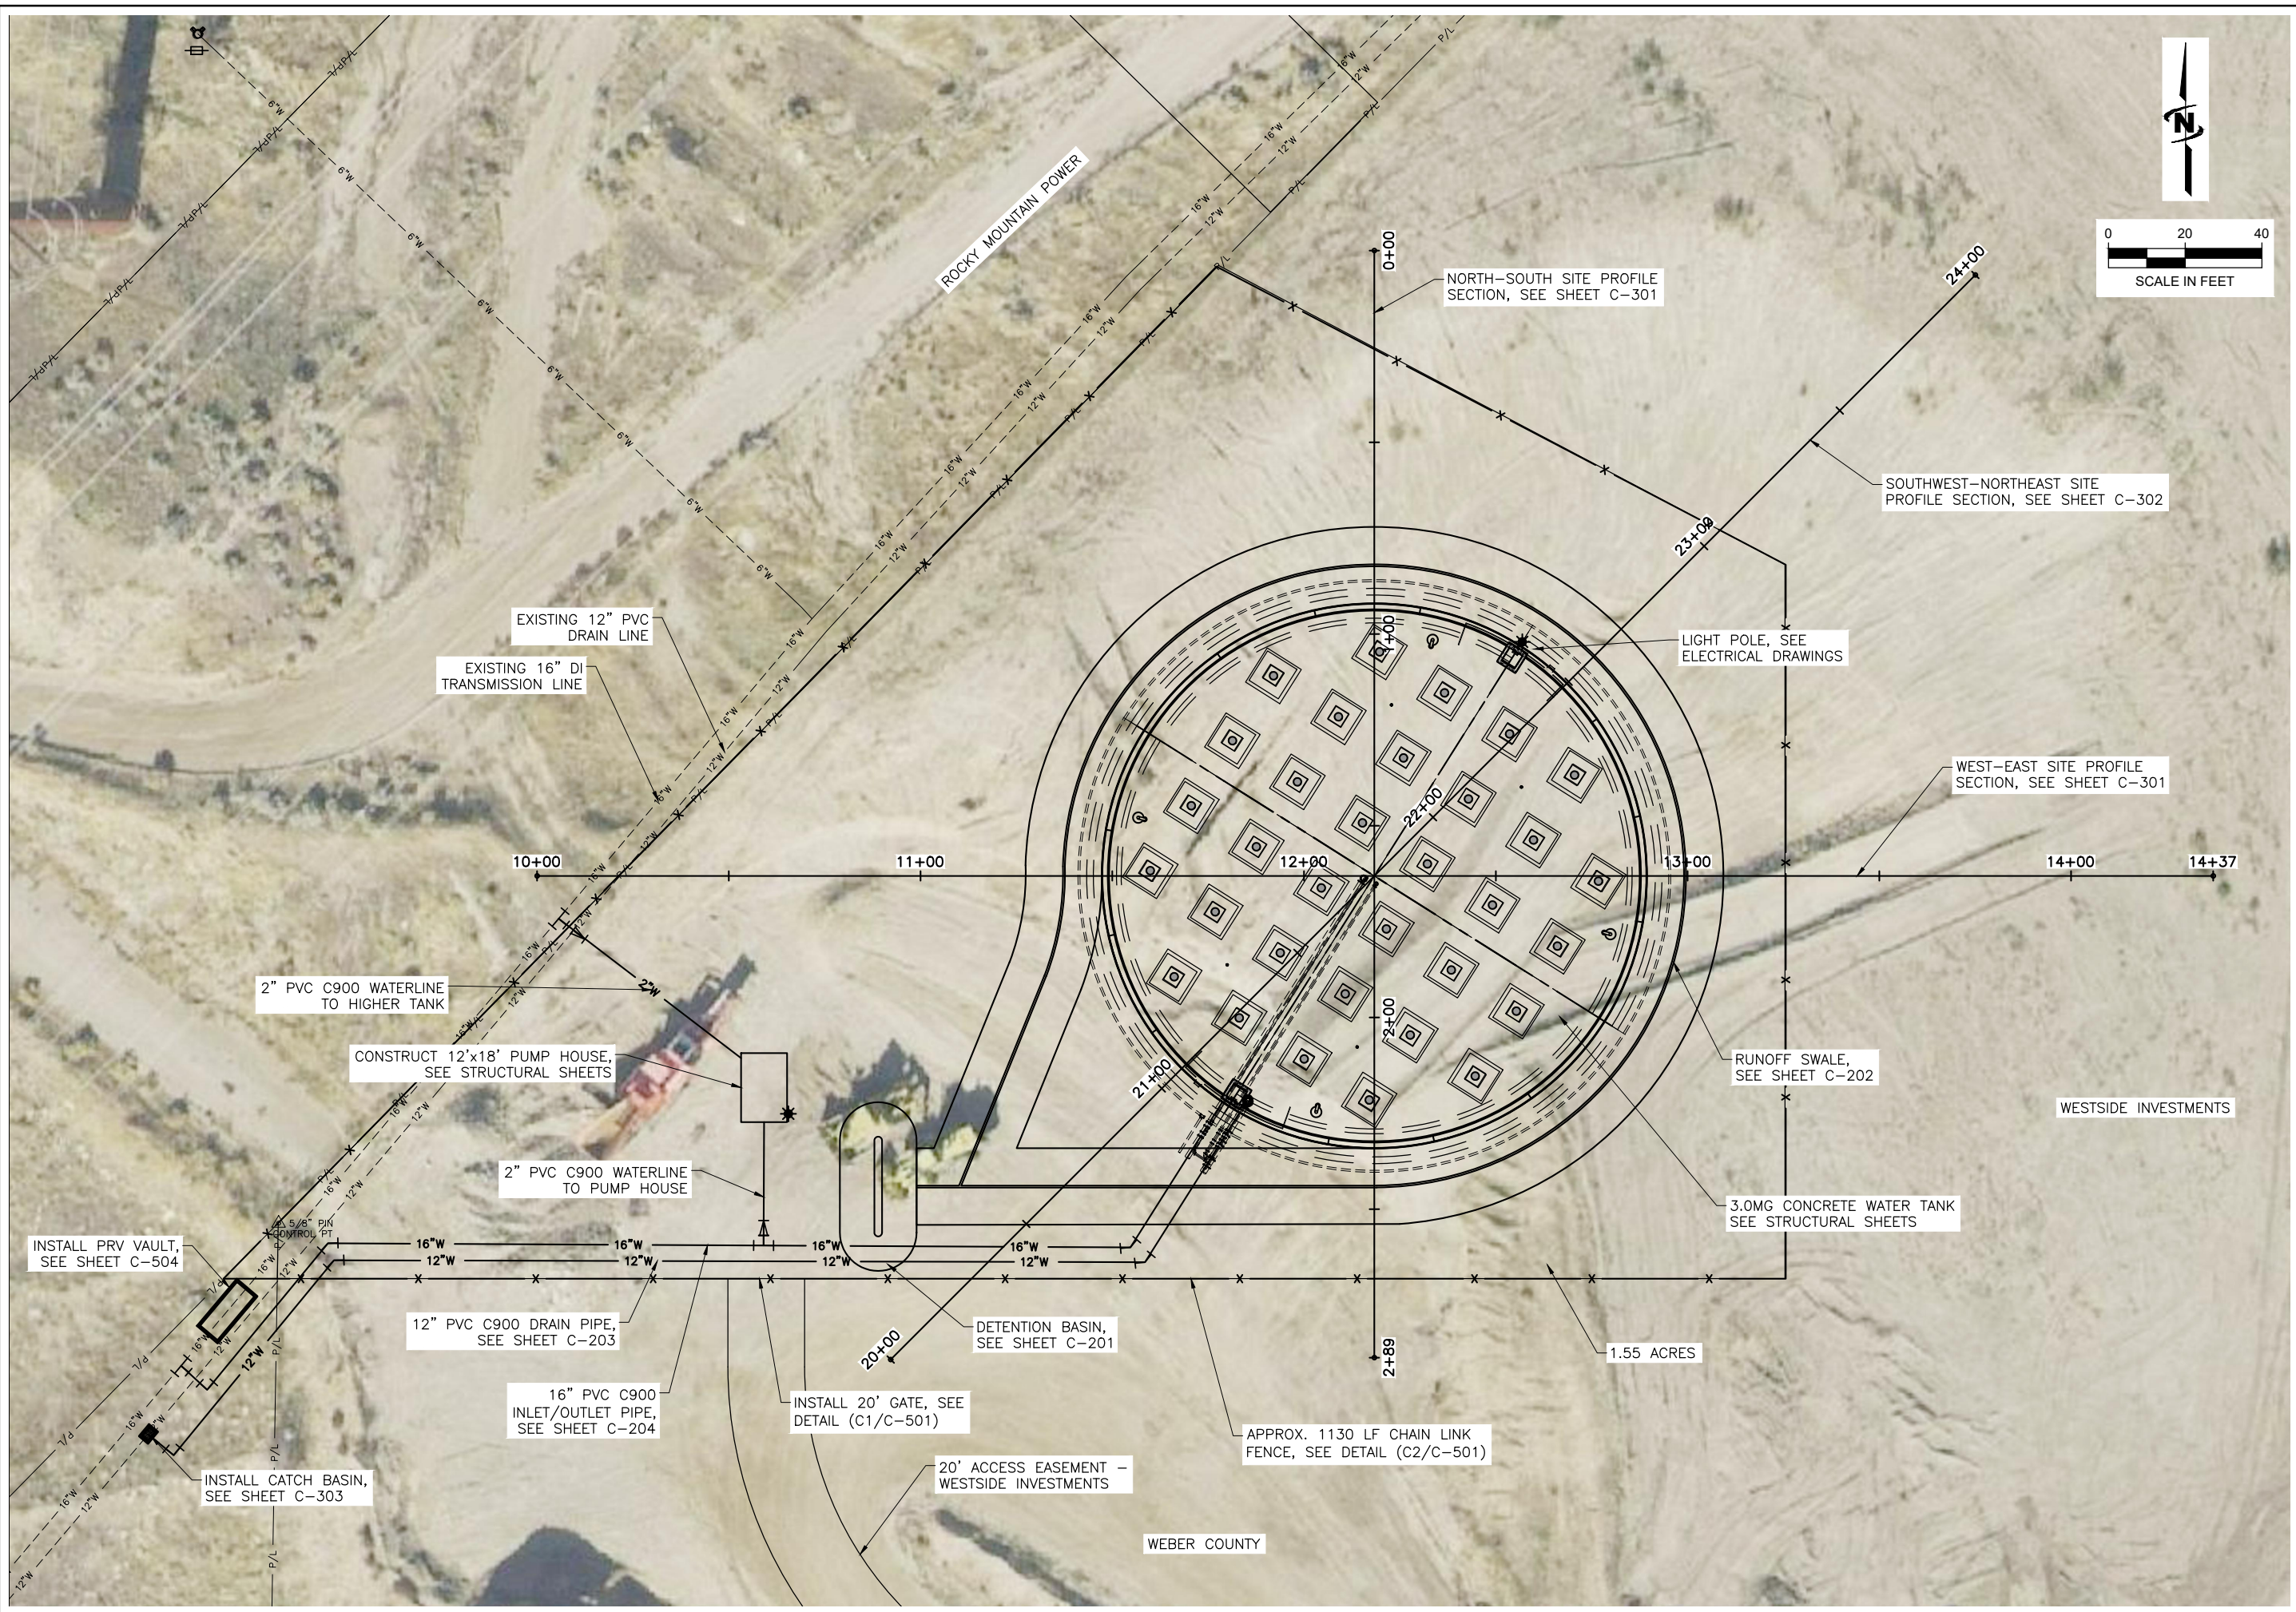


J-U-B ENGINEERS, INC.
 466 North 900 West
 Kaysville, Utah 84037
 Phone: 801.547.0393
 www.jub.com

PRELIMINARY PLANS
NOT FOR CONSTRUCTION

REUSE OF DRAWINGS
JUB SHALL RETAIN ALL COMMON LAW, STATUTORY, COPYRIGHT AND TRADE SECRET RIGHTS IN THIS DRAWING. THIS DRAWING SHALL NOT BE REUSED WITHOUT JUB'S PRIOR WRITTEN CONSENT. ANY REUSE WITHOUT WRITTEN CONSENT BY JUB WILL BE AT CLIENT'S SOLE RISK AND WITHOUT LIABILITY OR LEGAL EXPOSURE TO JUB.

NO.	REVISION	DESCRIPTION	BY	APPR.	DATE

HOT SPRINGS TANK
BONA VISTA WATER IMPROVEMENT DISTRICT
NEW 3MG TANK SITE PLAN

FILE: 55-20-139_C-103X
 JUB PROJ. #: 55-20-139
 DRAWN BY: DTJ
 DESIGN BY: GLS
 CHECKED BY: GLS
 AT FULL SIZE, IF NOT ONE INCH SCALE ACCORDINGLY
 LAST UPDATED: 4/25/2023
SHEET NUMBER: C-103